




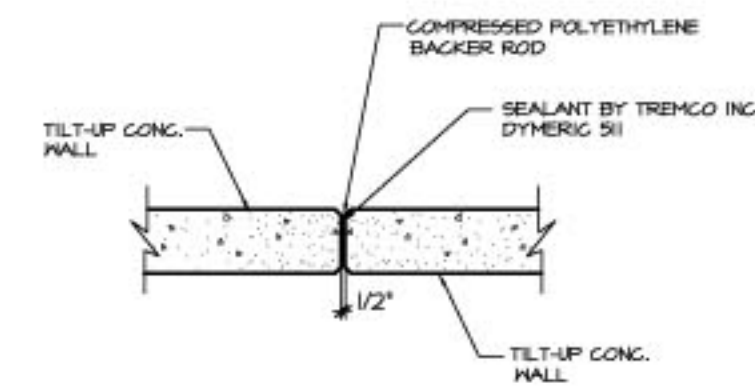


1 JOINT SYSTEM FOR 2HR. WALL U.L. SYSTEM NO. WW-D-0010
SCALE: 1/2" = 1'-0"

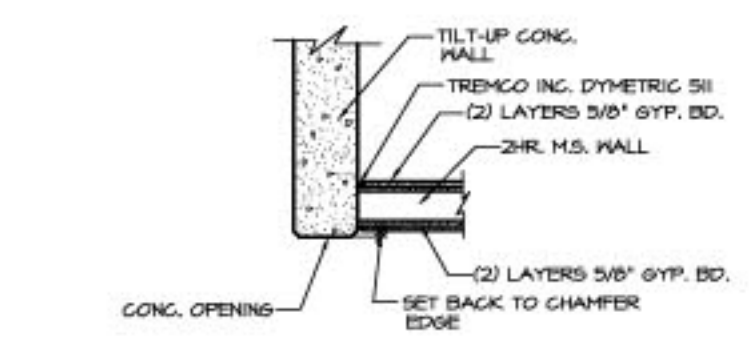


2 2 HR. WALL @ DOORS
SCALE: 1/2" = 1'-0"

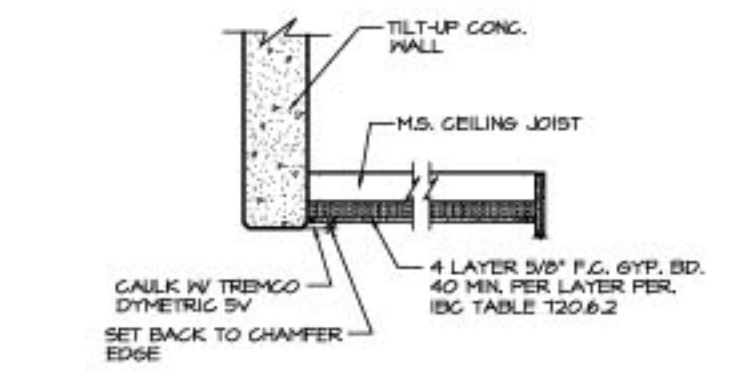

3 2 HR. CEILING @ DOORS
SCALE: 1/2" = 1'-0"

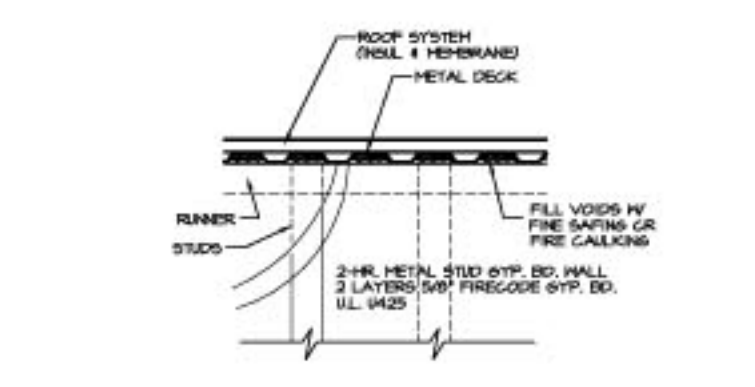

4 2 HR. WALL TERMINATION AT METAL ROOF DECK
SCALE: 3/4" = 1'-0"

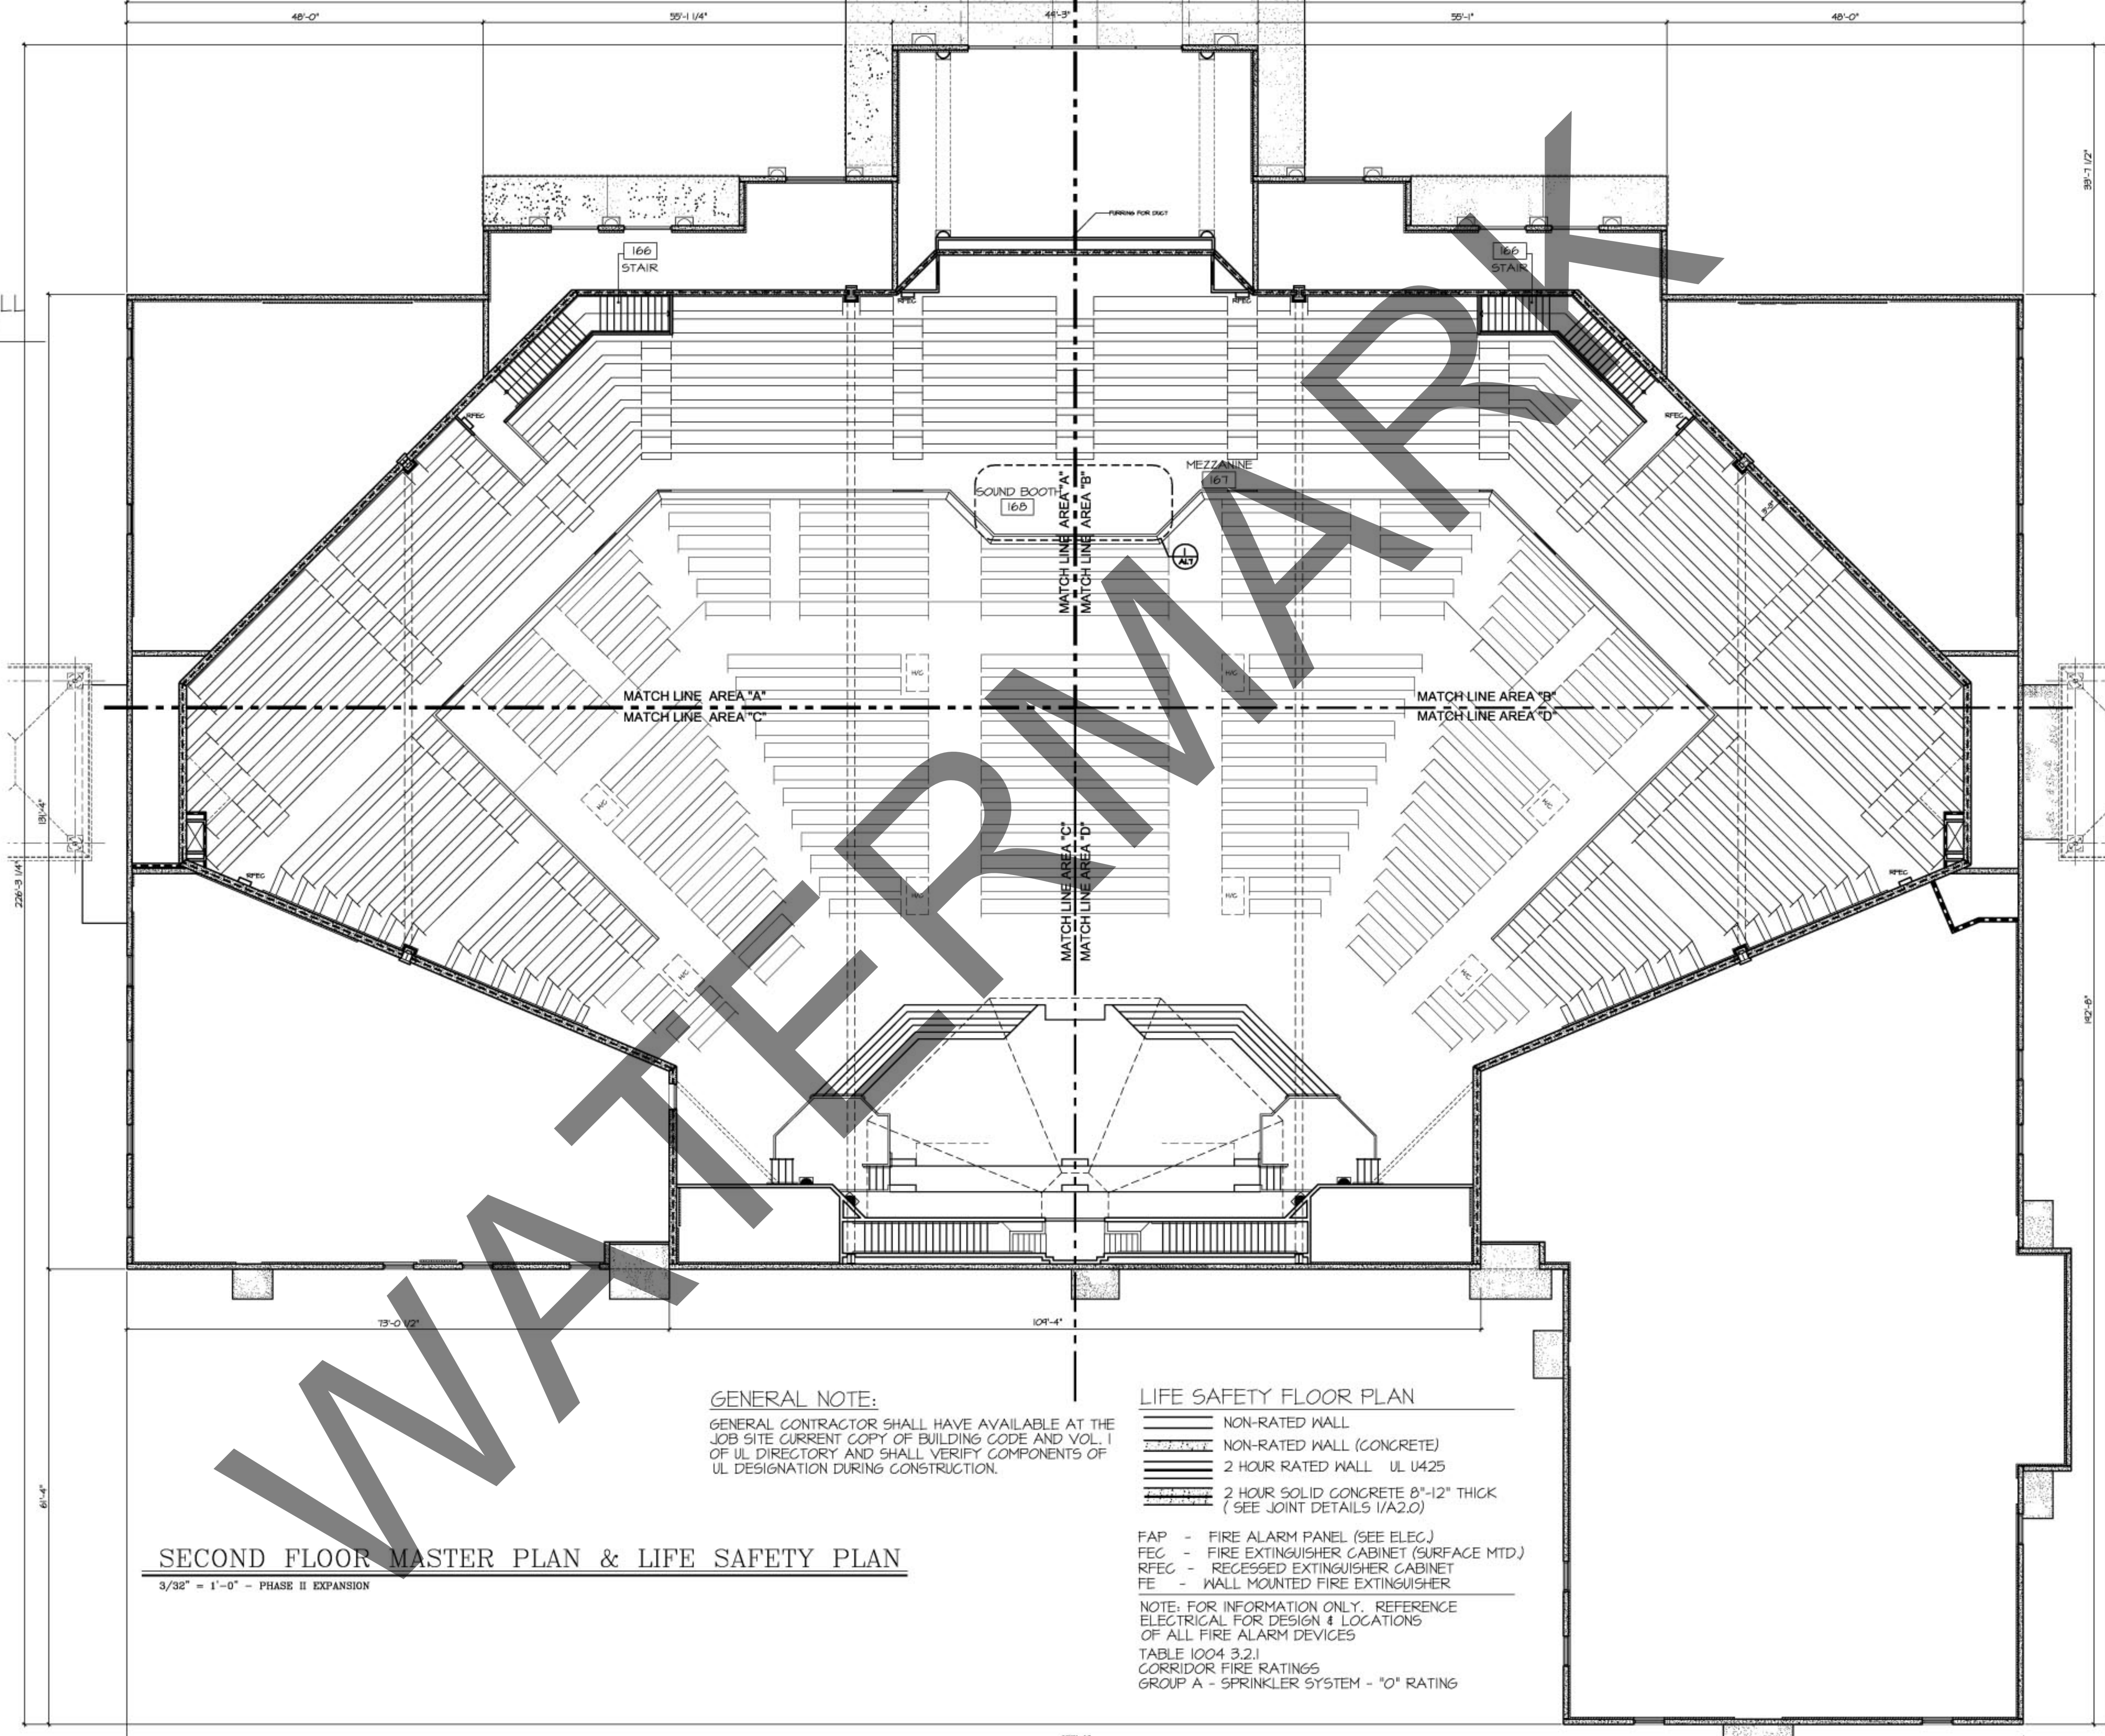

GENERAL NOTE:
GENERAL CONTRACTOR SHALL HAVE AVAILABLE AT THE JOB SITE CURRENT COPY OF BUILDING CODE AND VOL. 1 OF UL DIRECTORY AND SHALL VERIFY COMPONENTS OF UL DESIGNATION DURING CONSTRUCTION.

- LIFE SAFETY FLOOR PLAN
- NON-RATED WALL
 - NON-RATED WALL (CONCRETE)
 - 2 HOUR RATED WALL UL 1425
 - 2 HOUR SOLID CONCRETE 8"-12" THICK (SEE JOINT DETAILS 1/A2.0)
- FAP - FIRE ALARM PANEL (SEE ELEC.)
FEC - FIRE EXTINGUISHER CABINET (SURFACE MTD.)
RFEC - RECESSED EXTINGUISHER CABINET
FE - WALL MOUNTED FIRE EXTINGUISHER
- NOTE: FOR INFORMATION ONLY. REFERENCE ELECTRICAL FOR DESIGN & LOCATIONS OF ALL FIRE ALARM DEVICES
- TABLE 1004.3.2.1
CORRIDOR FIRE RATINGS
GROUP A - SPRINKLER SYSTEM - "0" RATING

SECOND FLOOR MASTER PLAN & LIFE SAFETY PLAN
3/32" = 1'-0" - PHASE II EXPANSION

SHEET FILE NAME:
DRAWN BY:
CHECKED BY:
APPROVED BY:
REVISION DATE:
REVISION NOTES: