

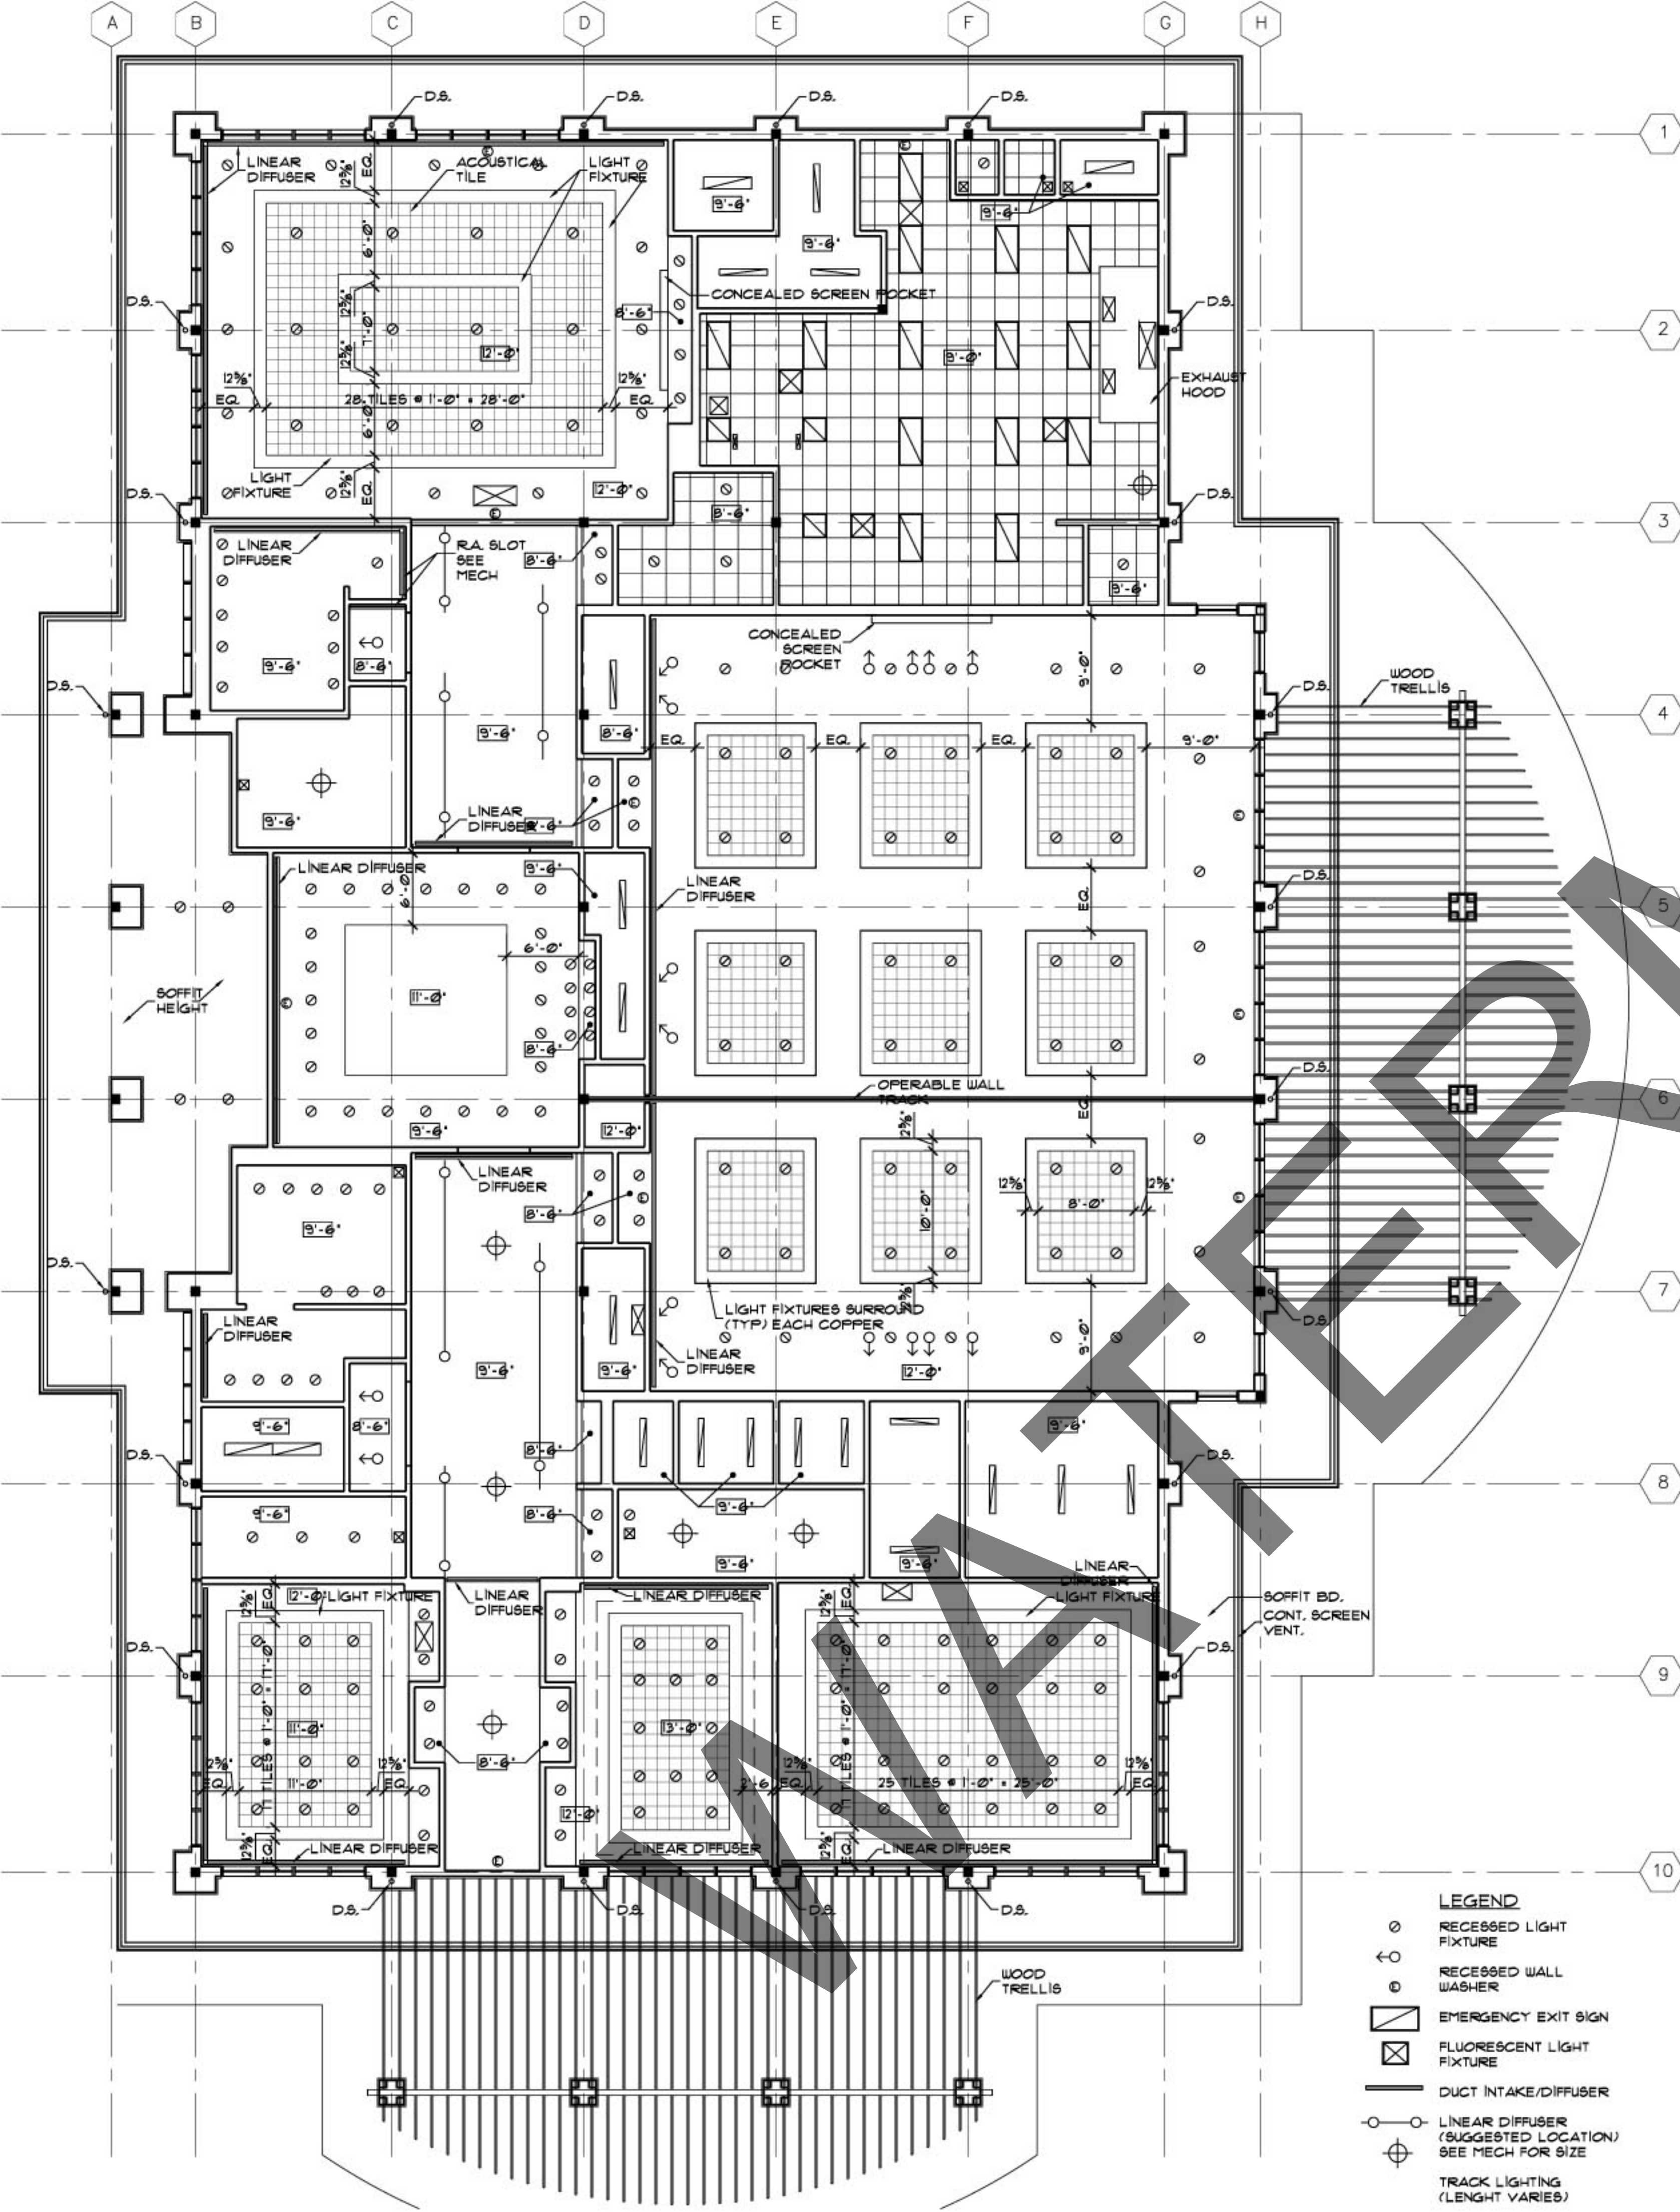


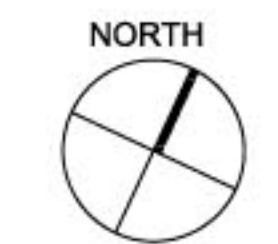

- LEGEND**
- RECESSED LIGHT FIXTURE
 - ◁ RECESSED WALL WASHER
 - EMERGENCY EXIT SIGN
 - ⊠ FLUORESCENT LIGHT FIXTURE
 - DUCT INTAKE/DIFFUSER
 - LINEAR DIFFUSER (SUGGESTED LOCATION) SEE MECH FOR SIZE
 - ⊕ TRACK LIGHTING (LENGTH VARIES)

1 REFLECTED CEILING PLAN
Scale : 1/8" = 1'-0"

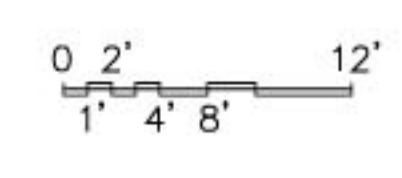

REFLECTED CEILING PLAN