


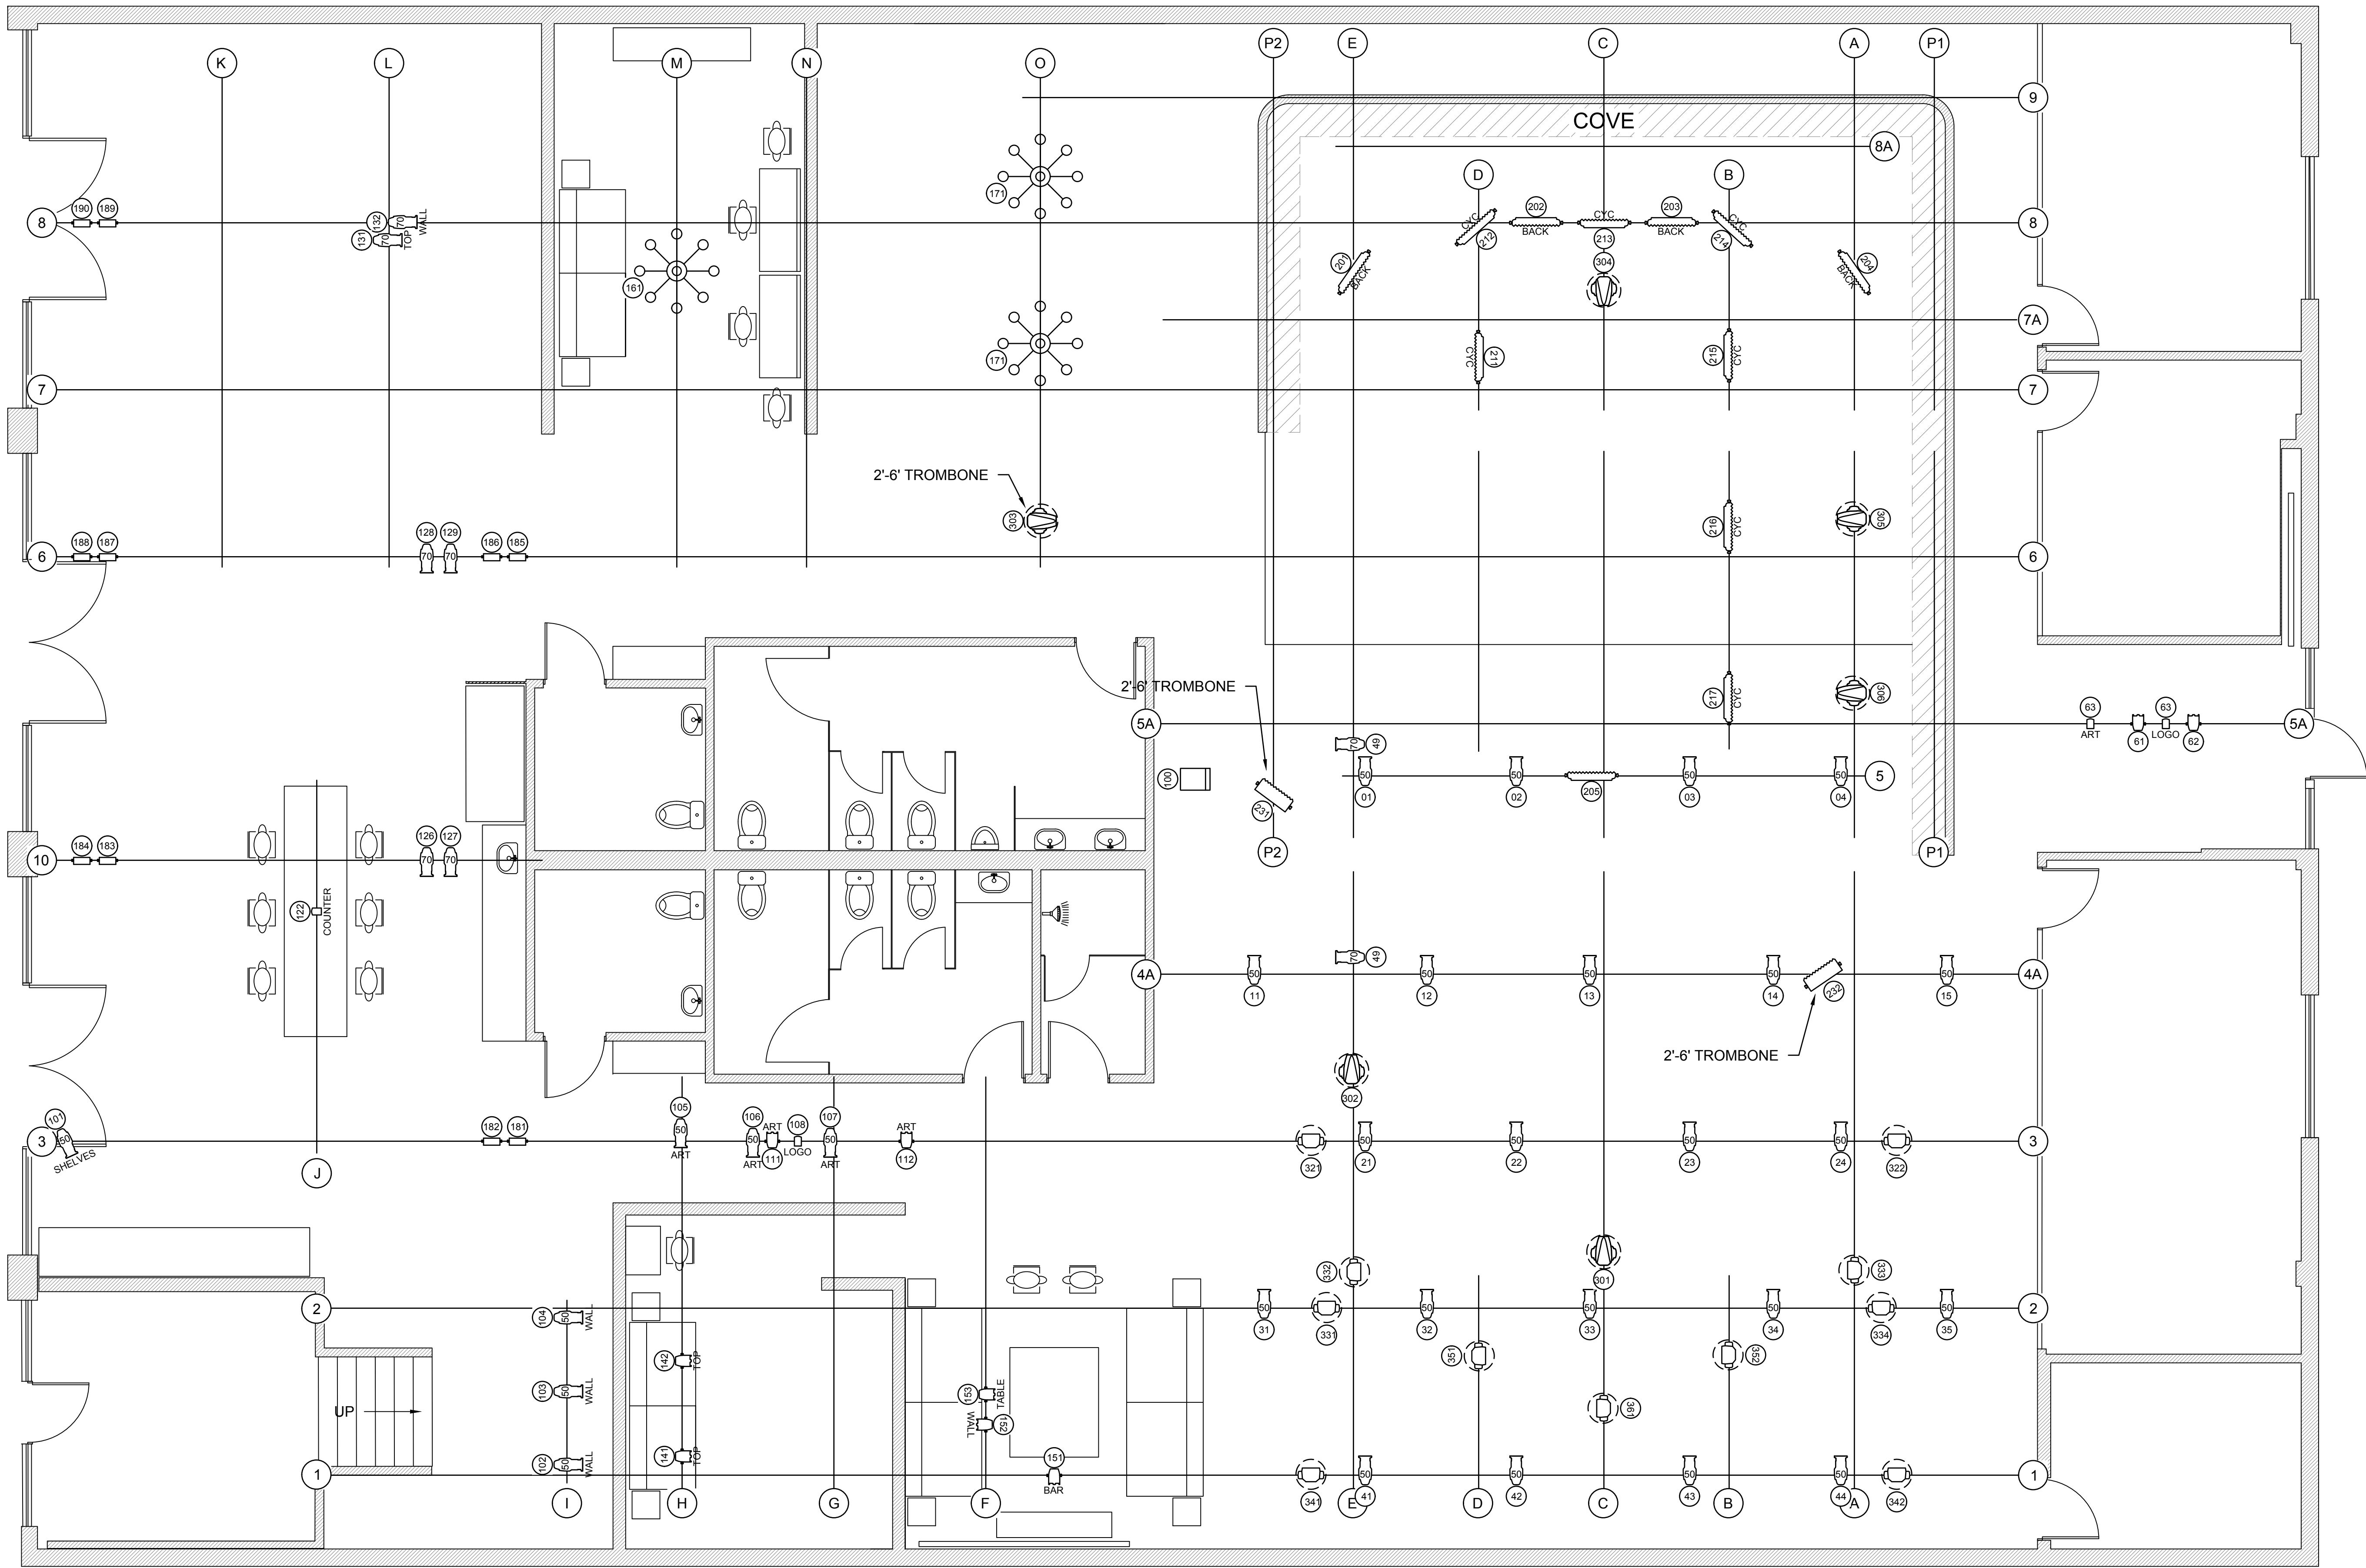

Notes:

SYMBOLS

- ETC 36 DEGREE S4 375W
- ETC 50 DEGREE S4 375W
- ETC 70 DEGREE S4 375W
- VELVET LIGHTS CYC4 80W
- CREAMSOURCE SPACE X 1200W
- CREAMSOURCE VORTEX 8 650W
- CHAUVET COLORADO 1 SOLO 60W
- CHAUVET COLORADO 2 SOLO 120W
- ALTMAN MICRO-PAR 20 W/BARNDOR 15W
- ALTMAN PAR 38 15W
- ARYTON DIABLO S SPOT 300W
- MAC AURA 260W
- RGB WASHLIGHT
- MASTER FX MYSTIC HAZER

lulu
STUDIOS

1473 East 4th Street
Los Angeles, Ca 90033
hi@lulu.ar
+1 323-333-4270
lulu.ar

TITLE:			
LIGHTING PLAN			
SCALE: 1/4" = 1'-0"	DATE: 11/11/2025	DRAWN:	CHECKED:
PROJECT NO:	DRAWING NO:	REVISION: P	