

S:\VAL PROJECTS\Project 22\2242 ETERNITY FULL GOSPEL FELLOWSHIP\2242B ETERNITY FULL GOSPEL FELLOWSHIP HALL.dwg

ETERNITY FULL
GOSPEL FELLOWSHIP
HALL RE-BID
932 MULBERRY STREET
WESTLAKE, LOUISIANA, 70669
CALCASIEU PARISH

PASTOR MARIE CARRIER
PHONE:337-370-4436
EMAIL: PASTORCARRIER@BELLCSOUTH.NET

GENERAL NOTES

1. ALL WORK SHALL COMPLY WITH FEDERAL, STATE, AND LOCAL LAWS.

2. THE CONTRACTOR IS RESPONSIBLE FOR VERIFYING THE EXTENT, NATURE, AND SCOPE OF WORK DESCRIBED IN THESE DOCUMENTS AND IS RESPONSIBLE FOR PROVIDING ALL LABOR, MATERIALS, EQUIPMENT, TRANSPORTATION, DELIVERY, HANDLING, SERVICES, SUPERVISION AND QUALITY CONTROL REQUIRED TO EXECUTE ALL AS WORK AS DELINEATED IN THESE DRAWINGS UNLESS AS SPECIFICALLY NOTED AS OUTSIDE OF THE CONTRACT.

3. THE CONTRACTOR IS RESPONSIBLE FOR COORDINATING ALL WORK WITH ALL TRADES INCLUDING THOSE OPERATING UNDER SEPARATE CONTRACTS WITH THE OWNER.

4. ALL WORK SHALL BE PERFORMED BY SKILLED AND QUALIFIED WORKERS IN ACCORDANCE WITH ESTABLISHED "BEST PRACTICES."

5. CONTRACTOR SHALL FAMILIARIZE HIMSELF WITH ALL EXISTING CONDITIONS AND ANY DIFFICULTIES OR RESTRICTIONS AFFECTING THE EXECUTION OF THE CONTRACT PRIOR TO SUBMITTING A PROPOSAL.

6. ALL PRODUCTS, MATERIALS, AND EQUIPMENT SHALL BE INSTALLED IN ACCORDANCE WITH THE MANUFACTURER'S SPECIFIC INSTRUCTIONS AS WELL AS IN COMPLIANCE WITH ALL APPLICABLE CODES.

7. JOB SAFETY IS THE SOLE RESPONSIBILITY OF THE CONTRACTOR.

8. CONTRACTOR SHALL VERIFY LOCATIONS, LEVELS, DISTANCES, AND FEATURES THAT MAY AFFECT THE WORK. SHOULD EXISTING CONDITIONS DIFFER FROM THOSE SHOWN OR INDICATED, OR IF IT APPEARS THAT THESE PLANS, STANDARD SPECIFICATIONS, AND SPECIAL PROVISIONS DO NOT ADEQUATELY DETAIL THE WORK TO BE DONE, CONTRACTOR SHALL NOTIFY THE ARCHITECT PRIOR TO CONTINUING WITH ANY RELATED WORK. NO ALLOWANCE WILL BE MADE IN HIS BEHALF FOR ANY EXTRA EXPENSE RESULTING FROM FAILURE OR NEGLIGENCE IN DETERMINING THE CONDITIONS UNDER WHICH WORK IS TO BE PERFORMED. NOTED DIMENSIONS TAKE PRECEDENCE OVER SCALE.
9. CONTRACTOR SHALL PROVIDE ANY AND ALL NECESSARY TEMPORARY SHORING, BRACING, AND BARRICADES NECESSARY TO INSURE SAFE EXECUTION OF CONSTRUCTION AND DEMOLITION.

10. CONTRACTOR AGREES TO ASSUME SOLE AND COMPLETE RESPONSIBILITY FOR THE JOB SITE DURING THE COURSE OF CONSTRUCTION OF THIS PROJECT, INCLUDING SAFETY OF ALL PERSONS AND PROPERTY; THAT THIS REQUIREMENT SHALL APPLY CONTINUOUSLY AND NOT BE LIMITED TO NORMAL WORKING HOURS; AND THAT THE CONTRACTOR SHALL DEFEND, INDEMNIFY, AND HOLD THE CITY REPRESENTATIVES HARMLESS FROM ANY AND ALL LIABILITY, REAL AND/OR ALLEGED, IN CONJUNCTION WITH THE PERFORMANCE OF THIS PROJECT.

11. CONTRACTOR SHALL BE RESPONSIBLE FOR PROVIDING SUITABLE TRASH CONTAINERS AND TIMELY TRASH REMOVAL FROM THE SITE CONSISTENT WITH THE STAGE OF CONSTRUCTION. WORK AREA SHALL BE KEPT CLEAN, SAFE, AND ORDERLY AT ALL TIMES.

12. ALL DIMENSIONS, ANGLES, ELEVATIONS, CONDITIONS, AND PHYSICAL CONFIGURATIONS RELATIVE TO EXISTING CONDITIONS SHALL BE FIELD VERIFIED BY THE CONTRACTOR PRIOR TO COMMENCING WORK OR ORDERING MATERIAL. IF ANY DIFFERENCES ARE FOUND, THE ARCHITECT SHOULD BE NOTIFIED IMMEDIATELY.

13. DO NOT SCALE DRAWINGS! WRITTEN DIMENSIONS SHALL GOVERN. NOTIFY ARCHITECT FOR ANY DIMENSIONS NOT SHOWN.

14. THESE DRAWINGS ARE INTENDED TO DEFINE THE GENERAL DESIGN AND SCOPE OF THE WORK REQUIRED TO COMPLETE THE PROJECT. IT IS THE INTENT OF THESE DOCUMENTS TO PROVIDE FOR COMPLETE FINISHED WORK AND OPERATING SYSTEMS. OMISSIONS FOUND IN THESE DRAWINGS DO NOT RELIEVE THE CONTRACTOR OF SUCH RESPONSIBILITIES AS IMPLIED BY THE SCOPE OF WORK UNLESS SPECIFICALLY NOTED.

15. ALL WORK WILL BE SUBJECT TO REVIEW AND ACCEPTANCE BY THE OWNER UPON COMPLETION OF THE WORK.

TABLE OF CONTENTS

- G-100

S-100

A-100

A-101

A-200

A-300

A-301

A-400

A-401

F-100

M-100

E-100
- COVER SHEET

FOUNDATION PLAN

SITE PLAN

ENLARGED SITE PLAN

FLOOR PLAN

EXTERIOR ELEVATIONS

EXTERIOR ELEVATIONS

INTERIOR ELEVATIONS

VENT HOOD & CANOPY DETAILS

PLUMBING PLAN & DETAILS


MECHANICAL PLAN & DETAILS

ELECTRICAL LIGHTING PLAN & DETAILS

PROJECT SCOPE:

THE PROJECT ENTAILS FURNISHING LABOR, MATERIALS, TOOLS AND EQUIPMENT NECESSARY FOR THE CONSTRUCTION OF ETERNITY FULL GOSPEL FELLOWSHIP HALL'S NEW BUILDING. THE INSTALLATION OF ALL NEW MATERIALS SHALL BE PERFORMED IN STRICT ACCORDANCE WITH THE MANUFACTURER'S WRITTEN INSTALLATION INSTRUCTIONS, AND IN ACCORDANCE WITH ALL APPROVED SHOP DRAWINGS.

VICINITY MAP

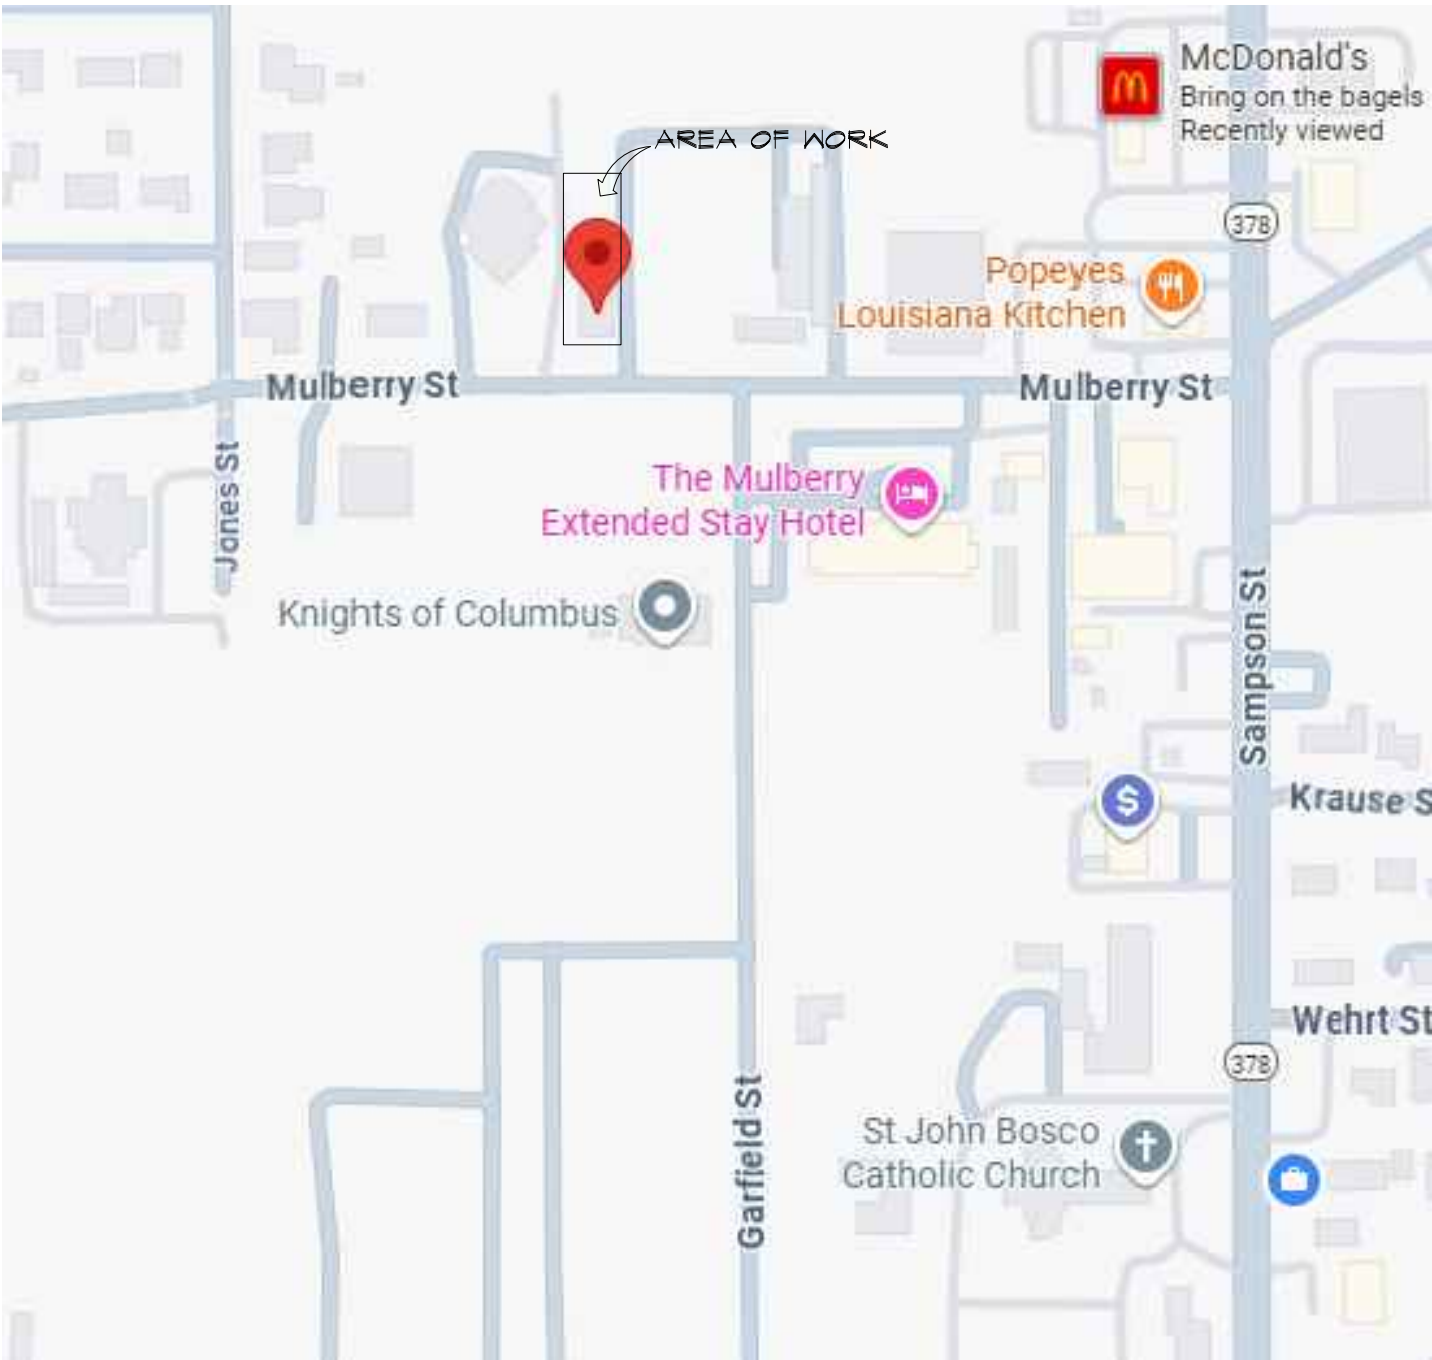

KING

architects INC.

Barry D. King, AIA,
Architect

1312 Sampson St.
Westlake, LA 70669

337.494.0806

www.kingarchitects.net

© COPYRIGHT 2026
ALL INFORMATION, EITHER DRAWN, WRITTEN, OR IMPLIED APPEARING IN THIS DOCUMENT SHALL NOT BE DUPLICATED, DISCLOSED, OR OTHERWISE USED WITHOUT THE WRITTEN PERMISSION OF BARRY D. KING AIA. THIS DOCUMENT IS AN INSTRUMENT OF SERVICE AND IS THE SOLE PROPERTY OF THE AUTHOR. FURTHERMORE, THE USE OF THIS DOCUMENT FOR ANY PURPOSE SHALL BE REVOKED, IF THE INTENT OF THE DESIGN OR THE CONSTRUCTION TECHNIQUES OR DETAILS SHOWN HEREIN ARE NOT ADHERED TO OR THE CONTRACTUAL AGREEMENT COVERING THEIR USE ARE NOT STRICTLY ADHERED TO.

JOB NO: 2242
DATE: 7/7/26
DRWN. BY: C.J. NT
CHKD. BY: JC

REVISIONS



ETERNITY FULL GOSPEL
FELLOWSHIP HALL RE-BID
932 MULBERRY ST.
WESTLAKE, LA 70669
CALCASIEU PARISH

COVER
SHEET

G-100

DESIGN CRITERIA

FIRE PROTECTION

VENT HOOD BY OTHERS

CONSTRUCTION:

V-B

DESIGN LOADS:

WIND ZONE: 128 MPH
RISK CATEGORY: 2


APPLICABLE CODES:

2021 INTERNATIONAL BUILDING CODE
2021 NFPA 101 LIFE SAFETY CODE
AMERICANS W/ DISABILITIES ACT (ADA)
2021 INTERNATIONAL PLUMBING CODE


OCCUPANCY TYPE:

OCCUPANCY - GROUP A-2
USE - ASSEMBLY
SPACE 3,056 SQ. FT.


S:\ALL PROJECTS\Project 22\2242 ETERNITY FULL GOSPEL FELLOWSHIP\2242B ETERNITY FULL GOSPEL FELLOWSHIP HALL.dwg

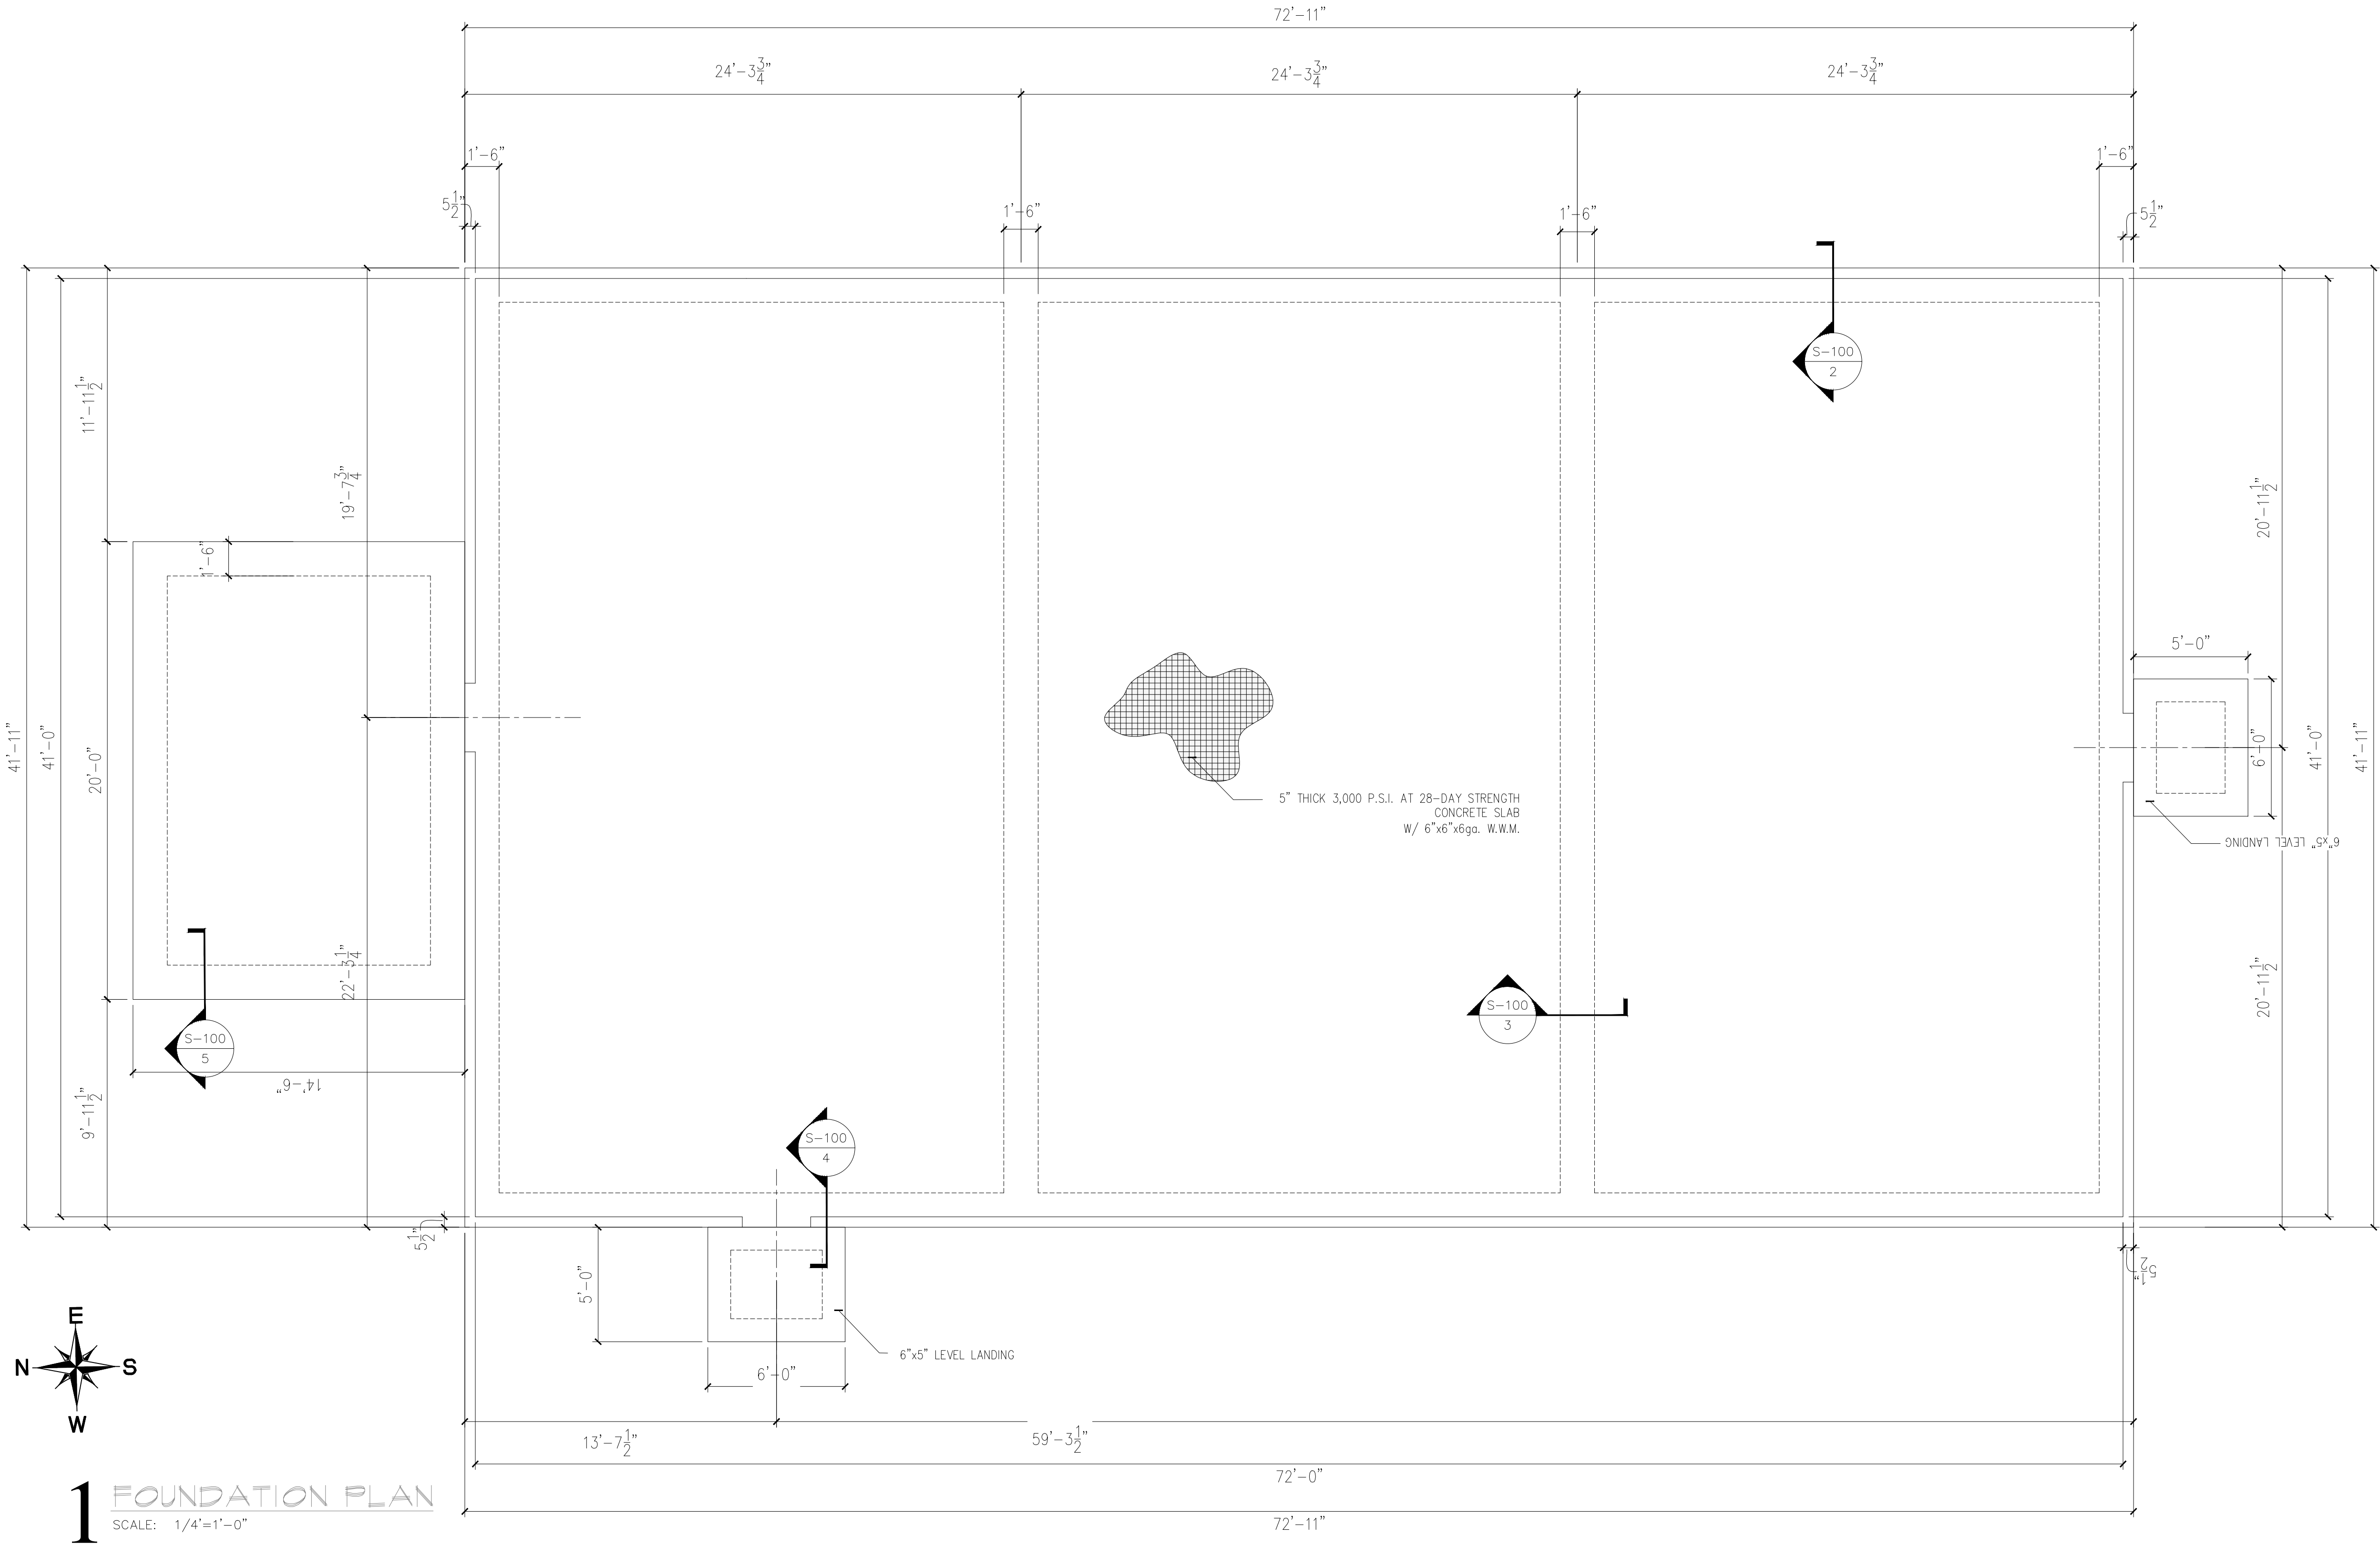


1 FOUNDATION PLAN
SCALE: 1/4"=1'-0"

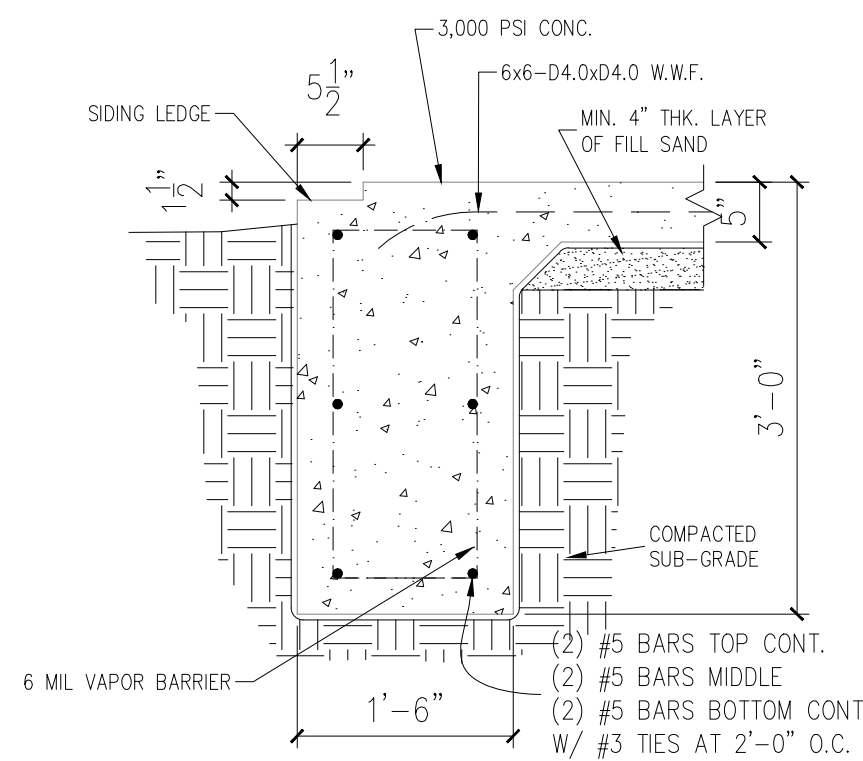


2 TYP. EXTERIOR FOOTING
SCALE: 3/4"=1'-0"

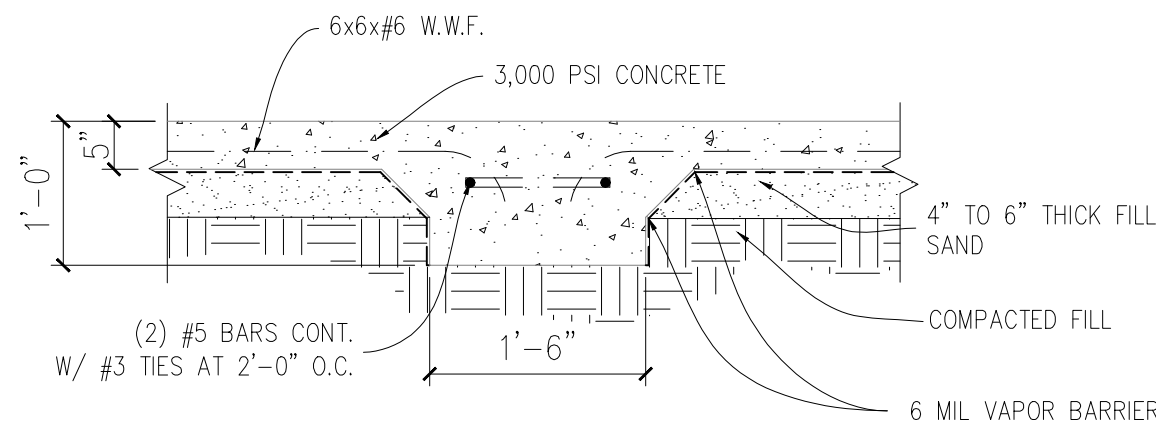

3 TYP. INTERIOR FOOTING
SCALE: 3/4"=1'-0"

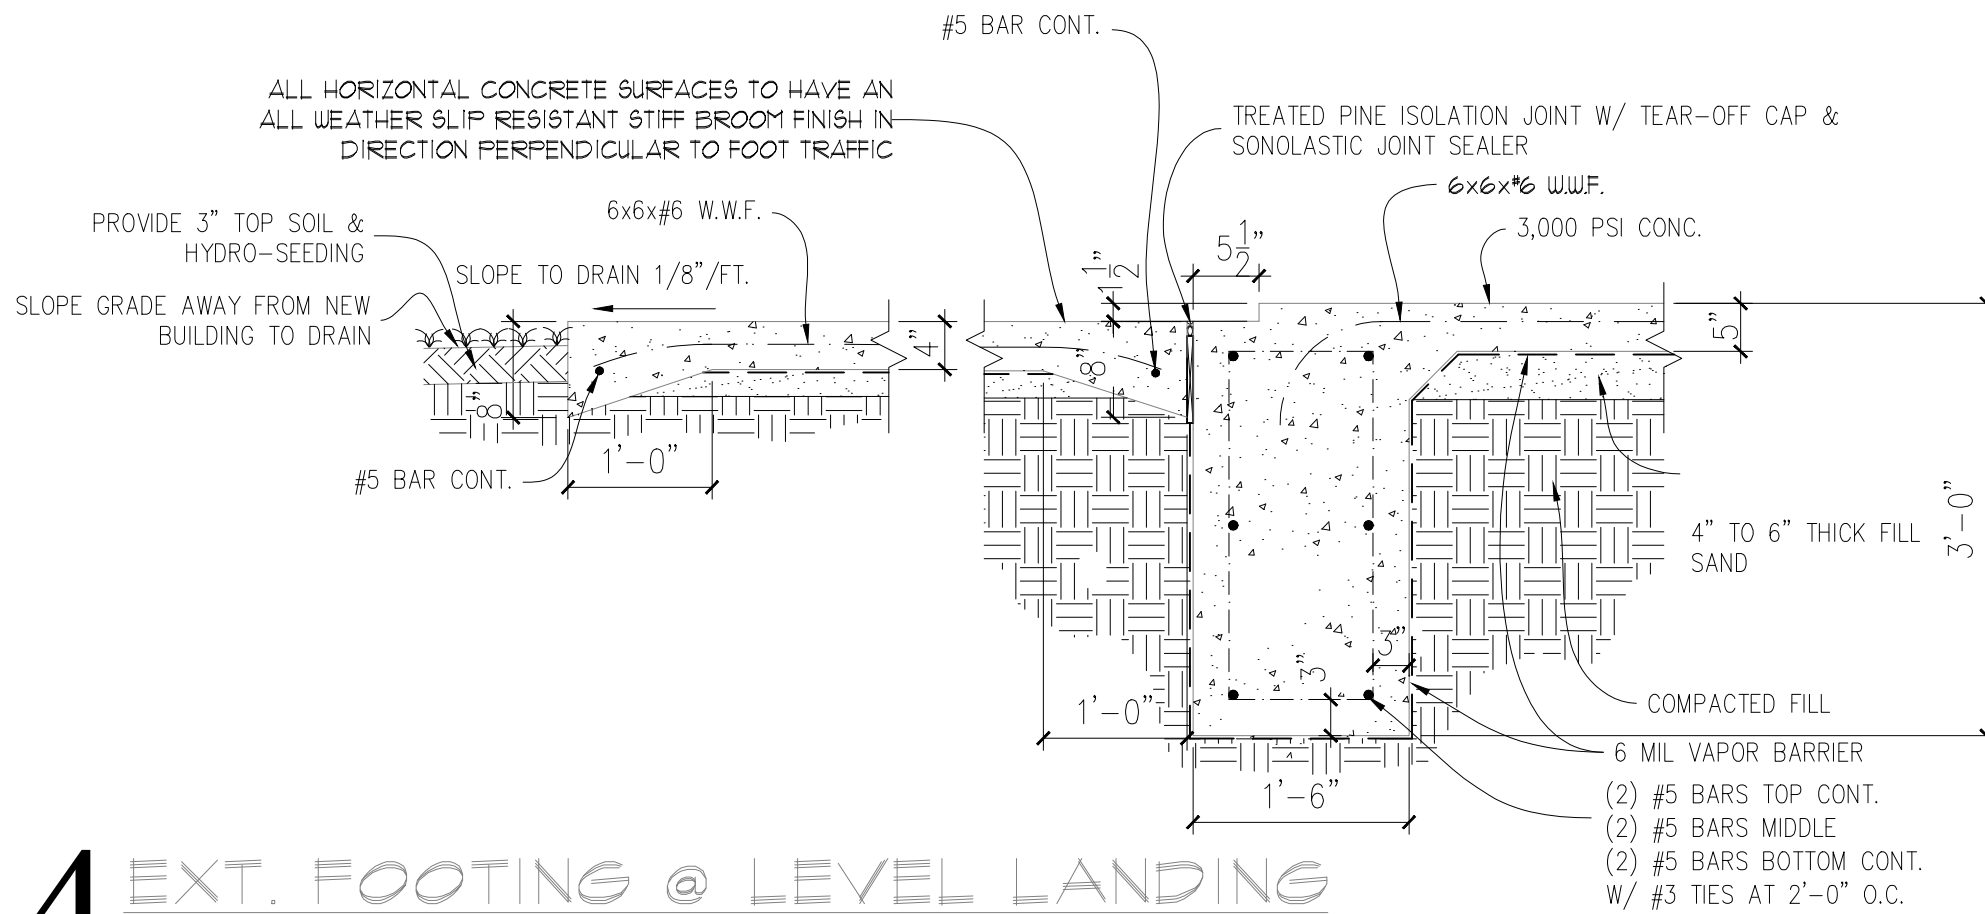

4 EXT. FOOTING @ LEVEL LANDING
SCALE: 3/4"=1'-0"

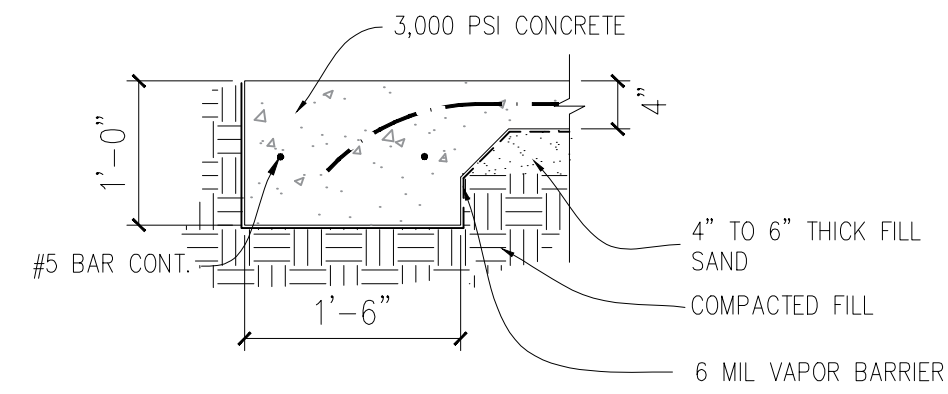

5 CANOPY FOOTING
SCALE: 3/4"=1'-0"

RAMP DETECTABLE WARNING (ACCEPTED ALT.):

1. THE ONLY ACCEPTABLE ALTERNATIVE TACTILE WARNING AT AREAS REQUIRED TO PROVIDE DETECTABLE WARNING SURFACES IS A SURFACE WITH A PROFILE OF MINIMUM 1/4" DEEP GROOVES THAT ARE SPACED 2" TO 3" ON CENTER AND SCORED INTO CONCRETE AT ALL LOCATIONS THAT DETECTABLE WARNING SURFACES ARE REQUIRED.
2. THE TINED SURFACE OF HANDICAP RAMP SHALL BE STAINED A CONTRASTING COLOR TO CONCRETE. CONTRASTING COLOR SHALL BE SELECTED BY ARCHITECT.
3. TINED FINISH SHALL EXTEND FOR THE FULL LENGTH AND WIDTH OF THE HANDICAP RAMP.

FOUNDATION NOTES:

1. A 6 MIL POLYETHYLENE VAPOR BARRIER SHALL BE INSTALLED, PRIOR TO PLACING REINFORCEMENT OR CONCRETE, AFTER APPROVAL OF PREPARED EARTHWORK.
2. CONCRETE SHALL HAVE A MINIMUM 28 DAY COMPRESSIVE STRENGTH OF 3000 PSI.
3. REINFORCING STEEL SHALL BE GRADE 60 DEFORMED BARS CONFORMING TO ASTM A-615.
4. WELDED WIRE MESH SHALL CONFORM TO ASTM A-185.
5. REINFORCING STEEL SHALL BE PLACED WITH ADEQUATE CHAIRS AND TIES PLACED TO PREVENT SAGGING AND TO HOLD THE BAR RIGID DURING CONCRETE PLACEMENT. MINIMUM LAP FOR BAR SPLICES SHALL BE 30 BAR DIAMETERS.
6. FINISHED CONCRETE SHALL BE PROTECTED AGAINST SURFACE MOISTURE BY USING AN APPROVED CURING COMPOUND APPLIED AS RECOMMENDED BY MANUFACTURER.
7. VEGETATION AND TOPSOIL SHALL BE REMOVED FROM AREA UNDER BUILDING TO DEPTH AS RECOMMENDED BY GEOTECHNICAL REPORT. AREA SHALL BE REMOVED, BACKFILLED AND COMPACTED TO 95% STANDARD PROCTOR DENSITY.
8. THE OWNER SHALL EMPLOY A LICENSED LAND SURVEYOR TO SET THE FINISHED FLOOR ELEVATION TO COMPLY WITH LOCAL, STATE AND FEDERAL "FLOOD PLAN" CRITERIA.
9. CONTRACTOR SHALL USE A 4" TO 6" THICKNESS OF DAMP "CUSHION" SAND TO AID IN LEVELING PRIOR TO PLACEMENT OF CONCRETE.

NOTES AT LEVEL LANDINGS:

1. THE TOP OF ALL EXTERIOR LANDINGS TO BE AT THE SAME ELEVATION AS THE FINISHED FLOOR ON BOTH SIDES (INTERIOR & EXTERIOR) OF THE DOORWAY.
2. THRESHOLDS SHALL NOT BE MORE THAN 1/2" IN HEIGHT AND BEVELED IF HIGHER THAN 1/4".
3. ALL EXTERIOR LANDINGS TO HAVE A SLIP-RESISTANT STIFF BROOM CONCRETE FINISH.
4. LANDINGS TO SLOPE @ 1/8" PER FOOT UNLESS NOTED OTHERWISE.

KING

architects
INC.

Barry D. King, AIA,

Architect

1312 Sampson St.

Westlake, LA 70669

337.494.0806

© COPYRIGHT 2026
ALL INFORMATION, EITHER DRAWN,
WRITTEN, OR IMPLIED APPEARING IN THIS
DOCUMENT SHALL NOT BE DUPLICATED,
DISCLOSED, OR OTHERWISE USED
WITHOUT THE WRITTEN PERMISSION OF
BARRY D. KING AIA. THIS DOCUMENT IS
AN INSTRUMENT OF SERVICE AND IS THE
SOLE PROPERTY OF THE AUTHOR.
FURTHERMORE, THE USE OF THIS
DOCUMENT FOR ANY PURPOSE SHALL BE
REVOKED, IF THE INTENT OF THE DESIGN
OR THE CONSTRUCTION TECHNIQUES OR
DETAILS SHOWN HEREIN ARE NOT
ADHERED TO OR THE CONTRACTUAL
AGREEMENT GOVERNING THEIR USE ARE
NOT STRICTLY ADHERED TO.


JOB NO: 2242

DATE: 7/7/26

DRWN. BY: C.J. NT

CHKD. BY: JC

REVISIONS

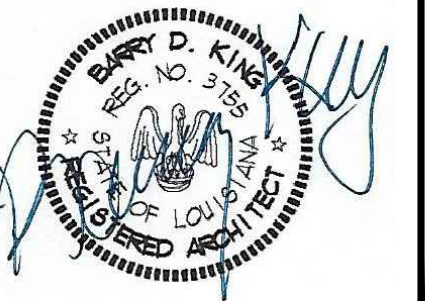

ETERNITY FULL GOSPEL
FELLOWSHIP HALL RE-BID
932 MULBERRY ST.
WESTLAKE, LA 70669
CALCASIEU PARISH


FOUNDATION
PLAN

S-100
SCALE: 1/4"=1'-0"

© COPYRIGHT 2026
ALL INFORMATION, EITHER DRAWN,
WRITTEN, OR IMPLIED APPEARING IN THIS
DOCUMENT SHALL NOT BE DUPLICATED,
DISCLOSED, OR OTHERWISE USED
WITHOUT THE WRITTEN PERMISSION OF
HARRY D. KING KIA. THIS DOCUMENT IS
AN INSTRUMENT OF SERVICE AND IS THE
SOLE PROPERTY OF THE AUTHOR.
FURTHERMORE, THE USE OF THIS
DOCUMENT FOR ANY PURPOSE SHALL BE
REVOKED, IF THE INTENT OF THE DESIGN
OR THE CONSTRUCTION TECHNIQUES OR
DETAILS SHOWN HEREIN ARE NOT
ADHERED TO OR THE CONTRACTUAL
AGREEMENT GOVERNING THEIR USE IS
NOT STRICTLY ADHERED TO.

JOB NO: 2242
DATE: 7/7/26
DRWN. BY: CJ, NT
CHKD. BY: JC


REVISIONS

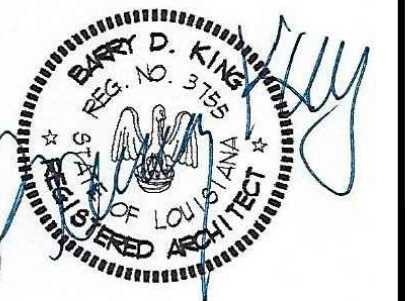


ETERNITY FULL GOSPEL
FELLOWSHIP HALL RE-BID
932 MULBERRY ST.
WESTLAKE, LA 70669
CALCASIEU PARISH

SITE PLAN

SCALE: 1" = 30'-0"

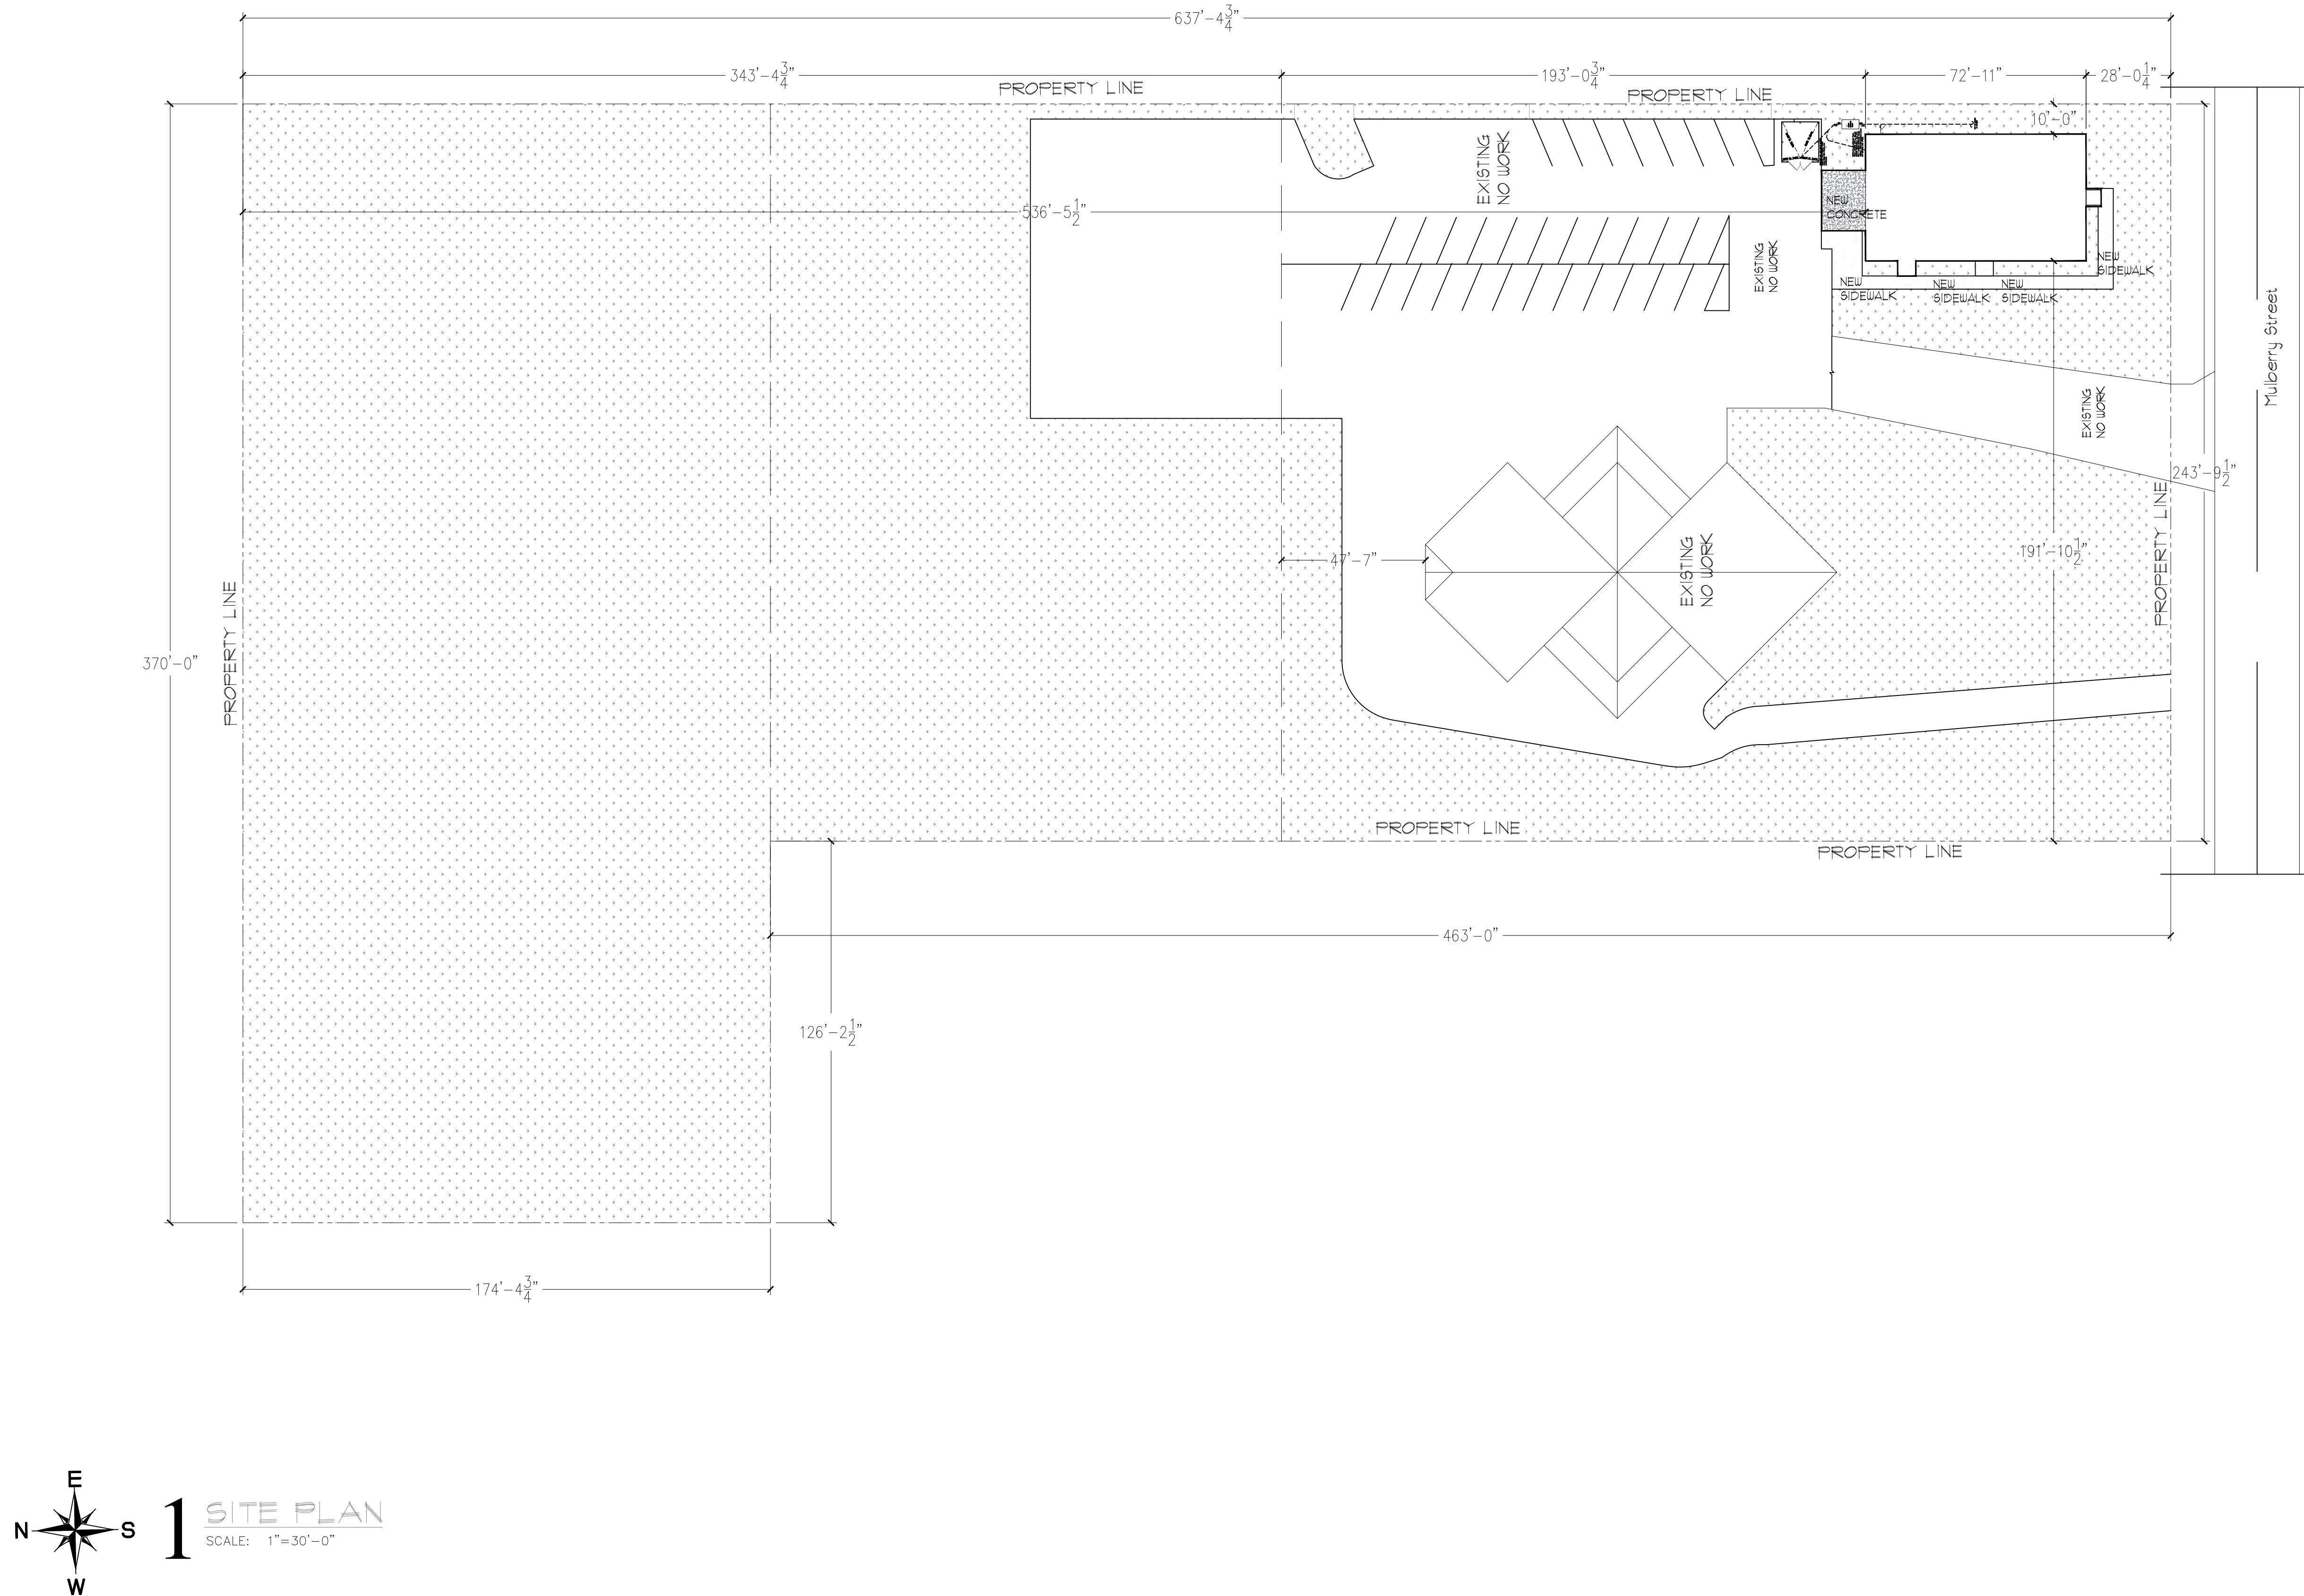

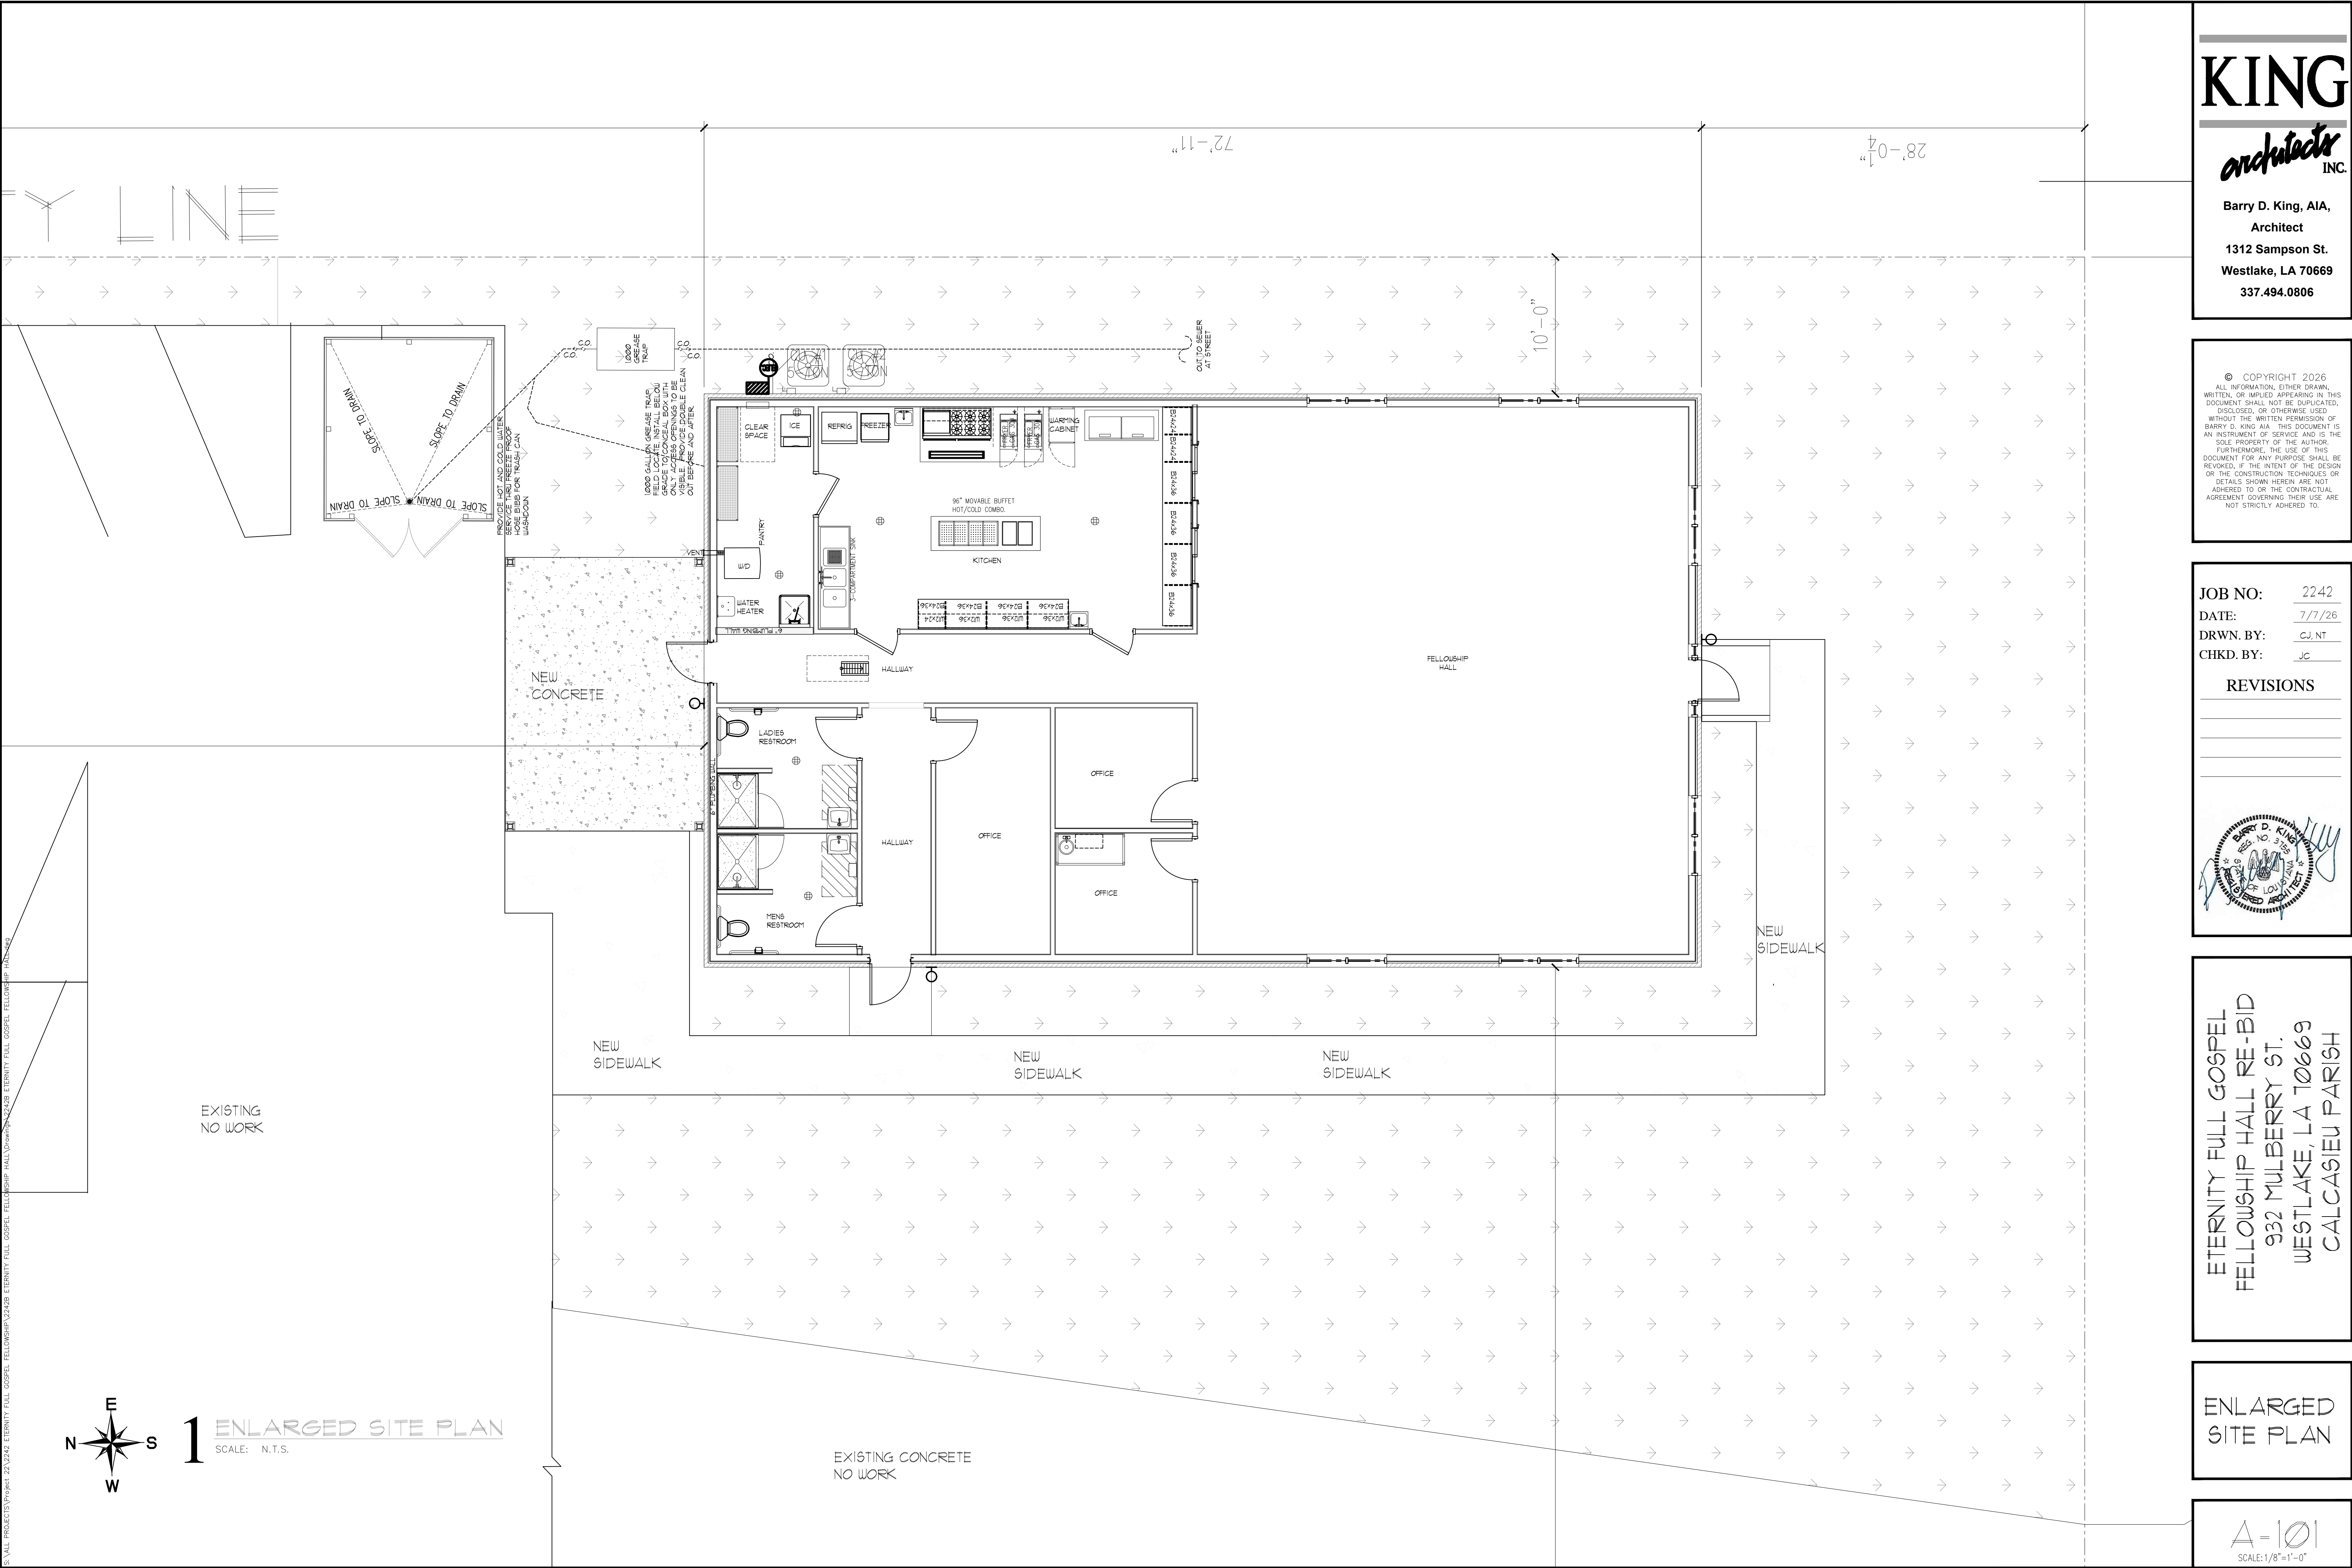


KING
architects INC.

Barry D. King, AIA,
Architect
1312 Sampson St.
Westlake, LA 70669
337.494.0806

© COPYRIGHT 2026
ALL INFORMATION, EITHER DRAWN,
WRITTEN, OR IMPLIED APPEARING IN THIS
DOCUMENT SHALL NOT BE DUPLICATED,
DISCLOSED, OR OTHERWISE USED
WITHOUT THE WRITTEN PERMISSION OF
BARRY D. KING AIA. THIS DOCUMENT IS
AN INSTRUMENT OF SERVICE AND IS THE
SOLE PROPERTY OF THE AUTHOR.
FURTHERMORE, THE USE OF THIS
DOCUMENT FOR ANY PURPOSE SHALL BE
REVOKED, IF THE INTENT OF THE DESIGN
OR THE CONSTRUCTION TECHNIQUES OR
DETAILS SHOWN HEREIN ARE NOT
ADHERED TO, OR THE CONTRACTUAL
AGREEMENT GOVERNING THEIR USE ARE
NOT STRICTLY ADHERED TO.

JOB NO: 2242
DATE: 7/7/26
DRWN. BY: C.J. NT
CHKD. BY: JC

REVISIONS

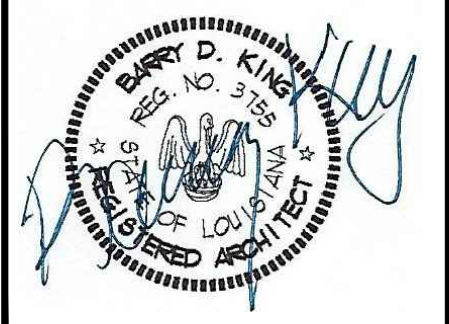

ETERNITY FULL GOSPEL
FELLOWSHIP HALL RE-BID
932 MULBERRY ST.
WESTLAKE, LA 70669
CALCASIEU PARISH


ENLARGED
SITE PLAN

$\Delta = 101$
SCALE: 1/8" = 1'-0"

JOB NO: 2242
DATE: 7/7/26
DRWN. BY: CJ, NT
CHKD. BY: JC



$\Delta = 2 \bigcirc \bigcirc$
SCALE: 1/4" = 1'-0"

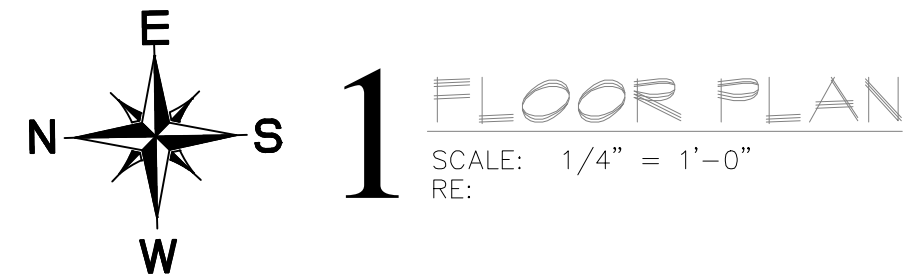

DOOR SCHEDULE

3 WINDOW SCHEDULE

ROOM FINISH SCHEDULE

1. WALK-IN COOLER FACES TO HAVE DIRECT APPLIED 5/8" THICK GYPSUM BOARD, ALIGN RUN DOWN ABOVE TO FLUSH. CONTRACTOR TO VERIFY FINISH MATERIALS WITH OWNER PRIOR TO ORDERING.
2. CONFIRM LOCATION OF GASOLINE EQUIPMENT LINES TO AVOID CONFLICTS.
3. BEVERAGE LINES TO FOUNTAIN DRINK DISPENSER TO BE RUN THROUGH WALLS OR ABOVE CEILING (OPTIONAL).
4. CONTRACTOR TO COORDINATE PLAN WITH METAL BUILDING MANUFACTURER SHOP DRAWINGS FOR ALL STRUCTURAL STEEL LOCATIONS.
5. OWNER TO PROVIDE FUEL PUMPS, CANOPIES, ELECTRICAL, ETC.; CONTRACTOR TO COORDINATE WORK.
6. PROVIDE SOLID BLOCKING FOR ALL WALL MOUNTED SHELVES, TIME CLOCK, SOAP & TOWEL DISPENSERS, GRAB BARS, WATER FILTER AND ALL OTHER WALL MOUNTED EQUIPMENT.
7. OWNER TO PROVIDE/INSTALL ALL SHELVING, RACKS, DISPLAYS, ETC.
8. ALL WALLS FRAMED CONTINUOUS IN HEIGHT ABOVE 12'-0" TO BE 2x6 STUDS.
9. PROVIDE FIRE BLOCKING AT ALL WALLS TO NO MORE THAN 5'-0" APART EACH WAY.
10. TOXIC CHEMICAL STORAGE IN JANITOR CLOSET.
11. PROVIDE PORTABLE FIRE EXTINGUISHERS IN ACCORDANCE WITH NFPA 10. (1 EXTINGUISHER PER 2000 SQ FT).
12. PROVIDE SELF-CLOSING MECHANISMS AT EXTERIOR AND RESTROOM DOORS.

KING


architects
INC.

Barry D. King, AIA,
Architect
1312 Sampson St.
Westlake, LA 70669
337.494.0806

© COPYRIGHT 2026
ALL INFORMATION, EITHER DRAWN,
WRITTEN, OR IMPLIED APPEARING IN THIS
DOCUMENT SHALL NOT BE DUPLICATED,
DISCLOSED, OR OTHERWISE USED
WITHOUT THE WRITTEN PERMISSION OF
BARRY D. KING AIA. THIS DOCUMENT IS
AN INSTRUMENT OF SERVICE AND IS THE
SOLE PROPERTY OF THE AUTHOR.
FURTHERMORE, THE USE OF THIS
DOCUMENT FOR ANY PURPOSE SHALL BE
REVOKED, IF THE INTENT OF THE DESIGN
OR THE CONSTRUCTION TECHNIQUES OR
DETAILS SHOWN HEREIN ARE NOT
ADHERED TO OR THE CONTRACTUAL
AGREEMENT GOVERNING THEIR USE ARE
NOT STRICTLY ADHERED TO.

JOB NO: 2242
DATE: 7/7/26
DRWN. BY: C.J. NT
CHKD. BY: JC


REVISIONS

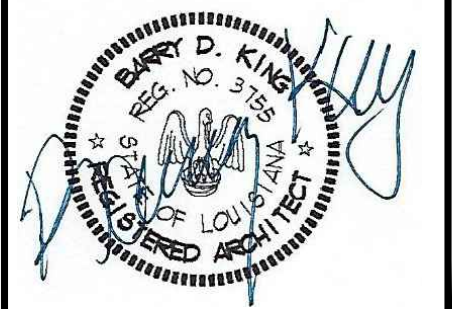


ETERNITY FULL GOSPEL
FELLOWSHIP HALL RE-BID
932 MULBERRY ST.
WESTLAKE, LA 70669
CALCASIEU PARISH

EXTERIOR
ELEVATIONS

A-300
SCALE: 1/4"=1'-0"

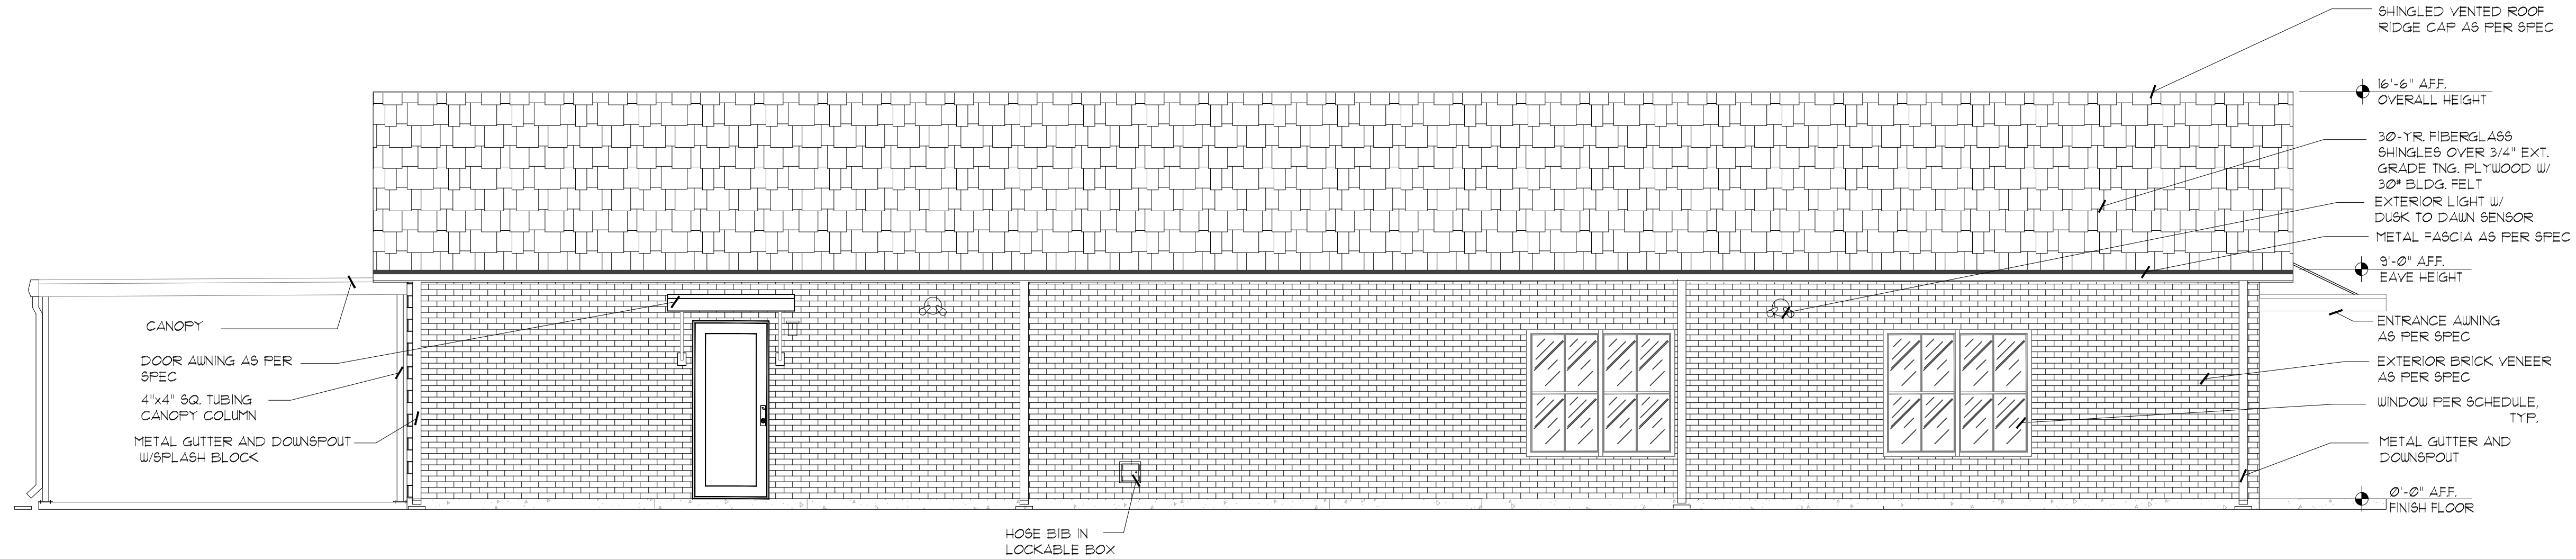

1 WEST ELEVATION
SCALE: 1/4"=1'-0"

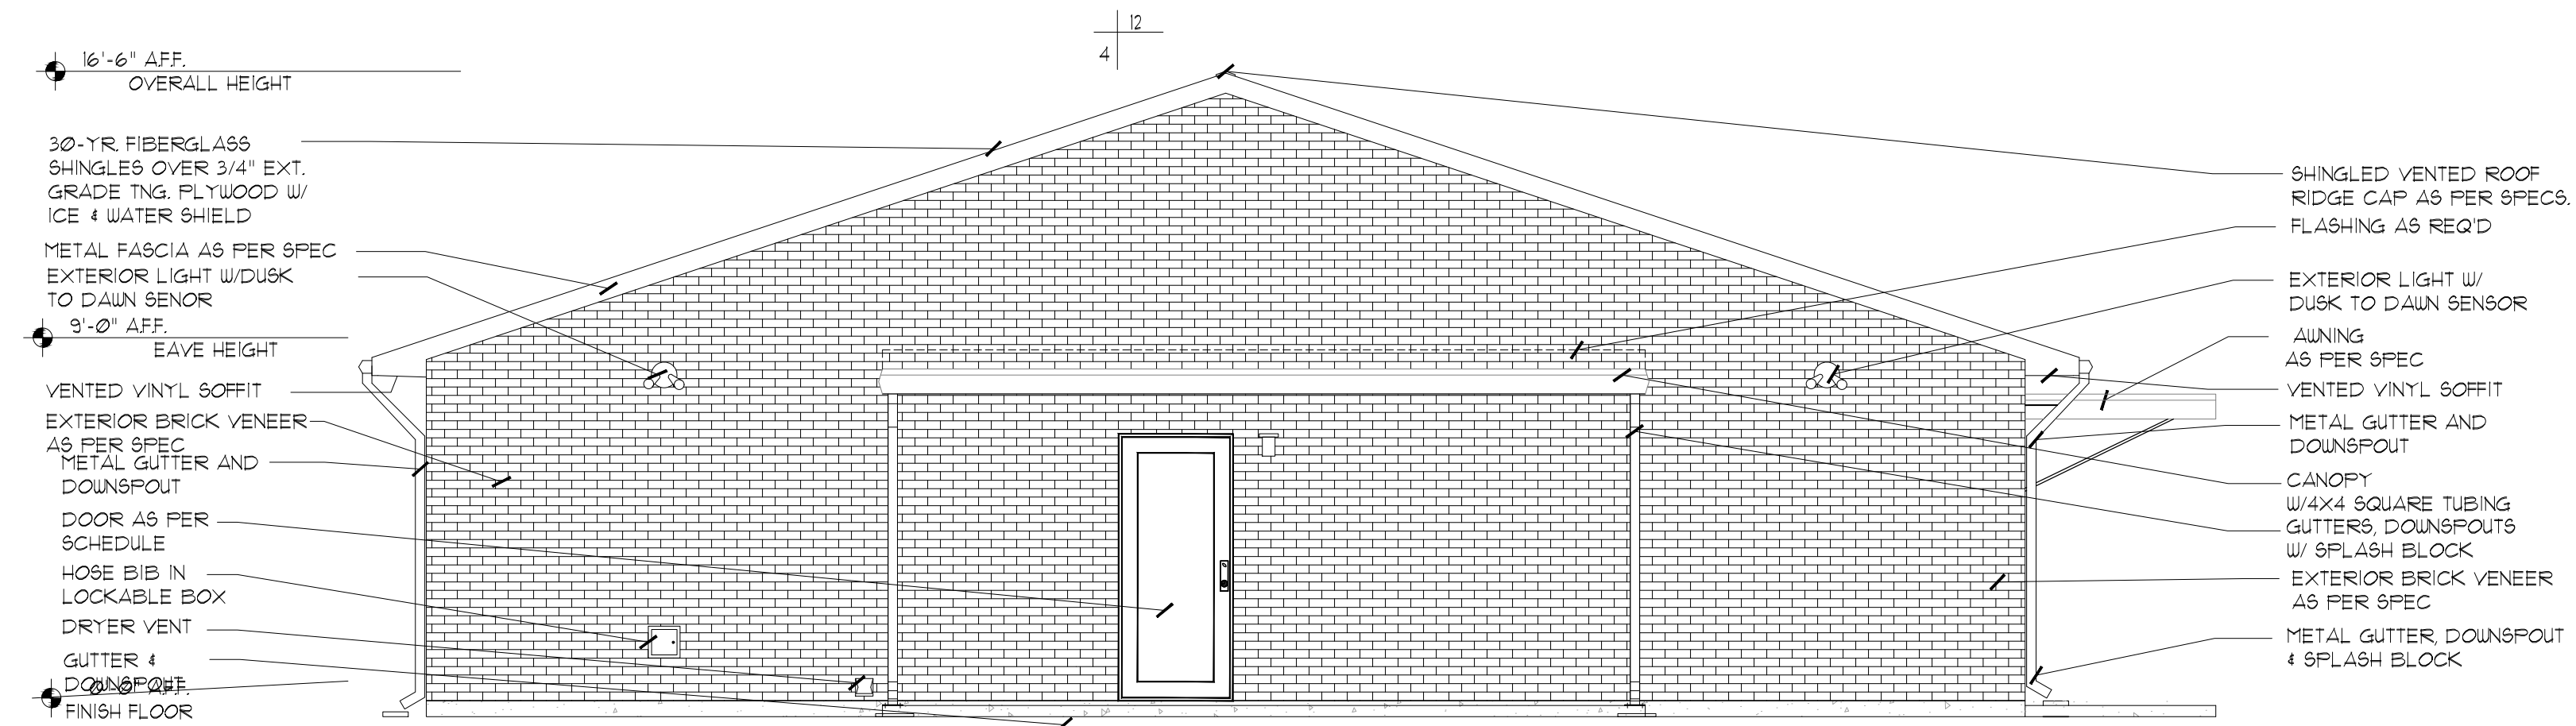

2 NORTH ELEVATION
SCALE: 1/4"=1'-0"

KING

architects
INC.


Barry D. King, AIA,
Architect

1312 Sampson St.
Westlake, LA 70669
337.494.0806

© COPYRIGHT 2026
ALL INFORMATION, EITHER DRAWN,
WRITTEN, OR IMPLIED APPEARING IN THIS
DOCUMENT SHALL NOT BE DUPLICATED,
DISCLOSED, OR OTHERWISE USED
WITHOUT THE WRITTEN PERMISSION OF
BARRY D. KING AIA. THIS DOCUMENT IS
AN INSTRUMENT OF SERVICE AND IS THE
SOLE PROPERTY OF THE AUTHOR.
FURTHERMORE, THE USE OF THIS
DOCUMENT FOR ANY PURPOSE SHALL BE
REVOKED, IF THE INTENT OF THE DESIGN
OR THE CONSTRUCTION TECHNIQUES OR
DETAILS SHOWN HEREIN ARE NOT
ADHERED TO OR THE CONTRACTUAL
AGREEMENT GOVERNING THEIR USE ARE
NOT STRICTLY ADHERED TO.

JOB NO: 2242
DATE: 7/7/26
DRWN. BY: C.J. NT
CHKD. BY: JC


REVISIONS

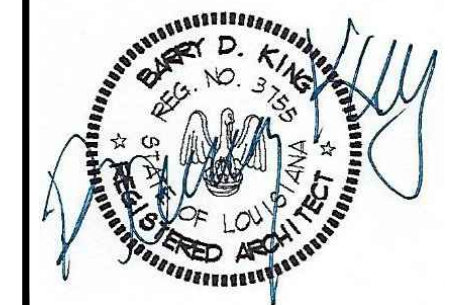


ETERNITY FULL GOSPEL
FELLOWSHIP HALL RE-BID
932 MULBERRY ST.
WESTLAKE, LA 70669
CALCASIEU PARISH

EXTERIOR
ELEVATIONS

A-301
SCALE: 1/4"=1'-0"

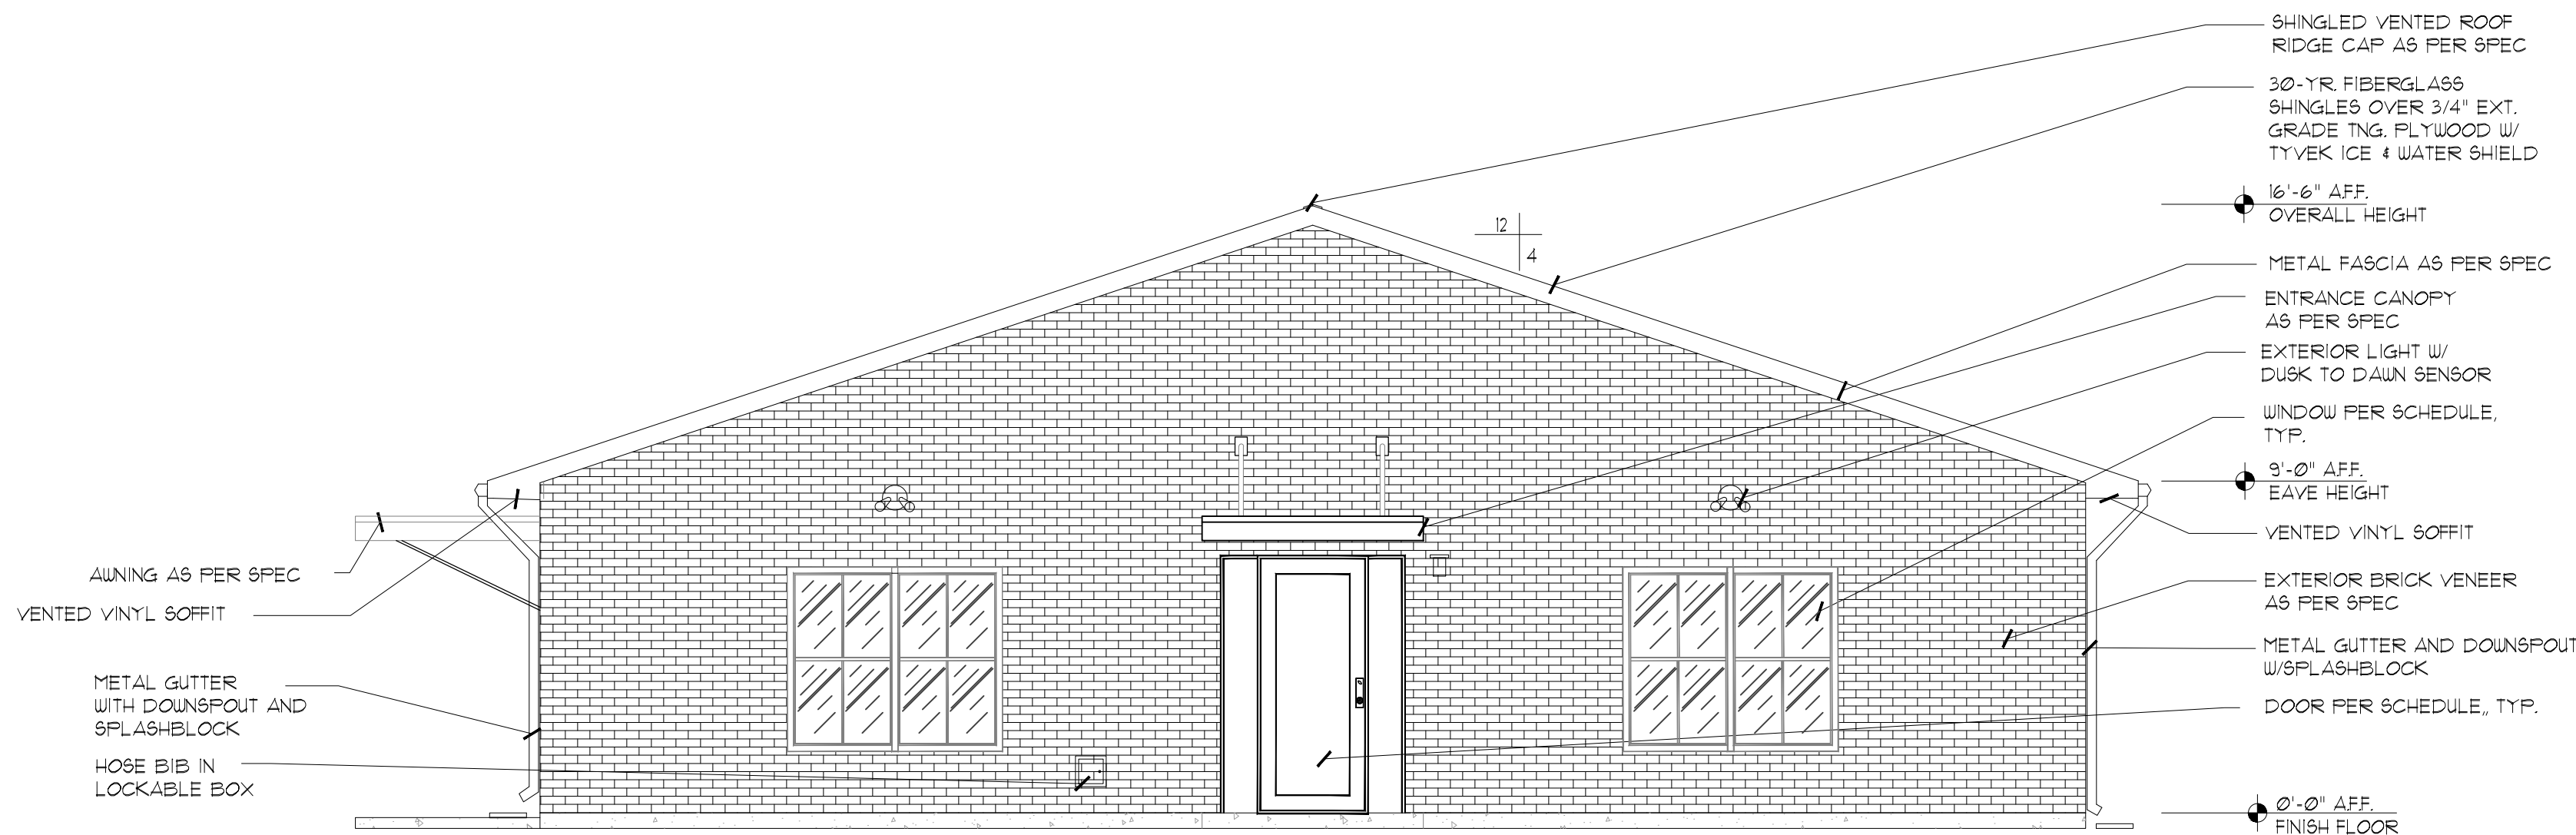


3 SOUTH ELEVATION
SCALE: 1/4"=1'-0"

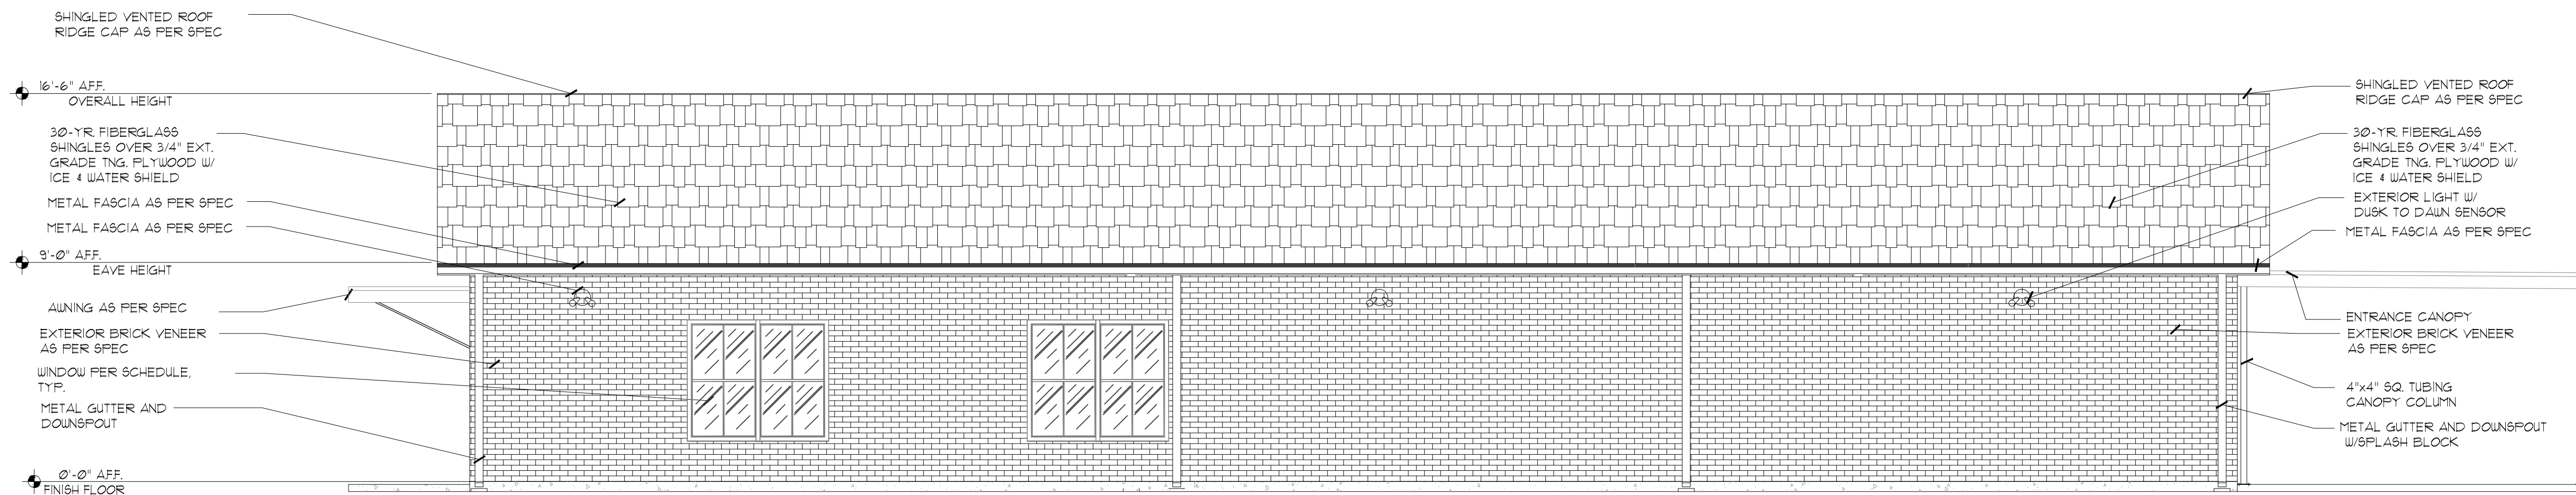


4 EAST ELEVATION
SCALE: 1/4"=1'-0"

S:\ALL PROJECTS\Project 22\2242 ETERNITY FULL GOSPEL FELLOWSHIP\2242B ETERNITY FULL GOSPEL FELLOWSHIP HALL.dwg


1 TYP. VENT HOOD DETAILS

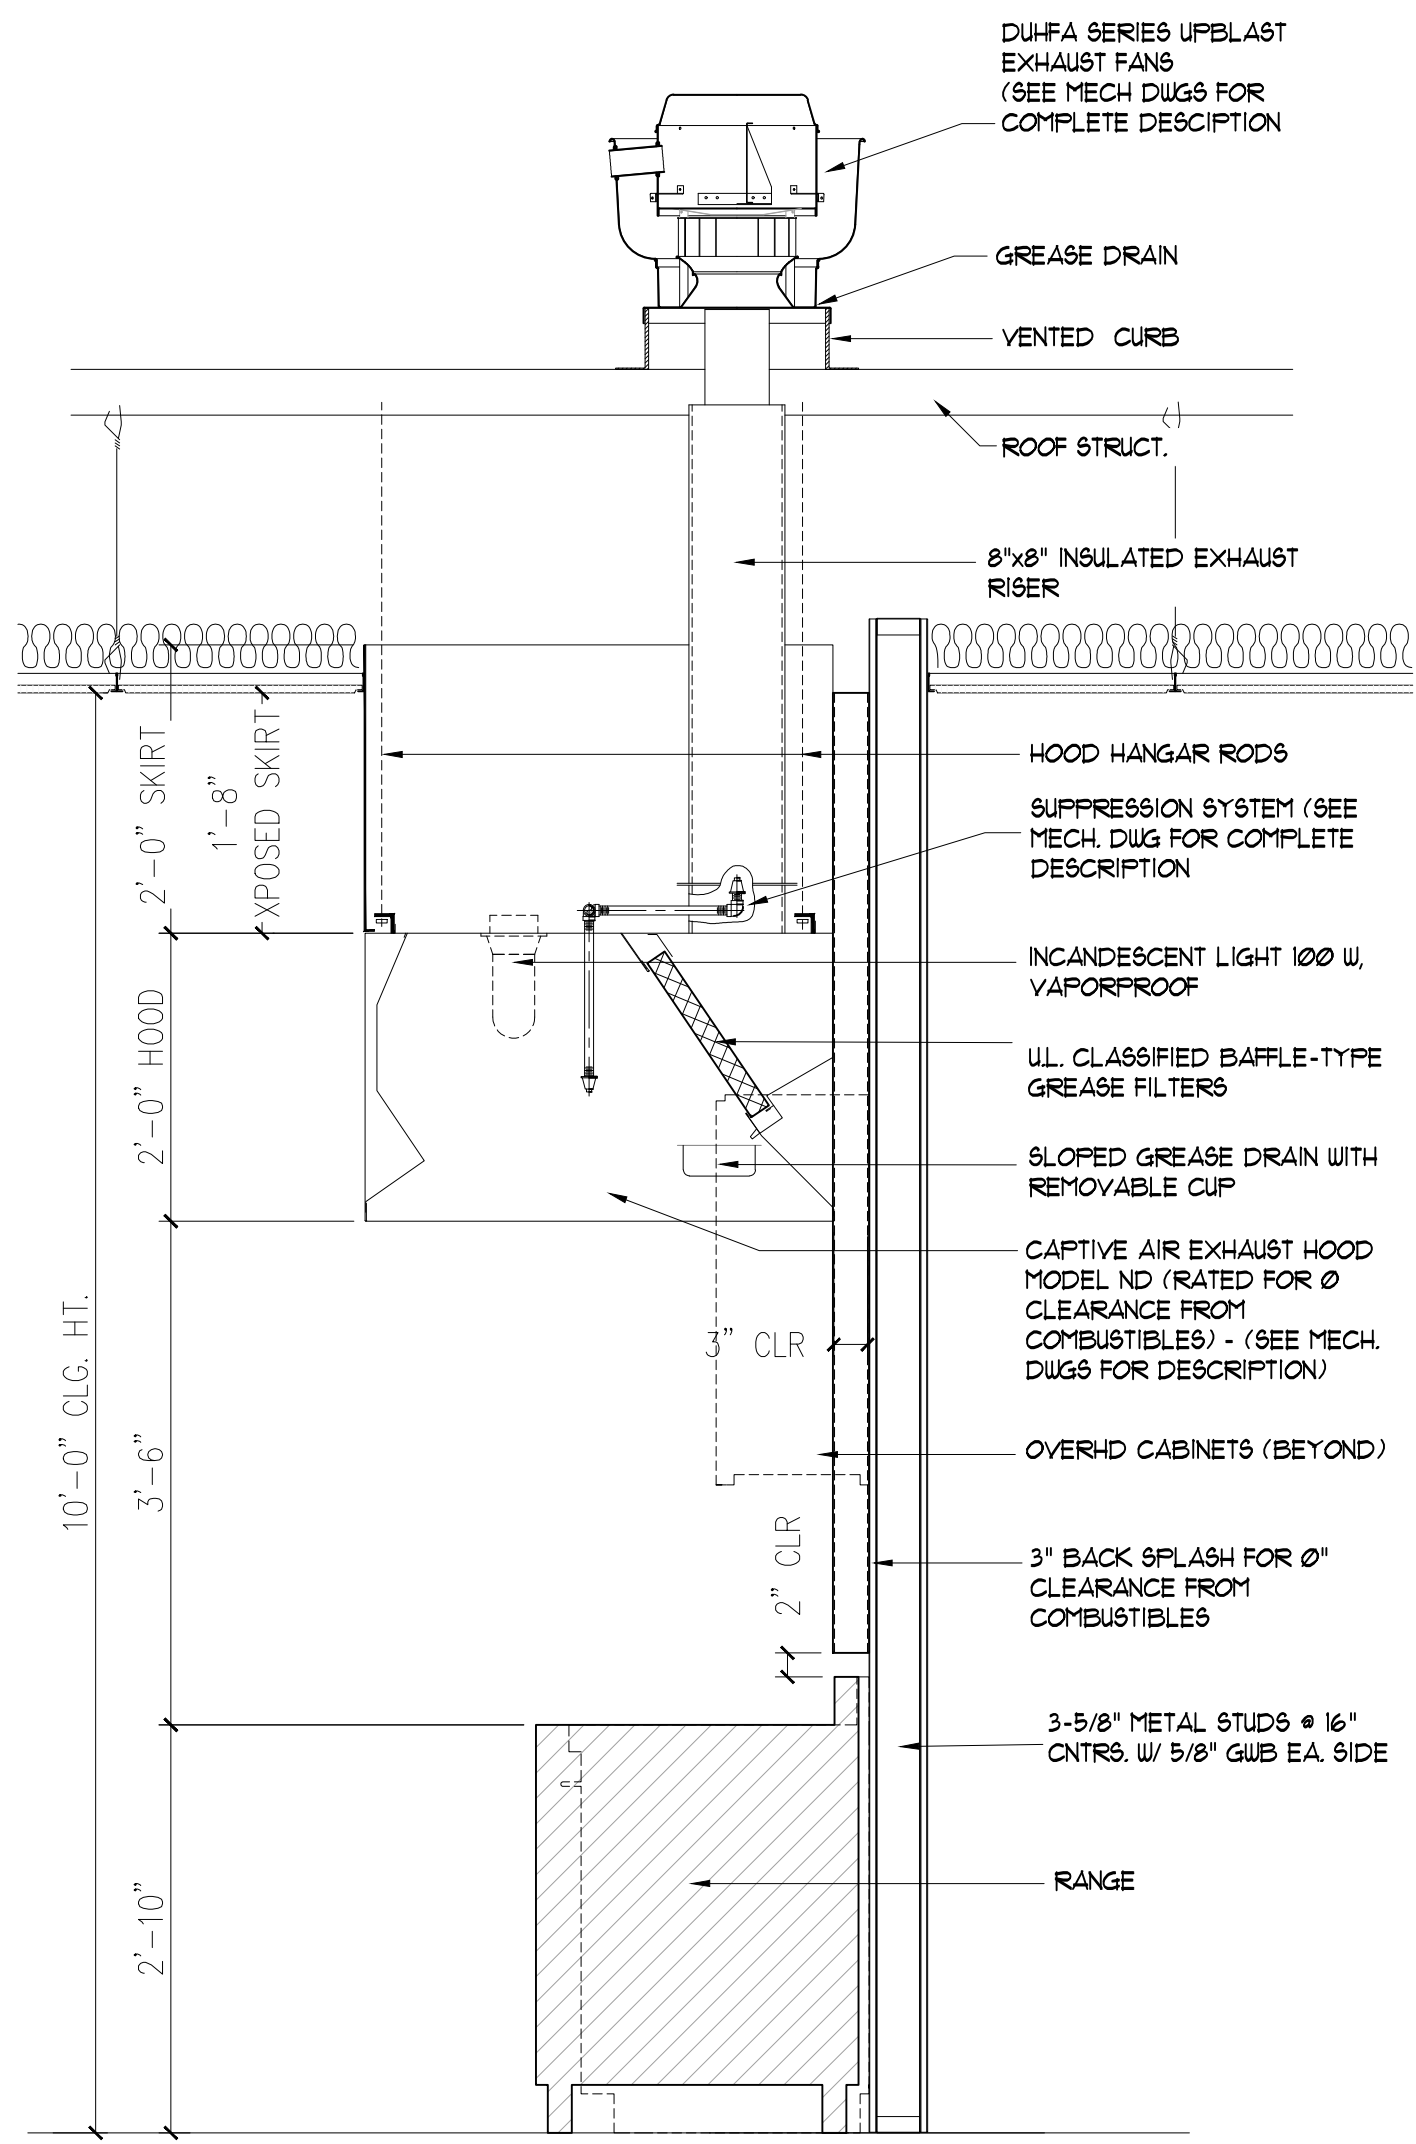


2 CANOPY PLAN

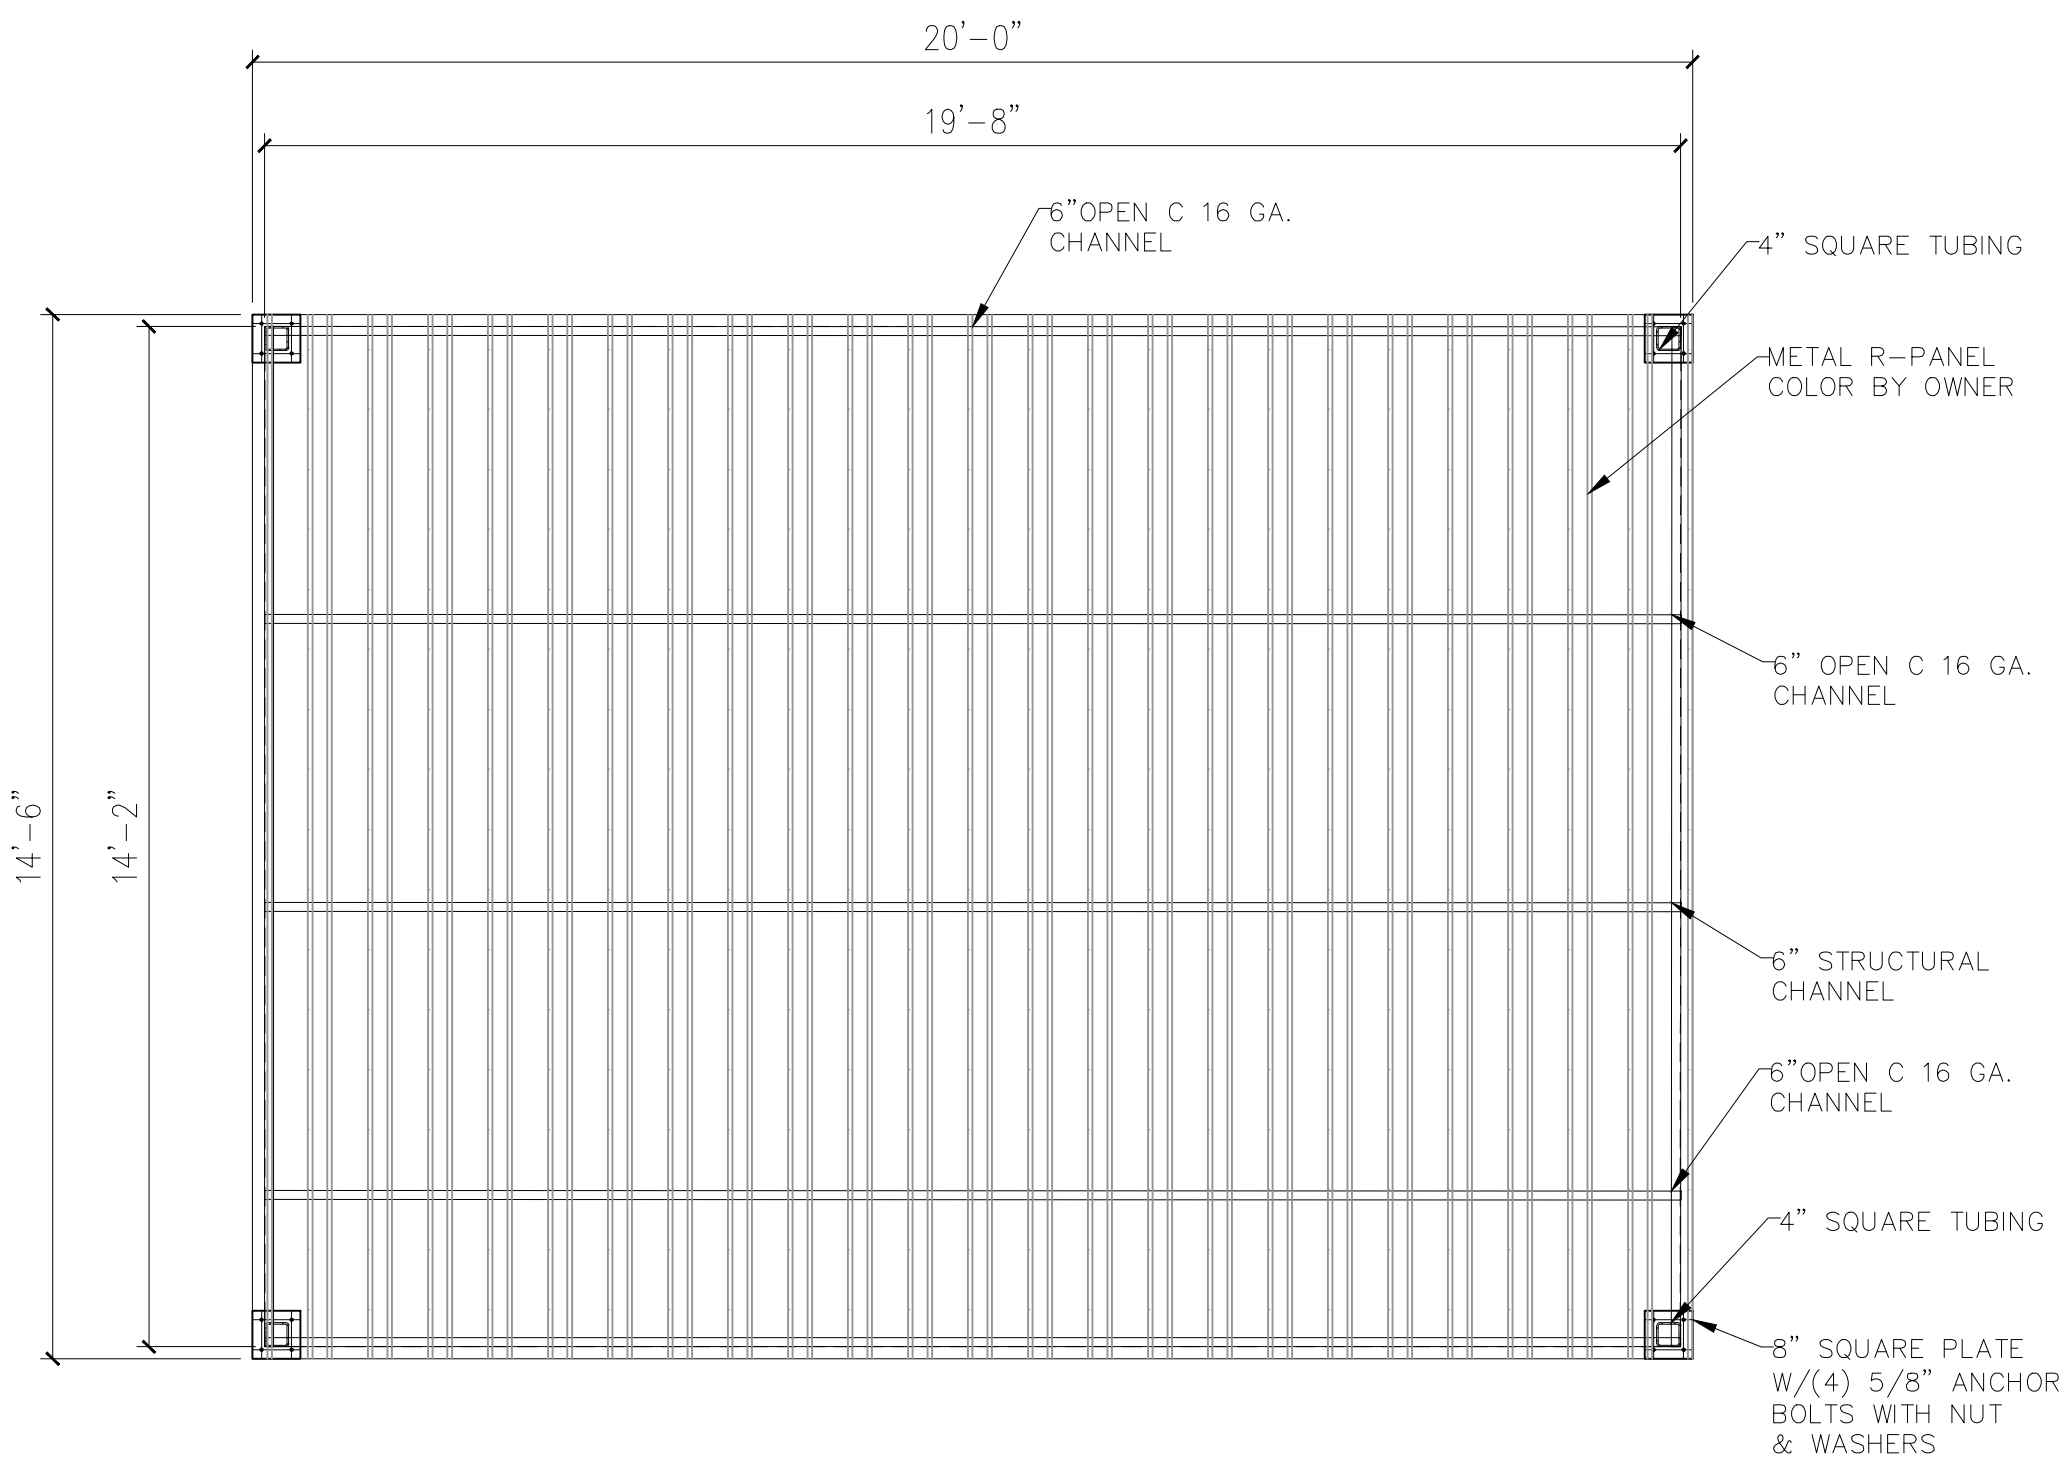

3 CANOPY DETAILS

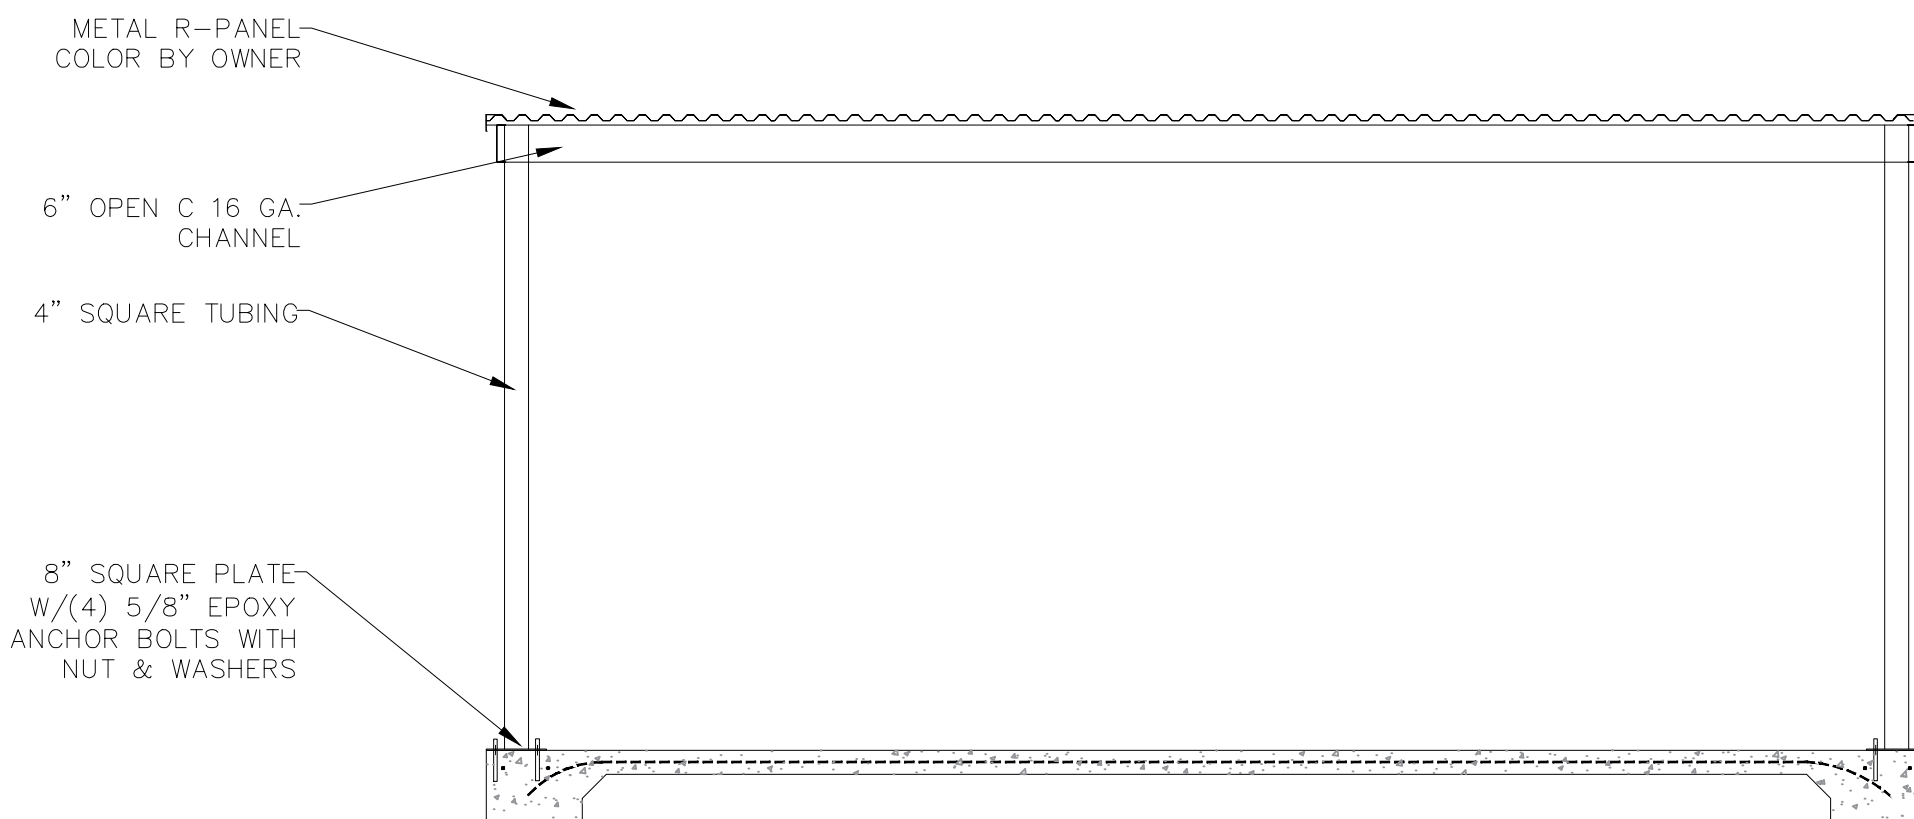

4 CANOPY BASE PLATE

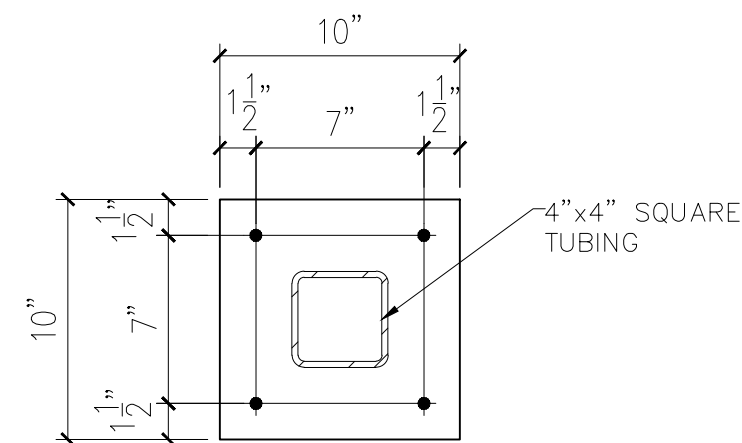

KING
architects INC.

Barry D. King, AIA,
Architect
1312 Sampson St.
Westlake, LA 70669
337.494.0806

© COPYRIGHT 2026
ALL INFORMATION, EITHER DRAWN, WRITTEN, OR IMPLIED APPEARING IN THIS DOCUMENT SHALL NOT BE DUPLICATED, DISCLOSED, OR OTHERWISE USED WITHOUT THE WRITTEN PERMISSION OF BARRY D. KING AIA. THIS DOCUMENT IS AN INSTRUMENT OF SERVICE AND IS THE SOLE PROPERTY OF THE AUTHOR. FURTHERMORE, THE USE OF THIS DOCUMENT FOR ANY PURPOSE SHALL BE REVOKED, IF THE INTENT OF THE DESIGN OR THE CONSTRUCTION TECHNIQUES OR DETAILS SHOWN HEREIN ARE NOT ADHERED TO OR THE CONTRACTUAL AGREEMENT GOVERNING THEIR USE ARE NOT STRICTLY ADHERED TO.

JOB NO: 2242
DATE: 7/7/26
DRWN. BY: C.J. NT
CHKD. BY: JC



REVISIONS



ETERNITY FULL GOSPEL
FELLOWSHIP HALL RE-BID
932 MULBERRY ST.
WESTLAKE, LA 70669
CALCASIEU PARISH

VENT
HOOD
& CANOPY
DETAILS

A-401
SCALE: 3/4"=1'-0"

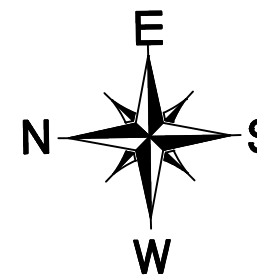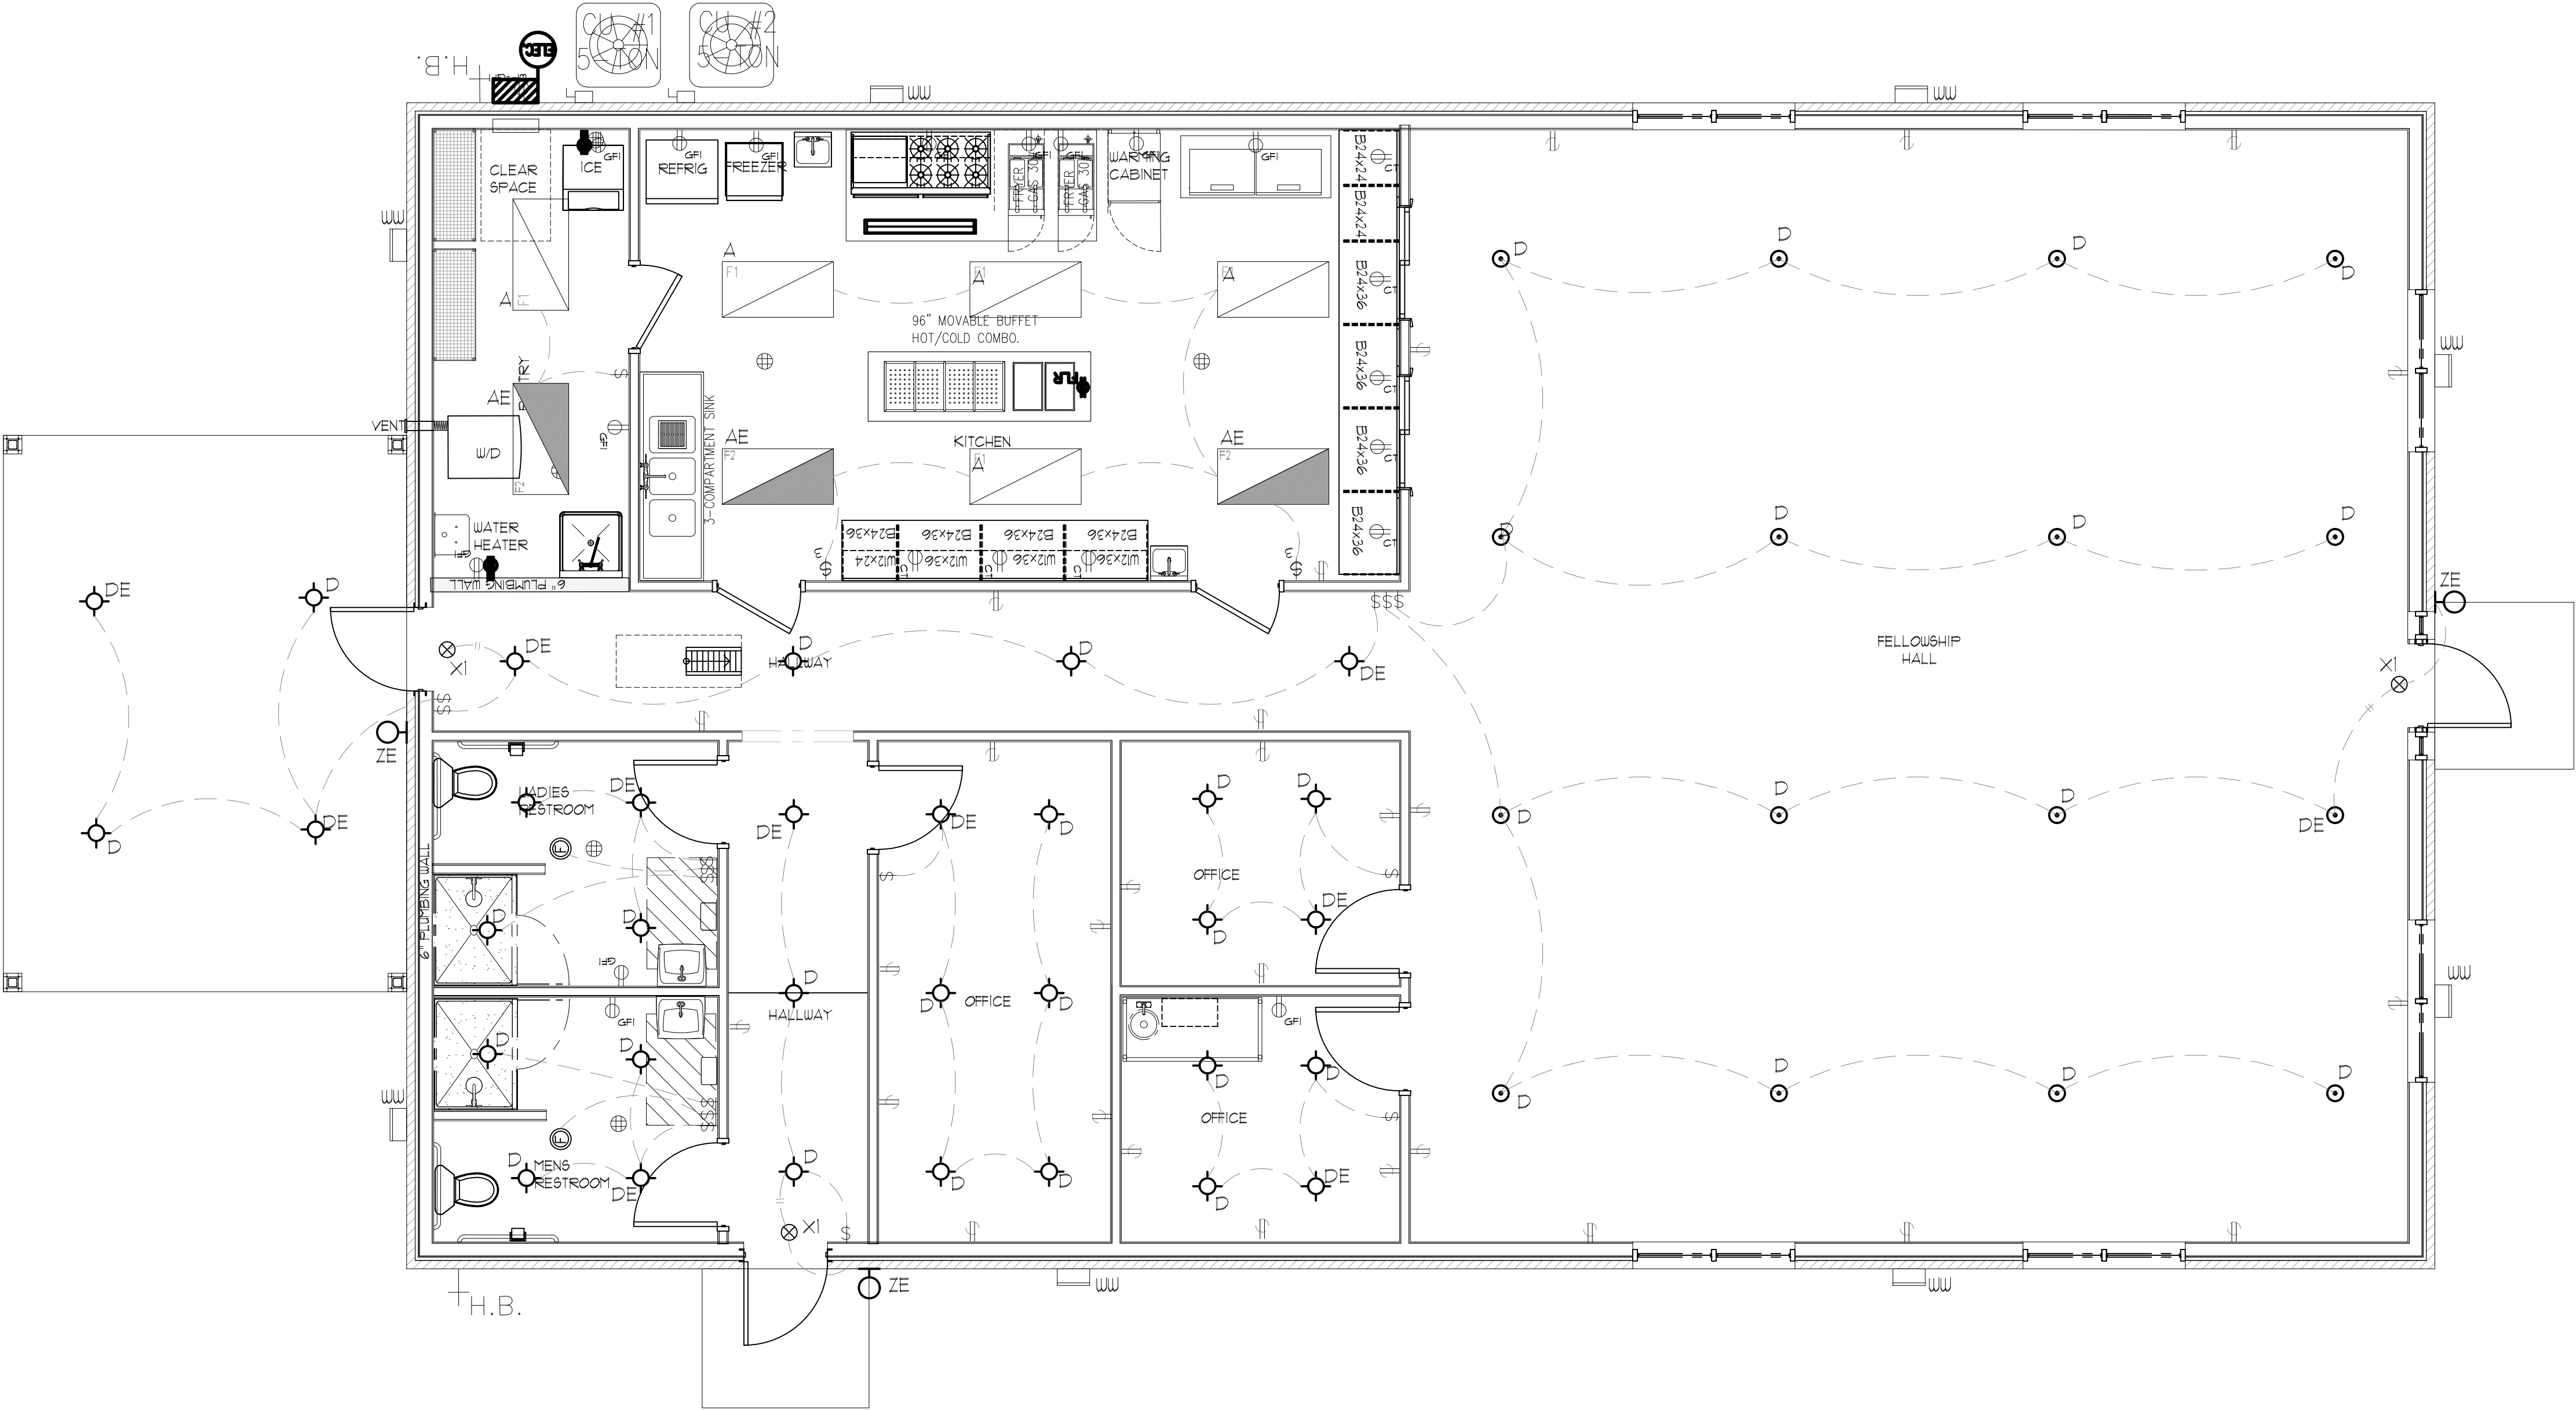

1 ELECTRICAL PLAN

SCALE: 1/4"=1'-0"

LIGHTING FIXTURE SCHEDULE

MARK	DESCRIPTION	LUMENS	VOLTS	MOUNTING	CATALOG NO#	WATTS
D	LED DOWN LIGHTS	1573	MVOLTS	RECESSED	LITHONIA LDN6 35/15 L06AR LS MVOLT EZ10	17.52
DE	LED DOWN LIGHTS W/BATTERY PACK	1573	MVOLTS	RECESSED	LITHONIA LDN6 35/15 L06AR LS MVOLT EZ10 EZ10	17.52
WP	EXTERIOR WALL PACK	2996	MVOLTS	SURFACE	LITHONIA TWX1 LED P2 40K	22.46
WW	LED WALL WASHER	1573	MVOLTS	RECESSED	LITHONIA LDN6 35/15 LW6AR LS MVOLT EZ 10	17.52
X1	SINGLE FACE EXIT SIGN LIGHT	LED	120/277	UNIVERSAL	LITHONIA LOC 1REL N	-
X2	DOUBLE FACE EXIT SIGN LIGHT	LED	120/277	UNIVERSAL	LITHONIA LOC 2REL N	-
ZE	EXTERIOR WALL SCONCE W/BATTERY PACK	1500	MVOLT	SURFACE	LITHONIA, ARC1 LED P1 40K E4WH	11
A	2X4 FLAT PANEL	5983	MVOLT	RECESSED	LITHONIA, CPX 2X4 6000ML 80CRI, 35K SWL MIN 10 ZT MVOLT	41.8
AE	2X4 FLAT PANEL W/BATTERY PACK	5983	MVOLT	RECESSED	LITHONIA, CPX 2X4 6000ML 80CRI, 35K SWL MIN 10 ZT MVOLT, E10WLCF	41.8

NOTE: ALL PIPE CONNECTION SIZES ARE BASED ON TYPICAL SIZE REQUIREMENTS. ALL SIZES ARE SUBJECT TO CHANGE DUE TO OWNER'S SPECS.

LOW VOLTAGE WIRING (ALSO KNOWN AS PHONE/DATA CABLING):

- LOW VOLTAGE IMPLIES THE ACTUAL WIRE OR CABLE THAT IS RUN TO EACH PHONE, COMPUTER, PRINTER, AND FUTURE WORKSTATION LOCATION. LOW VOLTAGE WORK IS DONE BY TENANT THROUGH A PREFERRED NATIONAL VENDOR. THIS WORK IS DONE AFTER THE SPACE IS TURNED OVER TO TENANT.
- IF LOW VOLTAGE WORK IS REQUIRED TO BE PERMITTED AND INSPECTED PRIOR TO CLOSING ANY NEW PARTITIONS, GENERAL CONTRACTOR IS TO COORDINATE THE INSTALLATION WITH TENANT'S PREFERRED NATIONAL VENDOR. NOTE THAT PRE-WIRE IS NOT STANDARD AND IS ONLY DONE WHEN REQUIRED VS. BEING DONE FOR CONVENIENCE.

ELECTRICAL NOTES:

- PROVIDE INSERTS, HANGARS, SUPPORTS, CABLES, PULL BOXES, DISCONNECTS, ETC.
- ALL WIRING AND CONDUCTORS SHALL BE COPPER.
- EMT MAY BE USED WITHIN CODE LIMITS.
- DO NOT USE ALUMINUM CONDUIT IN SLAB OR BURIED.
- NO BRANCH CIRCUIT WIRE SIZE SHALL BE LESS THAN NO. 12
- COLOR CODE ALL CONDUCTORS.
- USE FLEXIBLE CONDUIT 12" LONG FOR MOTOR CONNECTIONS.
- PROVIDE TYPEWRITTEN DIRECTORY FOR PANELS.
- USE LEVITON 5800 RECEPTACLES & PLASTIC DEVICE PLATES.
- WALL SWITCHES: LEVITON 5501-15 AMPS PLASTIC DEVICE PLATES.
- WIRE ALL FIELD ASSEMBLED DEVICES FOR MECHANICAL EQUIPMENT FURNISHED BY MECHANICAL CONTRACTOR.
- ALL WORK SHALL COMPLY W/ NATIONAL ELECTRICAL CODE.

FIXTURE SCHEDULE:

- (A) 2'x4' LINEAR FLUORESCENT LIGHT FIXTURE
- (B) 2'x4' LINEAR EMERGENCY FLUORESCENT LIGHT FIXTURE
- (C) 6" CAN LIGHT

ELECTRICAL LEGEND:

- 1/2"x6'-0" LONG FLEXIBLE METAL RACEWAY
CONDUCTORS REQUIRED PLUS INSULATED GROUND CONDUCTOR
- 20A 125/177 SPEC. GRADE HUBBELL SERIES 1221 TOGGLE SW. W/ THERMOPLASTIC HIGH-IMPACT RESISTANT COVER PLATE TO MATCH RECEPT. COVER PLATE COLOR SEL. BY ARCH. ON ROOM-BY-ROOM BASIS
3 - 3-WAY SWITCH
4 - 4-WAY SWITCH
- DISCONNECT SWITCH
- THERMOSTAT (MOUNT AT 5'-0" A.F.F.)
- LIGHT/VENT W/ ELECTRIC MOTOR FOR EXHAUST FAN
- 220V. RECEPTACLE
- EMERGENCY WALL PACK. EMERGENCY FIXTURES SHALL BE CONNECTED TO A LOCAL LIGHTING CIRCUIT, AHEAD OF ANY SWITCHING DEVICE.
- EXIT LIGHT
- 20A 125V DUPLEX REC. HUBBELL W/ THERMOPLASTIC WALL PLATE COLOR SELECTED BY ARCHITECT ON ROOM-BY-ROOM BASIS MOUNT AT 12" A.F.F. UNLESS OTHERWISE NOTED
GFI - GROUND FAULT INTERRUPTER
CT - COUNTERTOP HEIGHT
WP - WATER PROOF
UC - UNDER COUNTER

KING

architects INC.

Barry D. King, AIA,
Architect

1312 Sampson St.
Westlake, LA 70669
337.494.0806

© COPYRIGHT 2026
ALL INFORMATION, EITHER DRAWN, WRITTEN, OR IMPLIED APPEARING IN THIS DOCUMENT SHALL NOT BE DUPLICATED, DISCLOSED, OR OTHERWISE USED WITHOUT THE WRITTEN PERMISSION OF BARRY D. KING AIA. THIS DOCUMENT IS AN INSTRUMENT OF SERVICE AND IS THE SOLE PROPERTY OF THE AUTHOR. FURTHERMORE, THE USE OF THIS DOCUMENT FOR ANY PURPOSE SHALL BE REVOKED, IF THE INTENT OF THE DESIGN OR THE CONSTRUCTION TECHNIQUES OR DETAILS SHOWN HEREIN ARE NOT ADHERED TO OR THE CONTRACTUAL AGREEMENT GOVERNING THEIR USE ARE NOT STRICTLY ADHERED TO.

JOB NO: 2242
DATE: 7/7/26
DRWN. BY: NT
CHKD. BY: JC

REVISIONS





ETERNITY FULL GOSPEL
FELLOWSHIP HALL RE-BID
932 MULBERRY ST.
WESTLAKE, LA 70669
CALCASIEU PARISH

ELECTRICAL LIGHTING PLAN & DETAILS


E=100
SCALE: 1/4"=1'-0"

S:\ALL PROJECTS\Project 22\2242 ETERNITY FULL GOSPEL FELLOWSHIP\2242B ETERNITY FULL GOSPEL FELLOWSHIP HALL\Drawings\2242B ETERNITY FULL GOSPEL FELLOWSHIP HALL.dwg

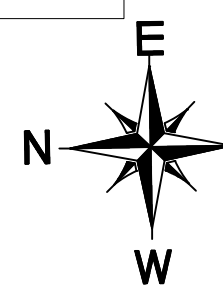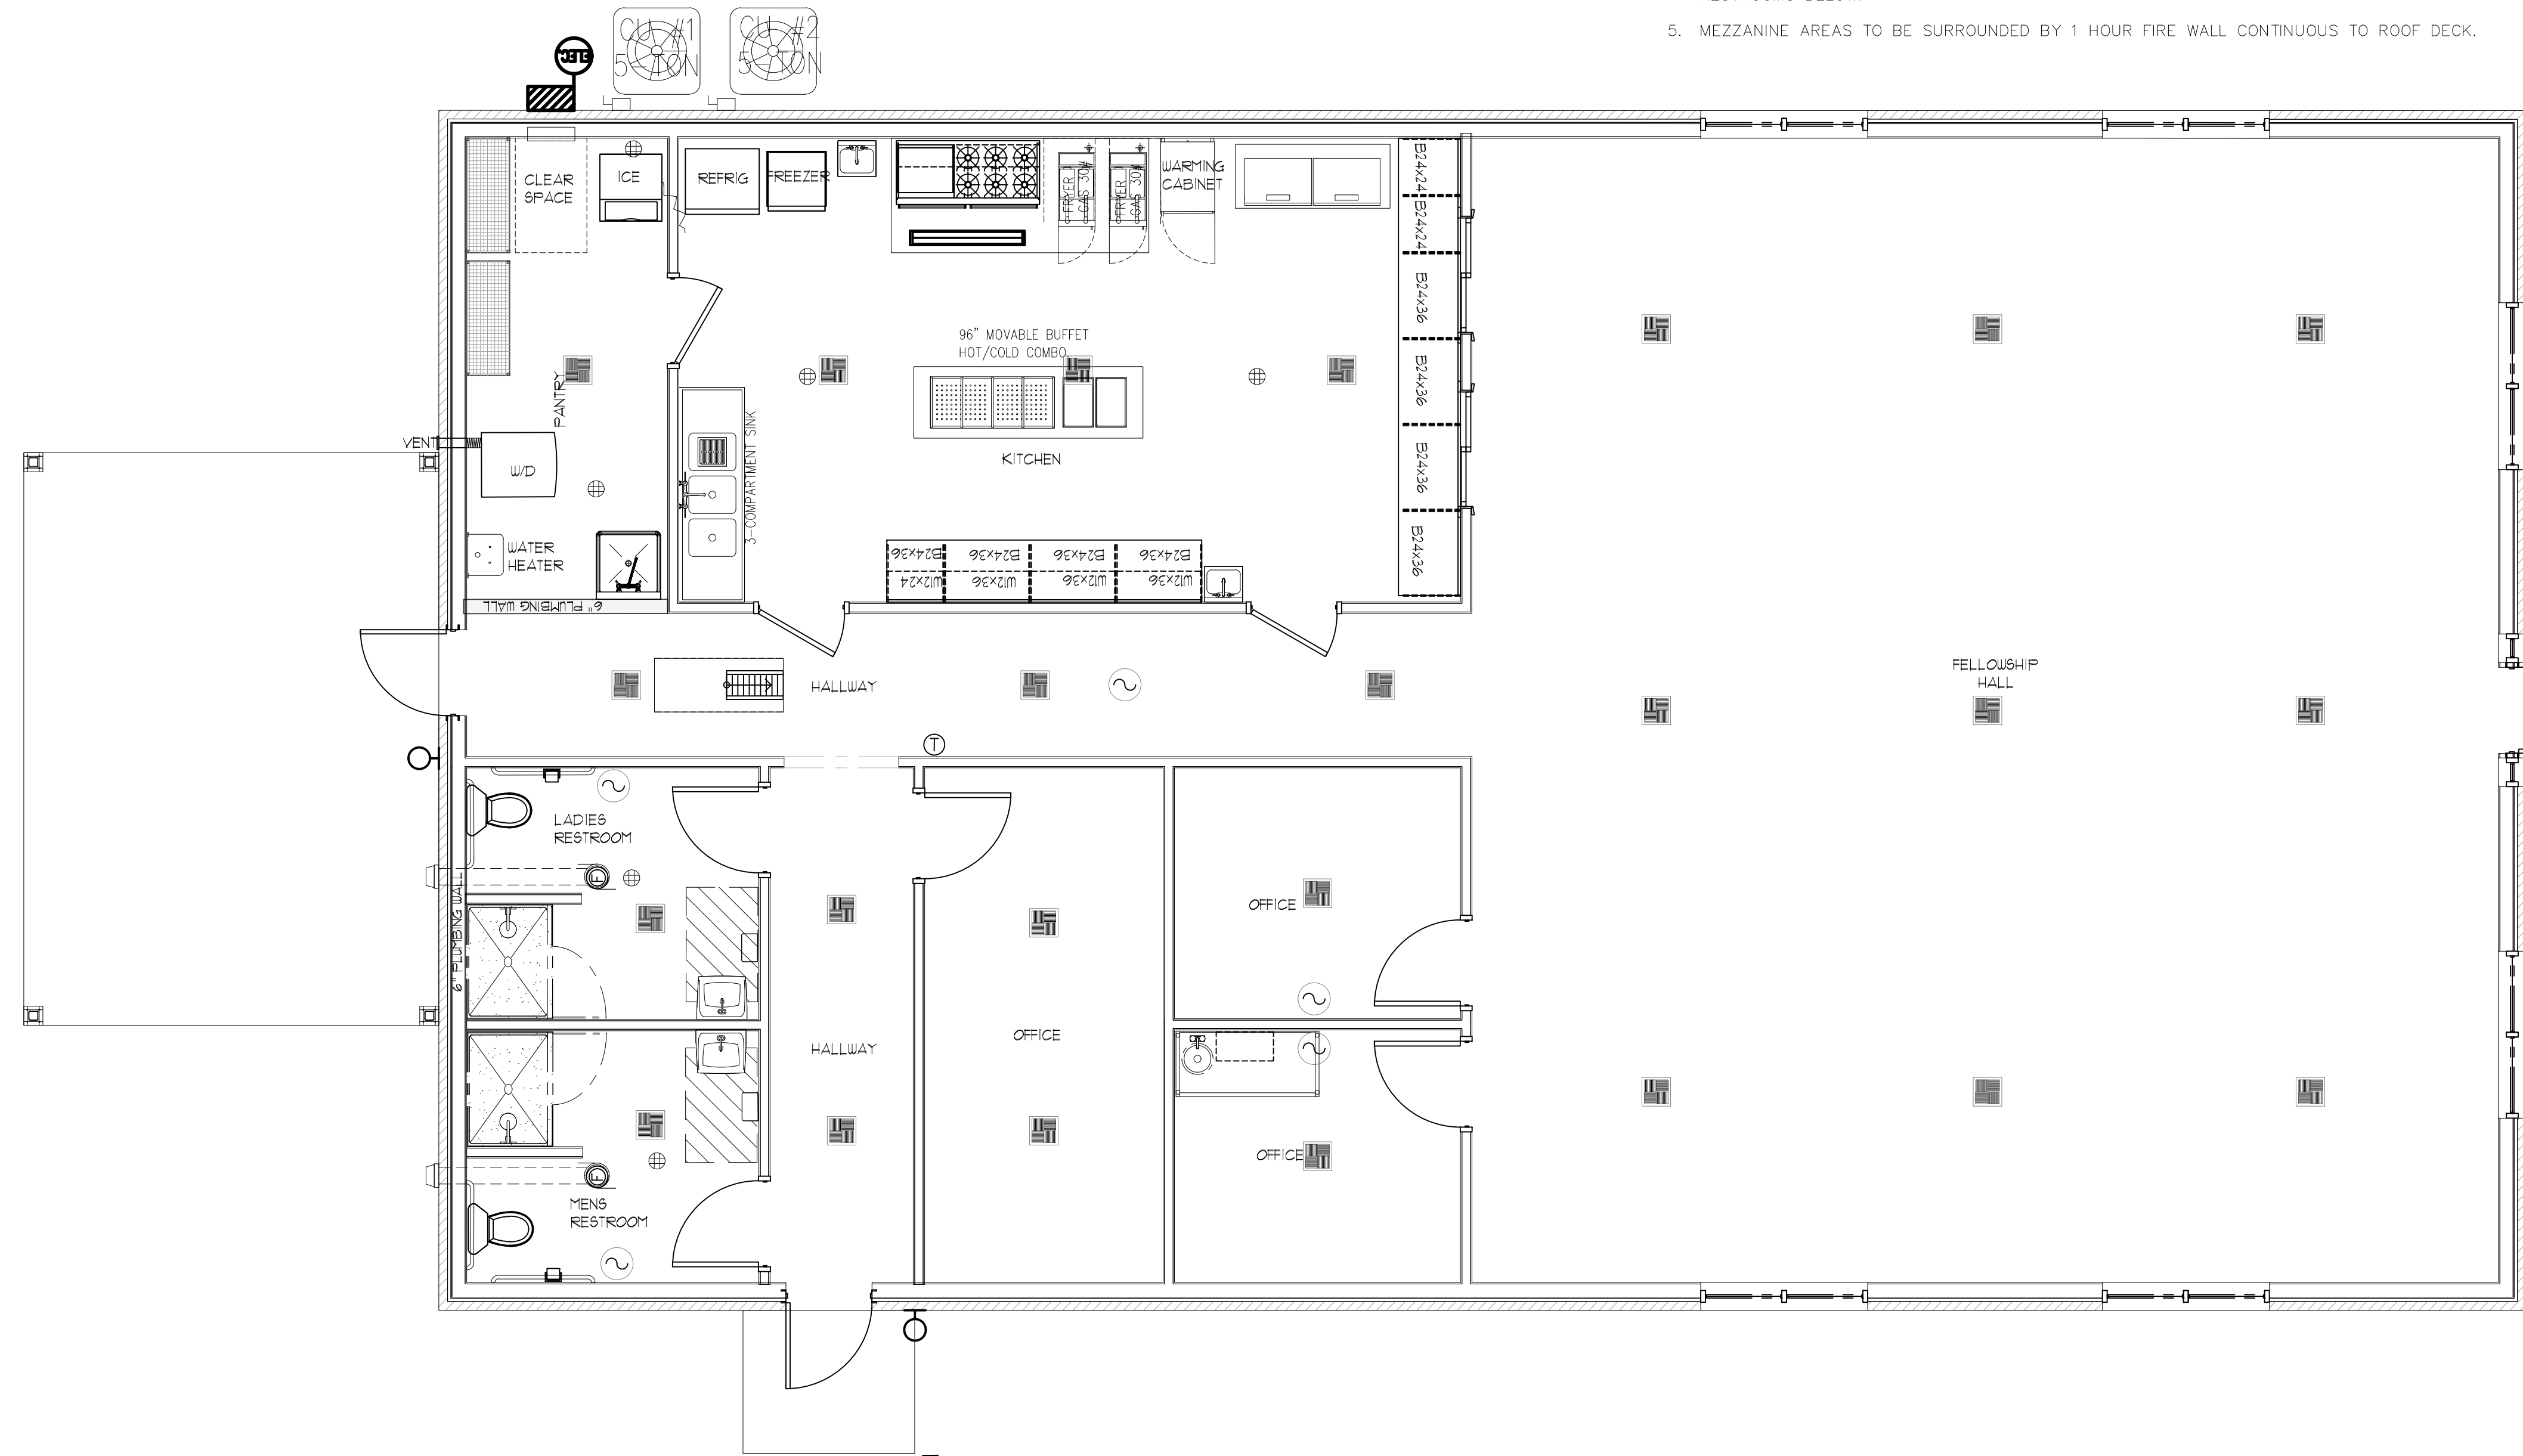


1 MECHANICAL PLAN


SCALE: 1/4"=1'-0"

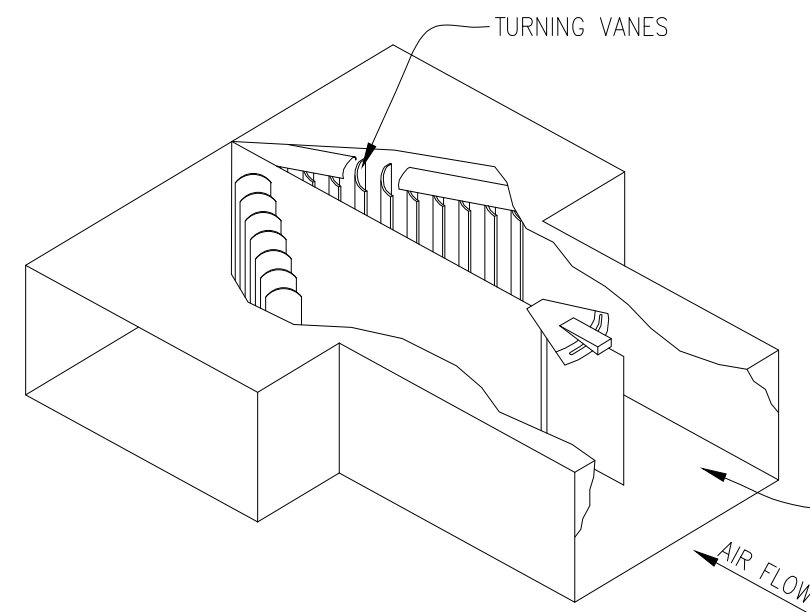


SPLITTER DAMPER

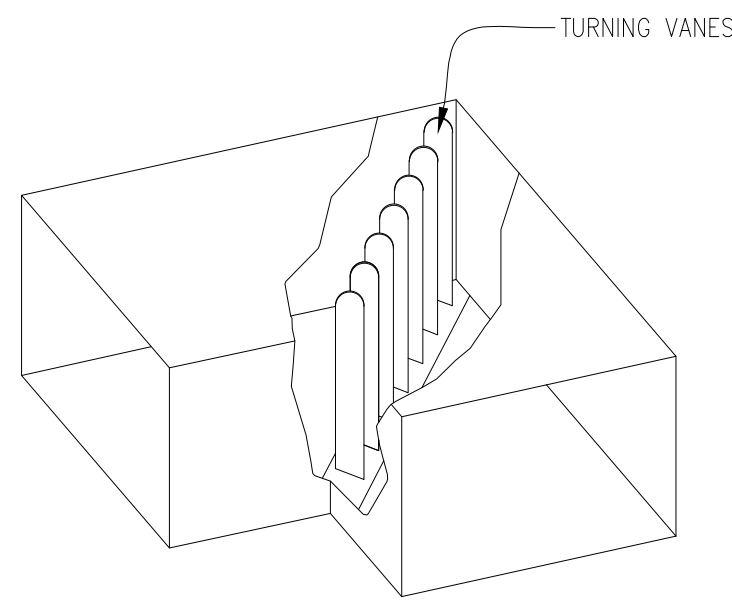

TURN WITH VANES

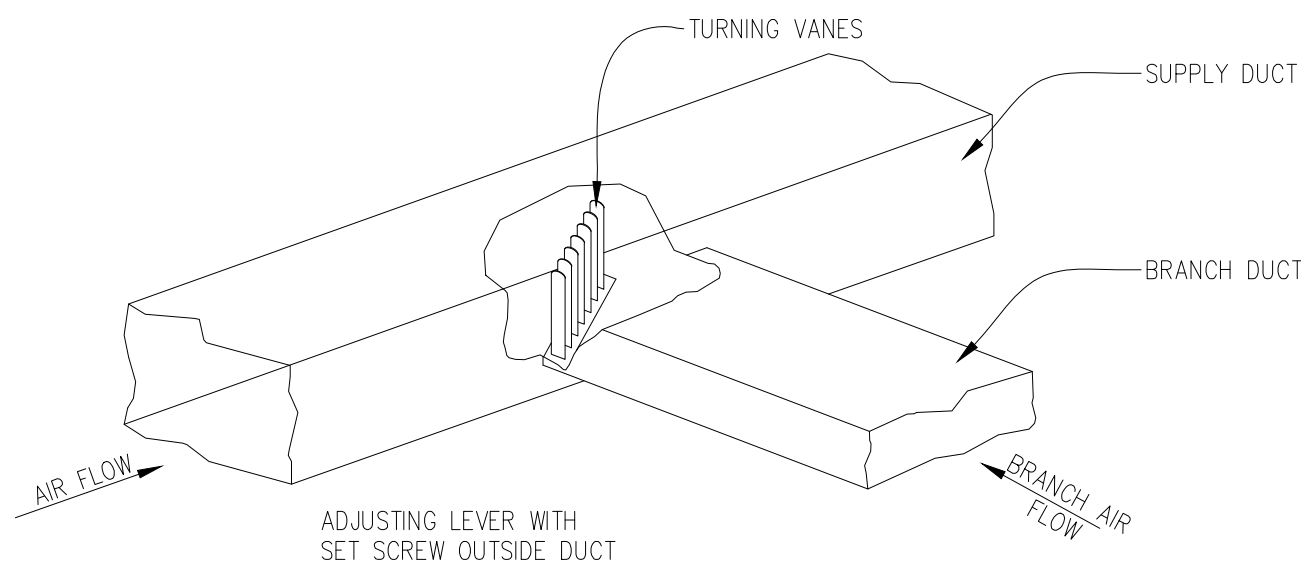

BRANCH TAKE-OFF

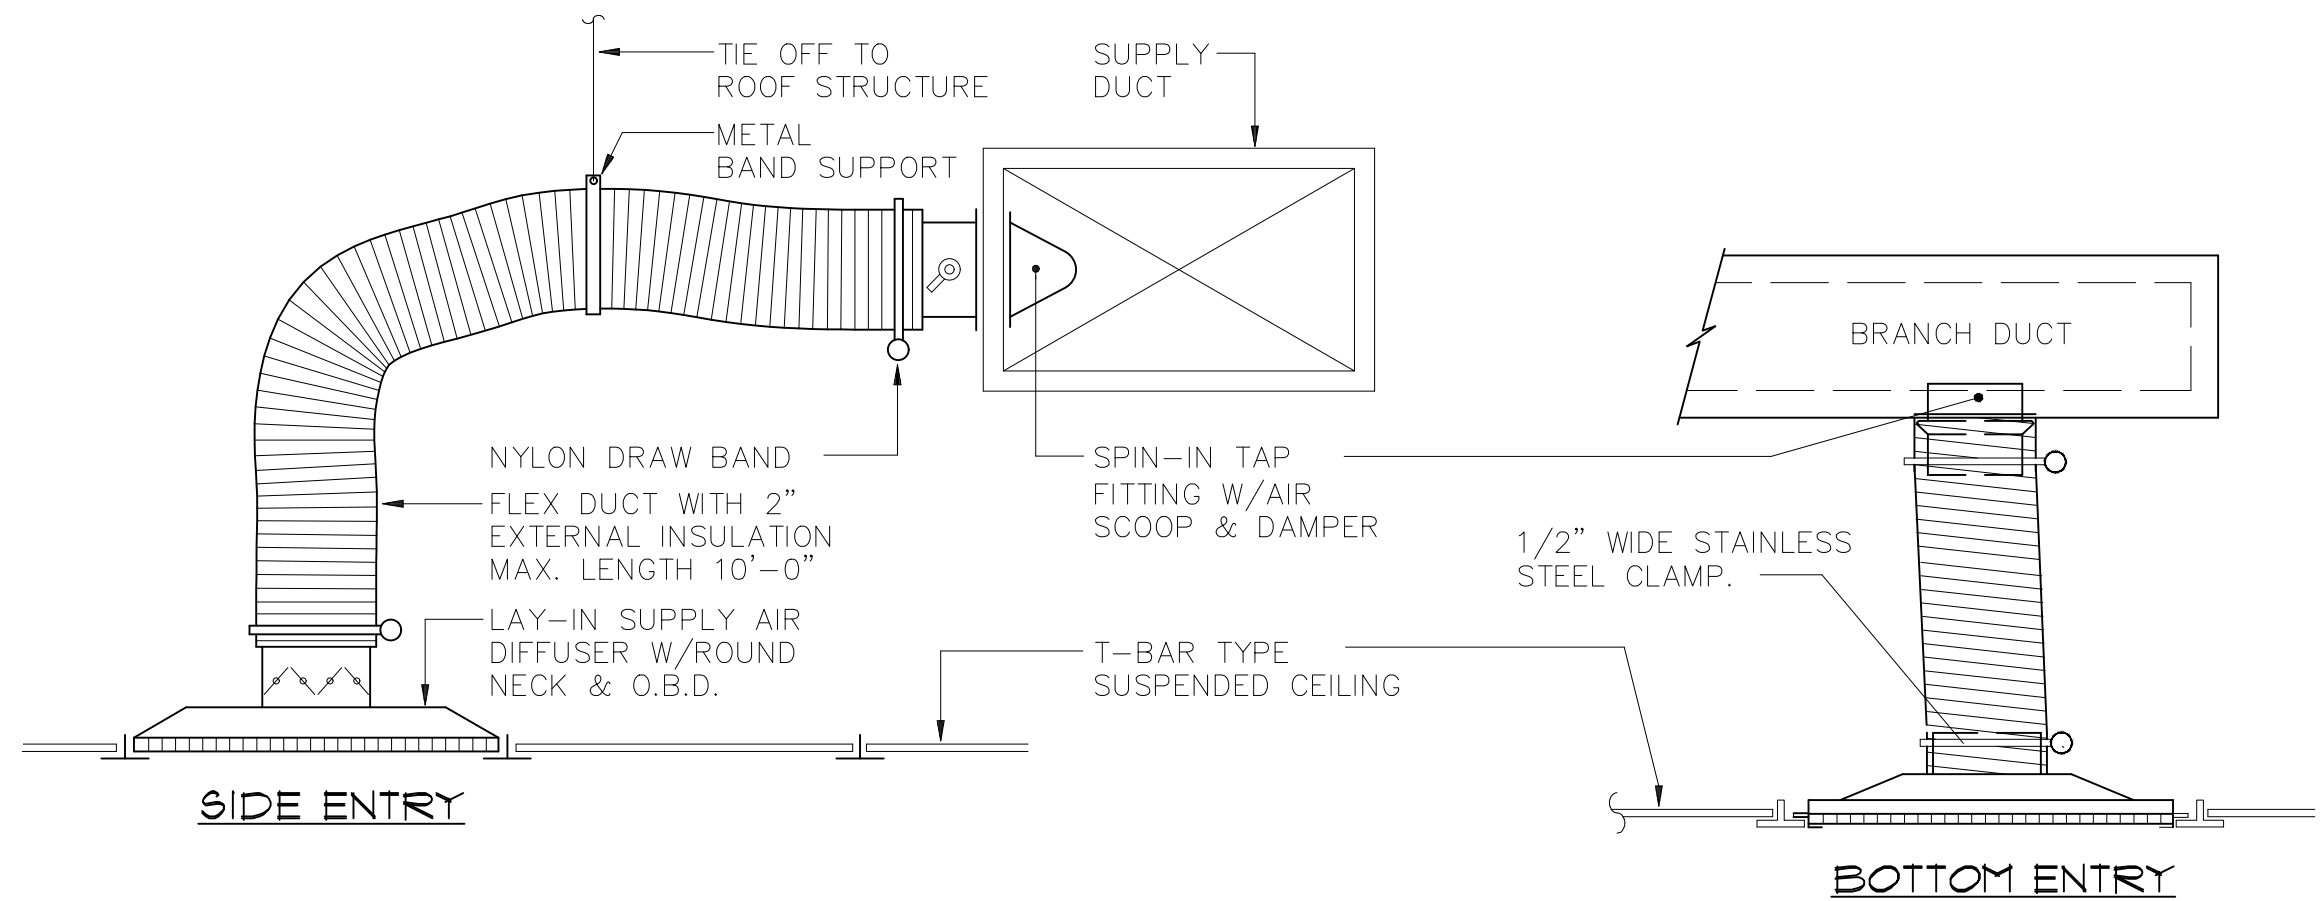

4 TYPICAL DIFFUSER DETAILS

SCALE: N.T.S.
RE:

HVAC NOTES:

1. ALL WORK PERFORMED SHALL BE ACCORDING TO EXISTING CODES/REGULATIONS.
2. CONTRACTOR SHALL VISIT SITE AND FAMILIARIZE HIMSELF WITH ENTIRE SCOPE OF PROJECT.
3. ALL WORK SHALL FOLLOW RECOGNIZED INDUSTRY STANDARDS.
4. FLEXIBLE DUCTS SHALL NOT EXCEED 10 FEET EXTENDED LENGTH.
5. MECHANICAL CONTRACTOR TO INSTALL TURNING VANES IN ALL DUCT ELBOWS. TURNING VANES TO BE DOUBLE-THICKNESS TYPE.
6. ALL DUCTWORK TO BE GALVANIZED SHEET METAL LINED WITH 1" ACOUSTICAL LINER.
7. ALL RESISTORS AND GRILLES TO HAVE INTERNAL BALANCING DAMPERS.
8. MECHANICAL CONTRACTORS TO VERIFY ROUTING FOR CLEARANCE OF BUILDING SUPPORTS PRIOR TO FABRICATION OF DUCTWORK.
9. WALL AND ROOF PENETRATIONS SHALL BE WATERTIGHT.
10. EXTERIOR AND UNDERGROUND LINES ARE TO BE ROVANCO INSUL-8 COPPER (TYPE K) UTILIZING SLEEVE AND "FIELD FOAM" FIELD CONNECTIONS, PVC FITTING COVERS, JACKET EXTENDERS & PVC END CAPS. LINES RUN INSIDE ARE TO BE COPPER (TYPE L) WITH FLEXIBLE UNICELLULAR INSULATION.
11. RUN DRAIN LINES FROM ALL EQUIPMENT/PANS FULL SIZE TO NEAREST DRAIN.


IMPORTANT - PROVIDE SMOKE DETECTOR ON SUPPLY SIDE OF AIR HANDLERS 2000 CFM OR OVER.

SMOKE DETECTOR NOTES:

1. ELECTRONICALLY POWERED MULTIPLE STATION DETECTORS INSTALLED IN ACCORDANCE W/ NFPA 72, (SUCH THAT THE ACTIVATION OF A SINGLE DETECTOR WILL CAUSE ALL DETECTORS TO SOUND).
2. DETECTORS TO BE SPACED IN ACCORDANCE W/ NFPA 72 AND PROVIDED IN ALL OCCUPIABLE SPACES THROUGHOUT THE FIRST FLOOR.

CONDENSATE PIPING NOTES:

1. UNIT CONDENSATE DRAIN PIPING INSTALLED WITHIN THE BUILDING SHALL BE TYPE "M" FOR 1" AND SMALLER OR "DWV" FOR 1-1/4" AND LARGER HARD TEMPER COPPER TUBE WITH WROUGHT COPPER DRAINAGE PATTERN FITTINGS AND SOLDERED CONNECTIONS MADE UP WITH 95/5 SOLDER. INSTALL CLEANOUTS AT ALL ELBOWS AND TURNS GREATER THAN 45 DEGREES. UNIT CONDENSATE DRAIN PIPING INSTALLED OUTSIDE THE BUILDING AND ABOVE GROUND SHALL BE SCHEDULE 40 PVC, WHERE ALLOWED BY CODE. (NOTE: PVC PIPING IS NOT ALLOWED IN CEILING RETURN AIR PLENUMS).

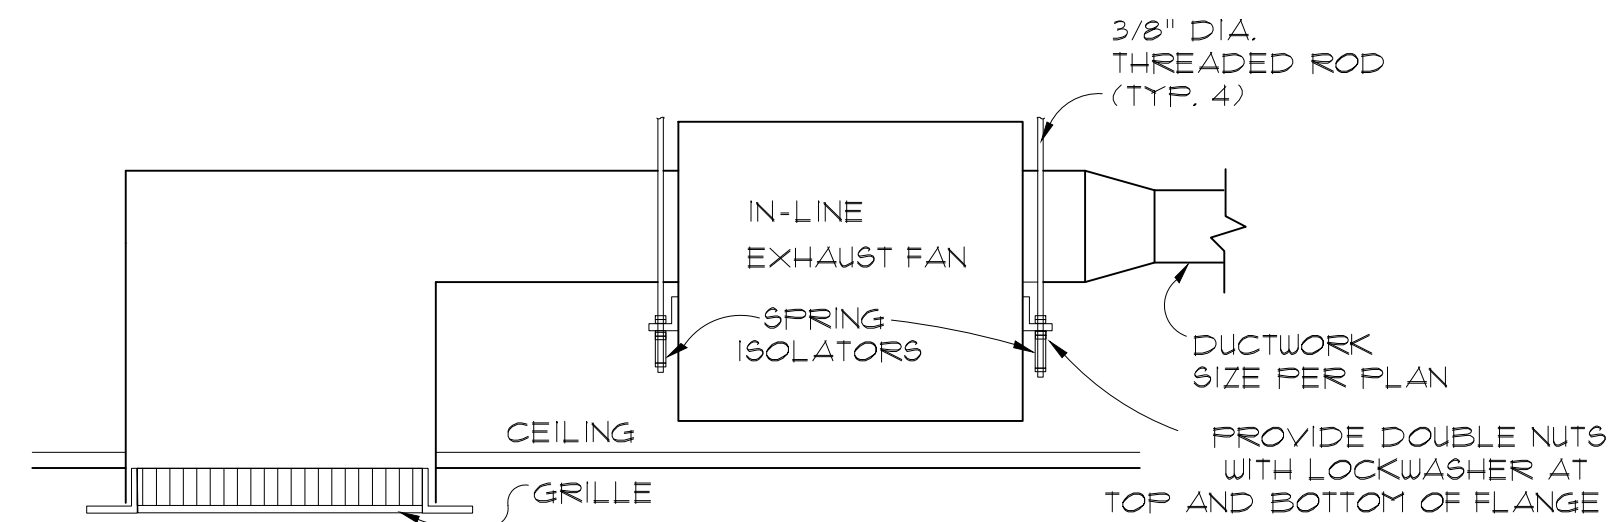

3 IN-LINE EXHAUST FAN DETAIL

SCALE: N.T.S.
RE:


KING
architects INC.

Barry D. King, AIA,
Architect
1312 Sampson St.
Westlake, LA 70669
337.494.0806

Q COPYRIGHT 2026
ALL INFORMATION, EITHER DRAWN, WRITTEN, OR IMPLIED APPEARING IN THIS DOCUMENT SHALL NOT BE DUPLICATED, DISCLOSED, OR OTHERWISE USED WITHOUT THE WRITTEN PERMISSION OF BARRY D. KING AIA. THIS DOCUMENT IS AN INSTRUMENT OF SERVICE AND IS THE SOLE PROPERTY OF THE AUTHOR. FURTHERMORE, THE USE OF THIS DOCUMENT FOR ANY PURPOSE SHALL BE REVOKED, IF THE INTENT OF THE DESIGN OR THE CONSTRUCTION TECHNIQUES OR DETAILS SHOWN HEREIN ARE NOT ADHERED TO OR THE CONTRACTUAL AGREEMENT GOVERNING THEIR USE ARE NOT STRICTLY ADHERED TO.

JOB NO: 2242
DATE: 7/7/26
DRWN. BY: NT
CHKD. BY: JC

REVISIONS

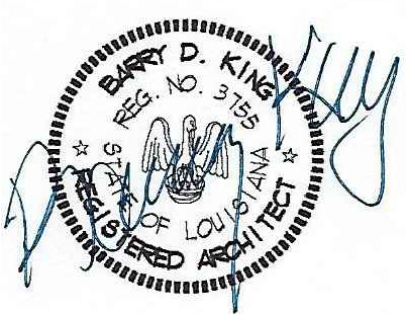

ETERNITY FULL GOSPEL
FELLOWSHIP HALL RE-BID
932 MULBERRY ST.
WESTLAKE, LA 70669
CALCASIEU PARISH

MECHANICAL
PLAN &
DETAILS


M-100
SCALE: 1/4"=1'-0"

PLUMBING FIXTURE SCHEDULE								
TAG	TYPE OF FIXTURE	NO. REQ'D.	MANUFACTURER & CATALOG NO.	PIPE CONNECTION SIZES				REMARKS
				CW	HW	WASTE	VENT	
WC-A	WATER CLOSET	1	KOHLER K-4350 SLOAN - REGAL 111-1.6 CHURCH	1"	--	4"	3"	
WC-B	WATER CLOSET	1	KOHLER K-4368 SLOAN - REGAL 111-1.6 CHURCH	1"	--	4"	3"	
SK-A	SINGLE SINK	1	ELKAY - LR-1919 T&S -B2867-04FC LENONARD- 170D-LF	1/2"	1/2"	2"	2"	
SK-B	SINGLE SINK	1	ELUH6FB T&S -B2867-04FC LEONARD- 170D-LF	1/2"	1/2"	2"	2"	
FD-A	FLOOR DRAIN	3	WADE	--	--	3"	2"	
FD-B	FLOOR DRAIN	3	WADE	--	--	3"	2"	
MP	MOP SINK	1	FIAT MSB-2424	3/4"	3/4"	3"	2"	
SK-C	SINGLE SINK	2	ELKAY - ESHS17X	1/2"	1/2"	2"	2"	
SK-D	3-COMPARTMENT SINK	1	ELKAY 14-3C16X200X, T&S B-0133-EE-B, LK945DS20L2T	1/2"	1/2"	2"	2"	
W.H.	TANK LESS WATER HEATER	1	RTG-R-199-N1 INFINITI GR SERIES HIGH EFFICIENCY CONDENSING	3/4"	3/4"	--	2"	3/4" GAS
FS	FLOOR SINK	1	ZURN Z1901 12"x12"x8"	1/2"	1/2"	3"	2"	
SHA	ACRYIX	2	48x35x72, 1 PC. SHOWER STALL, 2 SEAT AND CENTER DRAIN	3/4"	3/4"	3"	2"	
-	MOEN #B2975SRN	2	ATTRACT W/MAGNETIX 6 SPRAY SINGLE HANDLE SHOWER FAUCET	1/2"	1/2"	--	--	
-	OATEY 140 SERIES/101 PNC	2	ROUND NO CAULK WHITE PVC SHOWER DRAIN W/S.S.COVER	--	--	--	--	
WMB	GUY GREY BIM B200	1	RECESSED GALV. STEEL WM VALVE BOX W/3/4" HOT & COLD WATER, THREADED SUPPLY W/SHUT OFF & 2" DRAIN	3/4"	3/4"	2"	2"	
IMB	GUY GRAY BIM 875	1	PROVIDE 3/8" ANGLE SUPPLY W/STOP IN 20 GA. METAL, RECESSED FLUSH MOUNTED BOX, 12" A.F.F.	1/2"	--	--	--	
HBA	WOODFORD	--	WOODFORD 24P 3/4", SIPHON VAC. BREAKER PROTECTED WALL FAUCET W/3/4" HOSE THREAD, BRASS CONST. TEE KEY HANDLE	3/4"	--	--	--	
FCO	WADE	--	WADE 6000, CAST IRON FLOOR CLEANOUT	--	--	LINESIZE	--	

NOTE: ALL PIPE CONNECTION SIZES ARE BASED ON TYPICAL SIZE REQUIREMENTS. ALL SIZES ARE SUBJECT TO CHANGE DUE TO OWNER'S SPECS.

PLUMBING NOTES:

1. COMPLY WITH ALL LOCAL, COUNTY, AND FEDERAL CODES, ORDINANCES, RULES, AND REGULATIONS.
2. COMPLY WITH ALL REFERENCED COMMERCIAL STANDARDS, SPECIFICATIONS, CODES, RULES, ETC.
3. EXACT LOCATION OF PLUMBING FIXTURES SHALL BE DETERMINED FROM ARCHITECTURAL DRAWINGS.
4. BEFORE SUBMITTING BID, THE PLUMBING CONTRACTOR SHALL REVIEW THE ARCHITECTURAL DRAWINGS AND THE EQUIPMENT DRAWINGS AND SHALL INCLUDE IN HIS BID AN AMOUNT TO FURNISH AND INSTALL ANY FIXTURES WHICH ARE SHOWN IN ADDITION TO FIXTURES SHOWN ON THE PLUMBING DRAWINGS.
5. ADEQUATELY SUPPORT ALL PIPING AGAINST SAGGING, POCKETING, SWAYING, AND DISPLACEMENT, PROPERLY SPACE AND APPLY HANGERS PER MSS SP-69.
6. CONTRACTOR SHALL ROUGH-IN WASTES AND SUPPLIES TO SPECIAL EQUIPMENT ACCORDING TO MANUFACTURER'S SHOP DRAWINGS AND MAKE FINAL CONNECTIONS. ALL SUPPLIES SHALL BE VALVED.
7. EXPOSED PIPING OTHER THAN SPECIFICALLY NOTED OTHERWISE SHALL BE CHROME PLATED. WHERE WATER PIPES AND VALVES ARE EXPOSED IN TOILET AREAS, PIPING SHALL BE THREADED CHROME AND SHALL HAVE CHROME PLATED ESCUTCHEONS AND VALVE AS REQUIRED.
8. GENERAL MECHANICAL, ELECTRICAL, AND PLUMBING CONTRACTORS AND SUB-CONTRACTORS SHALL COORDINATE THEIR WORK PRIOR TO INSTALLATION TO PROVIDE FOR PROPER CLEARANCES BETWEEN EQUIPMENT, DUCTWORK, PIPING, JOISTS, CEILINGS, ETC.
9. SUPPLIER SHALL NOT QUOTE PRICES OR SUPPLY EQUIPMENT TO CONTRACTORS WITHOUT REVIEWING PLANS AND SPECIFICATIONS.

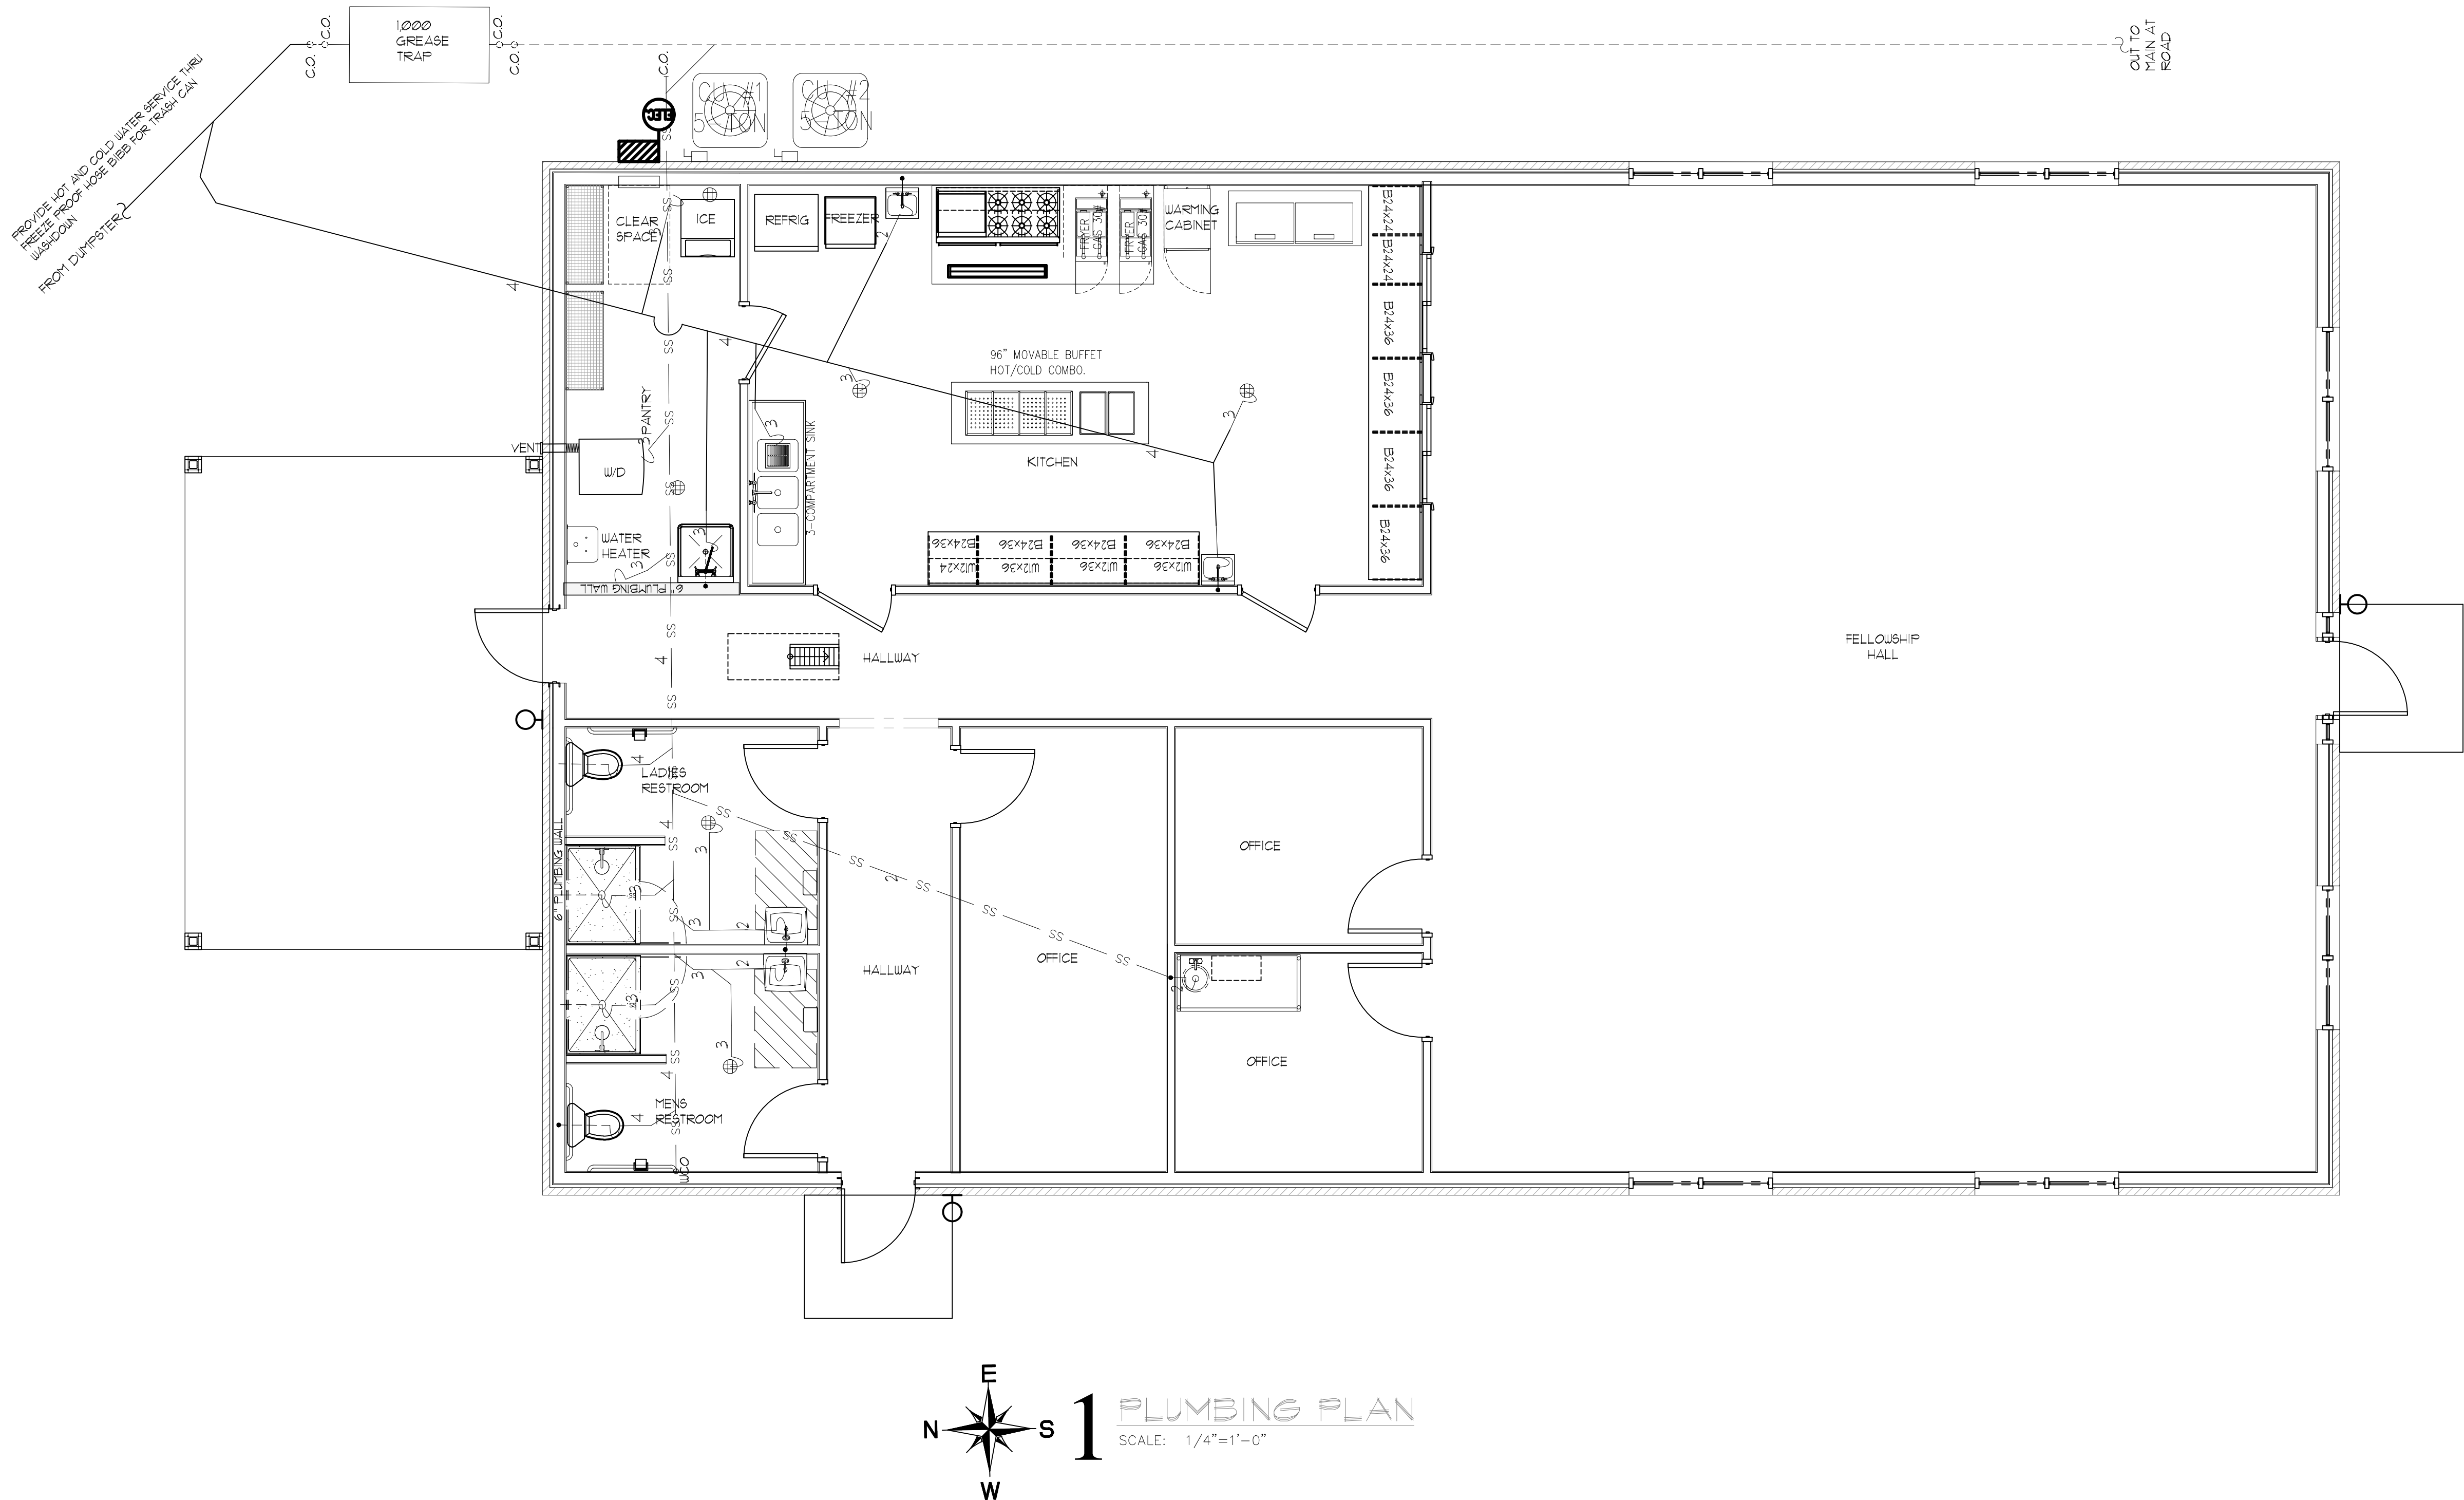

KING

architects
INC.

Barry D. King, AIA,
Architect

1312 Sampson St.

Westlake, LA 70669

337.494.0806

Q COPYRIGHT 2026
ALL INFORMATION, EITHER DRAWN,
WRITTEN, OR IMPLIED APPEARING IN THIS
DOCUMENT SHALL NOT BE DUPLICATED,
DISCLOSED, OR OTHERWISE USED
WITHOUT THE WRITTEN PERMISSION OF
BARRY D. KING AIA. THIS DOCUMENT IS
AN INSTRUMENT OF SERVICE AND IS THE
SOLE PROPERTY OF THE AUTHOR.
FURTHERMORE, THE USE OF THIS
DOCUMENT FOR ANY PURPOSE SHALL BE
REVOKED, IF THE INTENT OF THE DESIGN
OR THE CONSTRUCTION TECHNIQUES OR
DETAILS SHOWN HEREIN ARE NOT
ADHERED TO OR THE CONTRACTUAL
AGREEMENT GOVERNING THEIR USE ARE
NOT STRICTLY ADHERED TO.

JOB NO: 2242
DATE: 7/7/26
DRWN. BY: NT
CHKD. BY: JC

REVISIONS



ETERNITY FULL GOSPEL
FELLOWSHIP HALL RE-BID
932 MULBERRY ST.
WESTLAKE, LA 70669
CALCASIEU PARISH

PLUMBING
PLAN &
DETAILS

P-100
SCALE: 1/4" = 1'-0"