
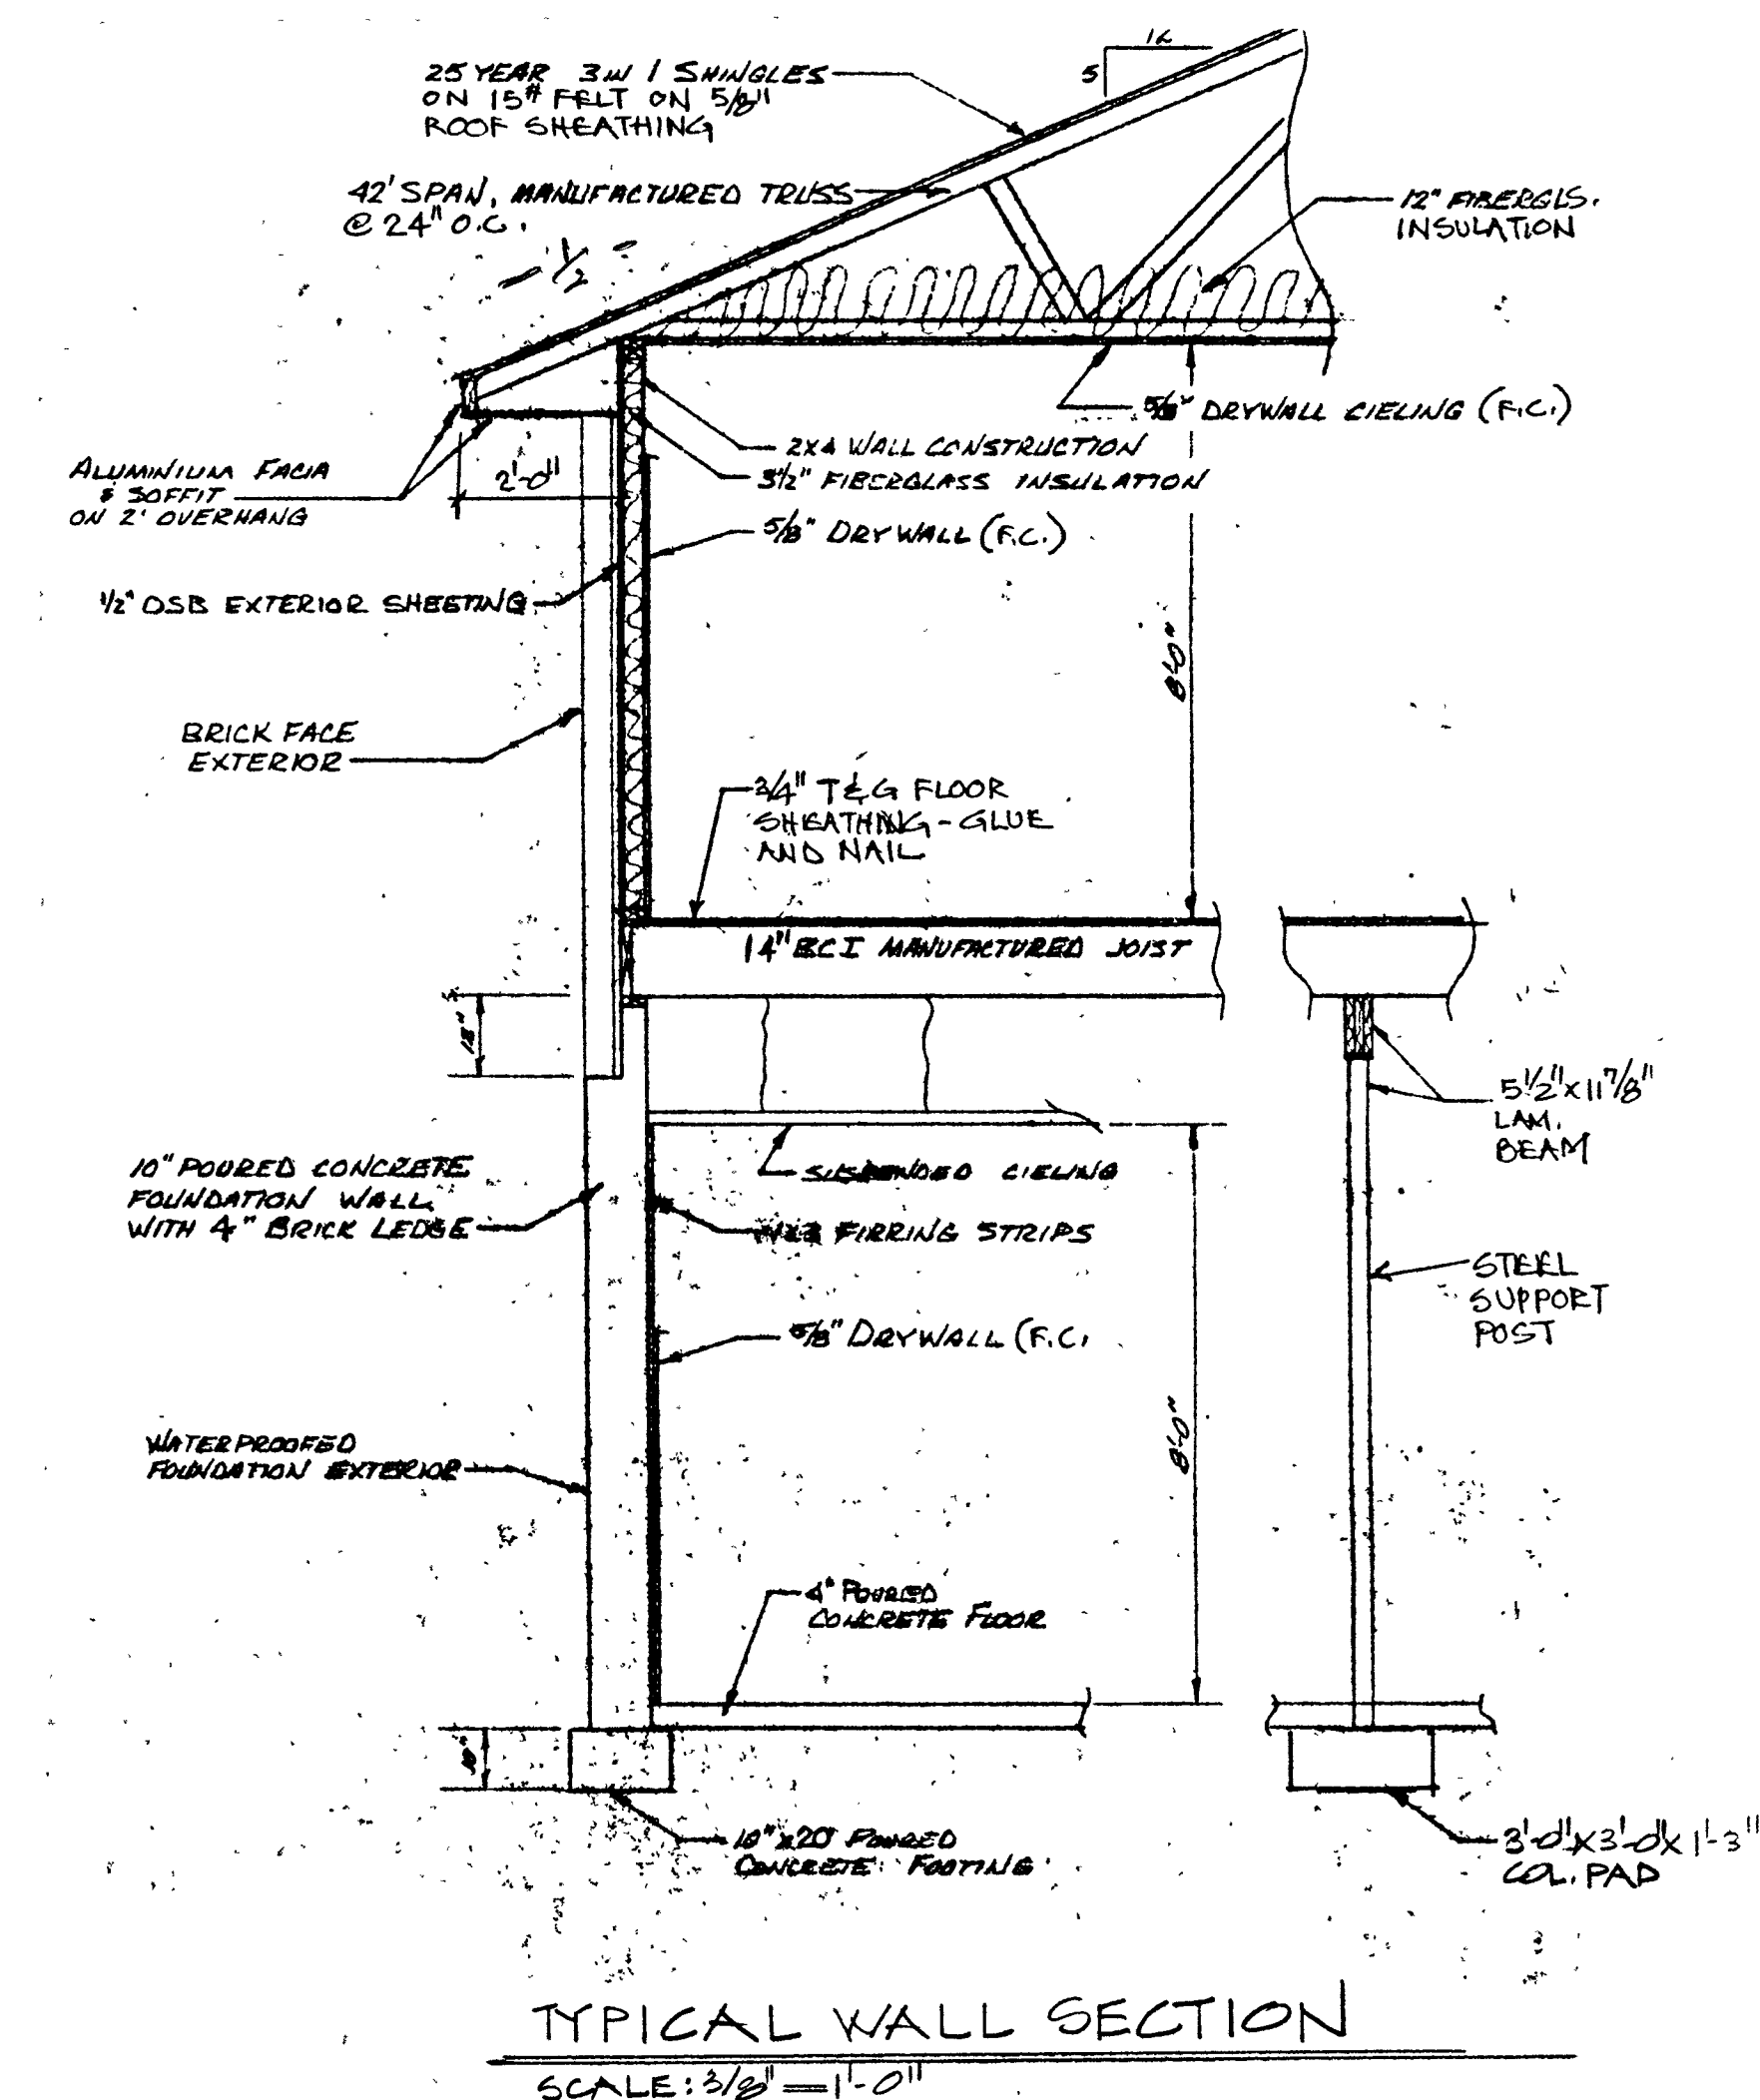


Sheet No. **A.1**
Exp. 11-30-96

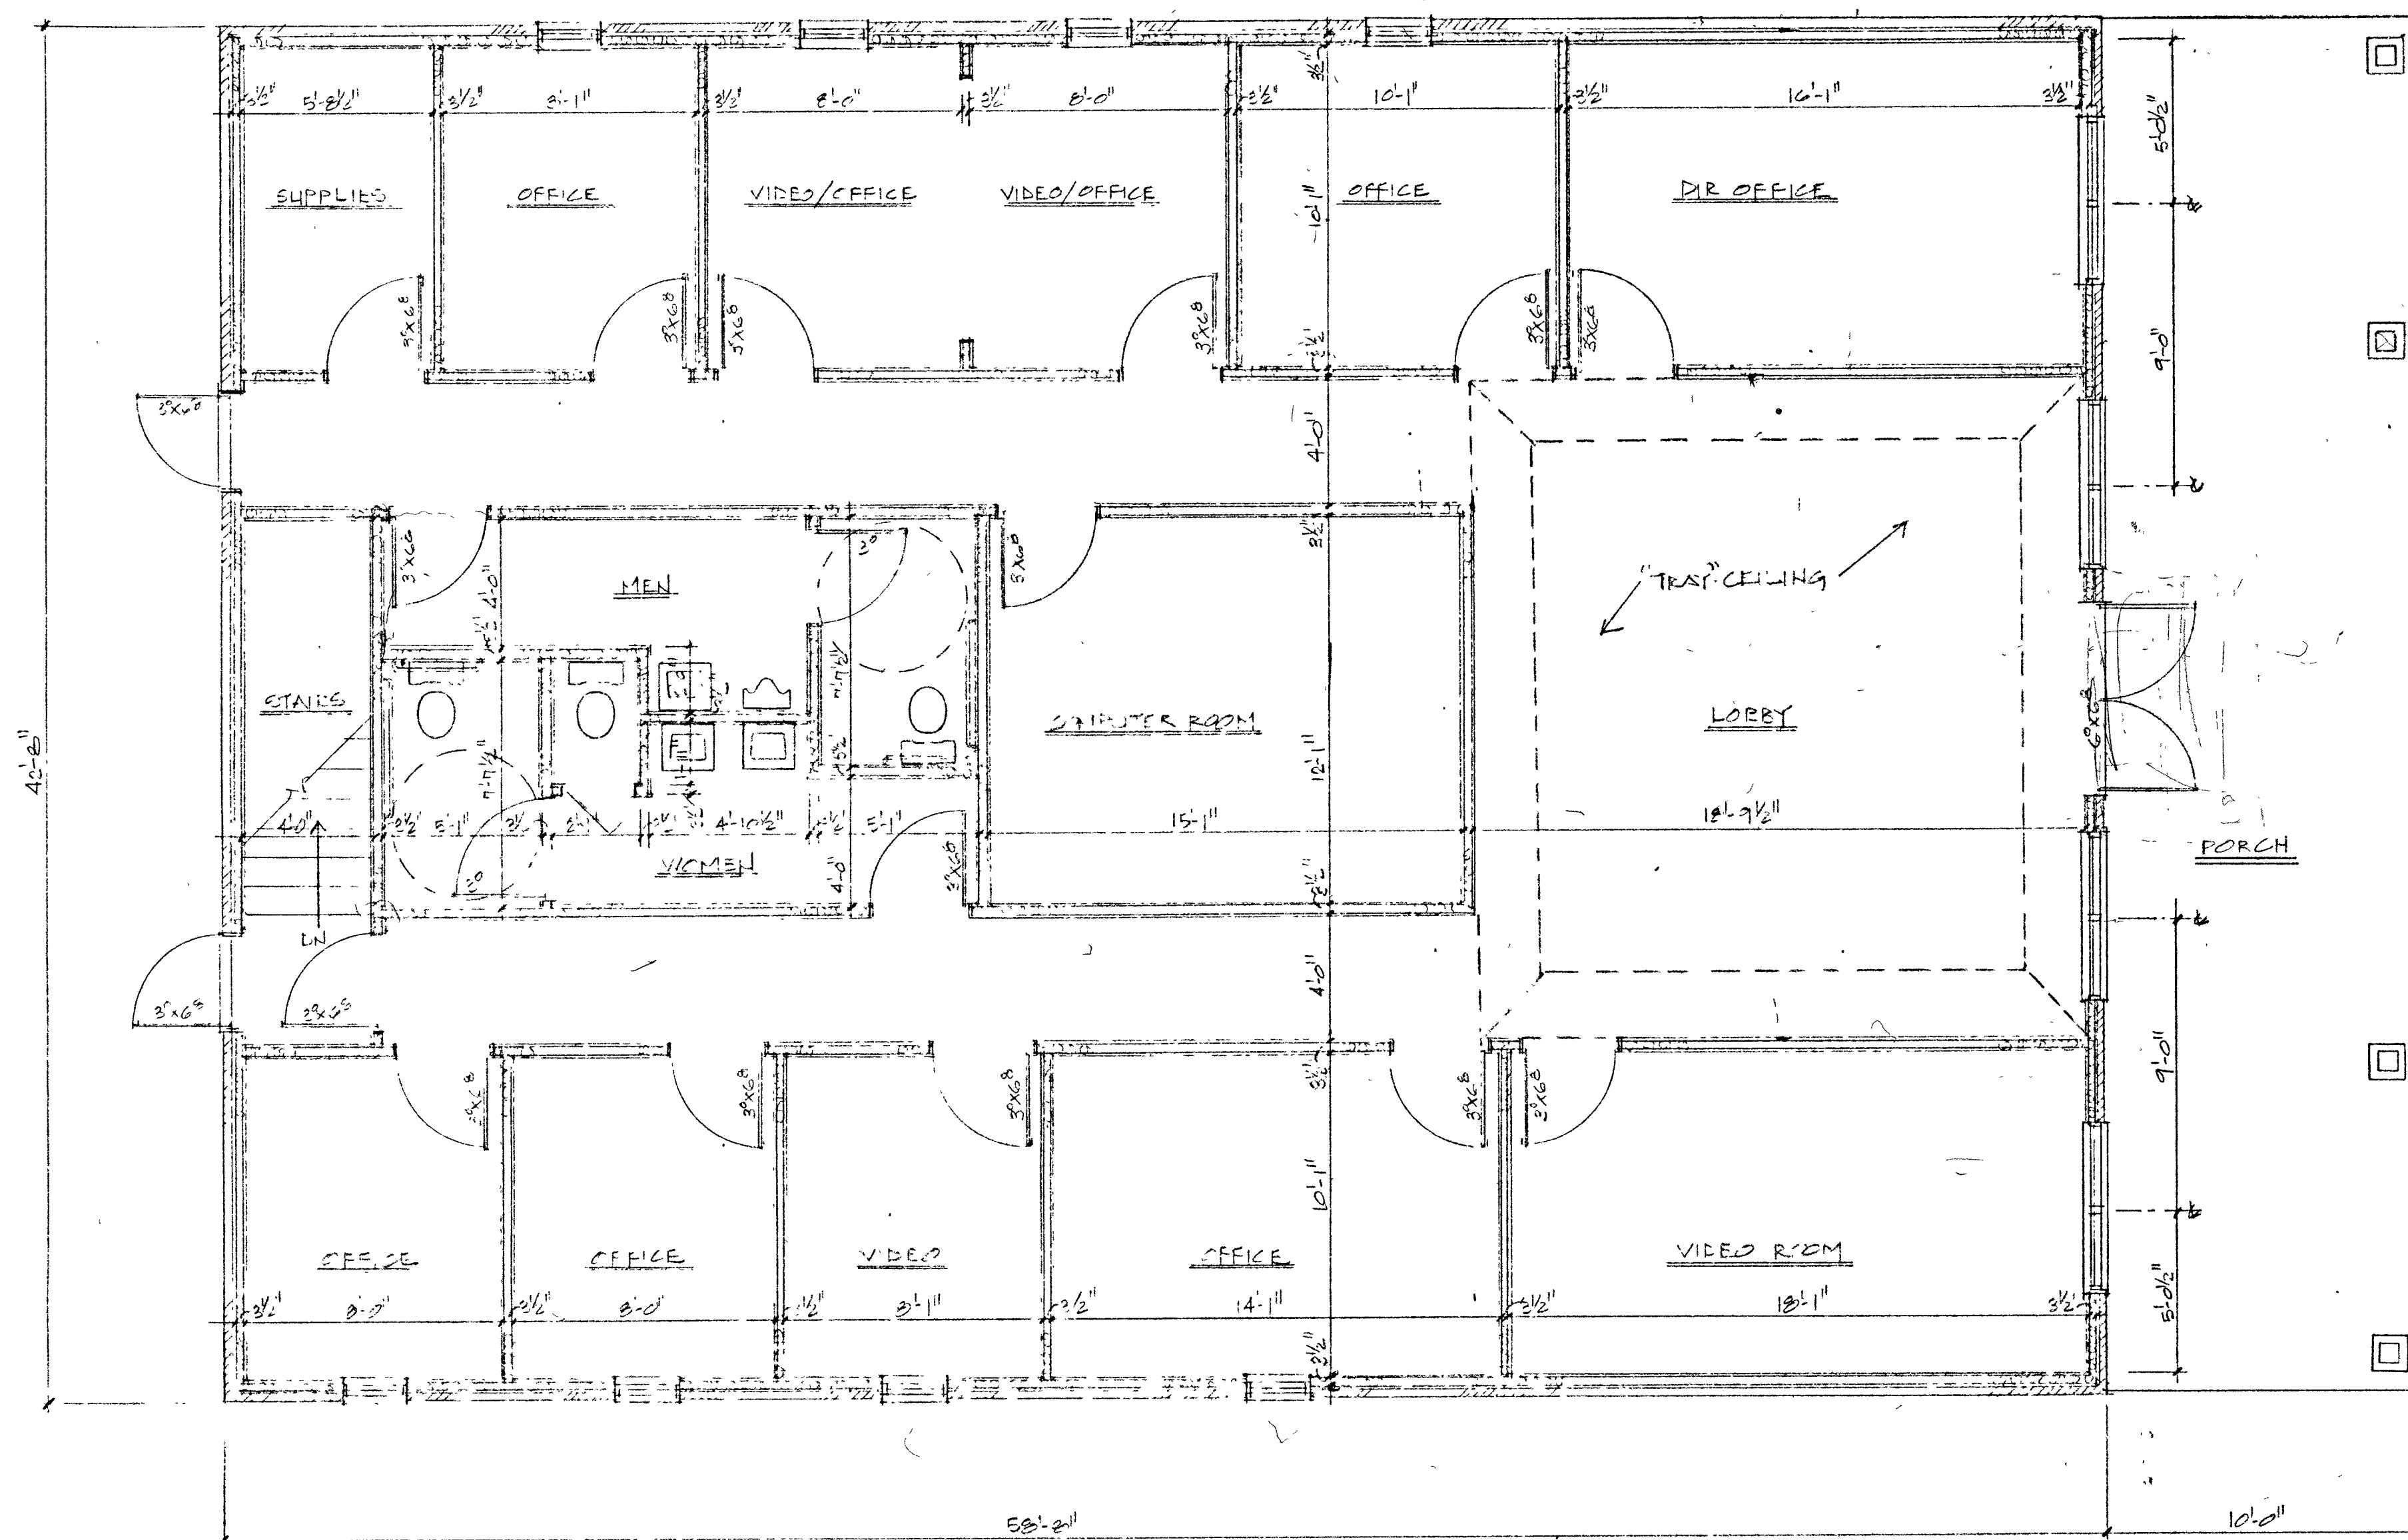


ADMISSIONS BUILDING for
LINCOLN COLLEGE
LINCOLN, ILLINOIS


Date AUG 17, 1993	Project No. 98-15-S
Drawn By K.A.S.	

KELLY A. SANNER
Architect ▼ Planner ▼ Construction Mgr


Sheet No. A-2

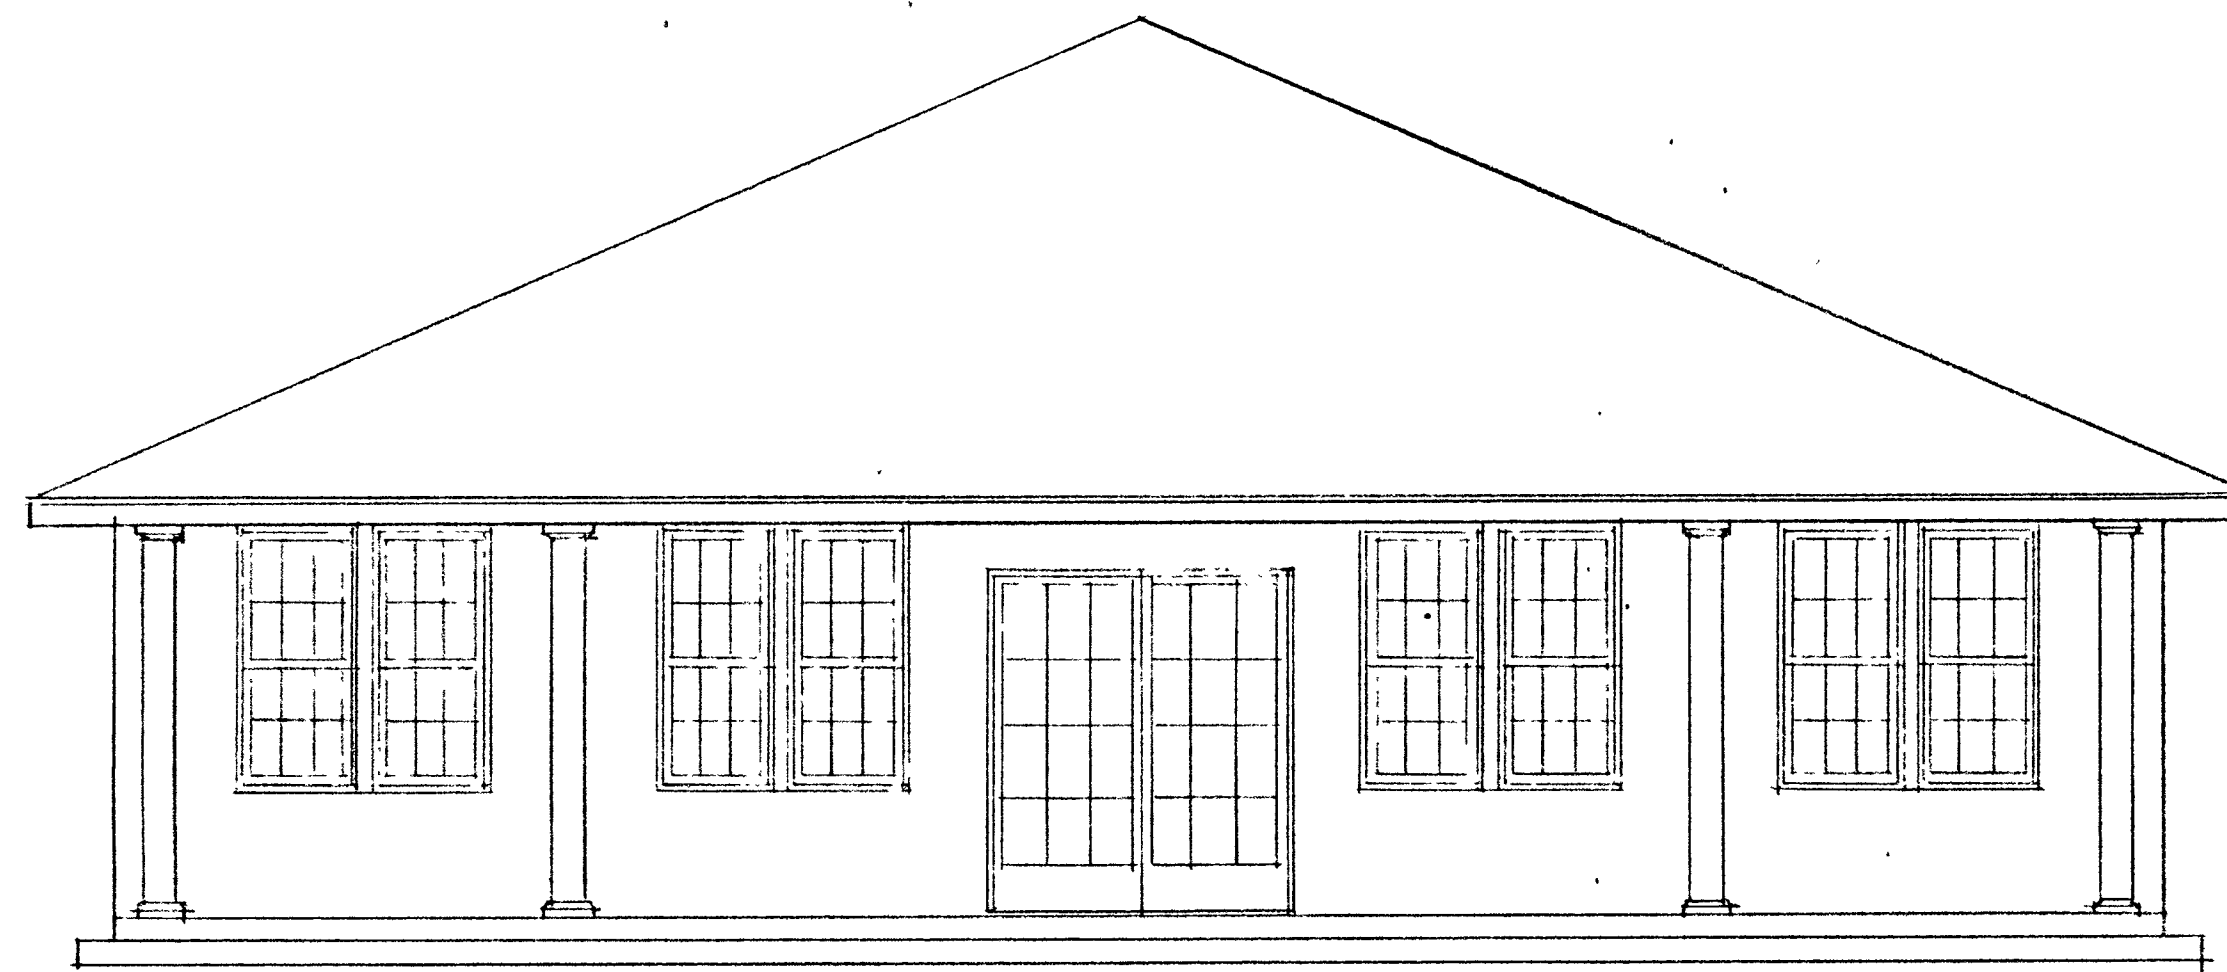

FRONT ELEVATION
SCALE: 1/4" = 1'-0"

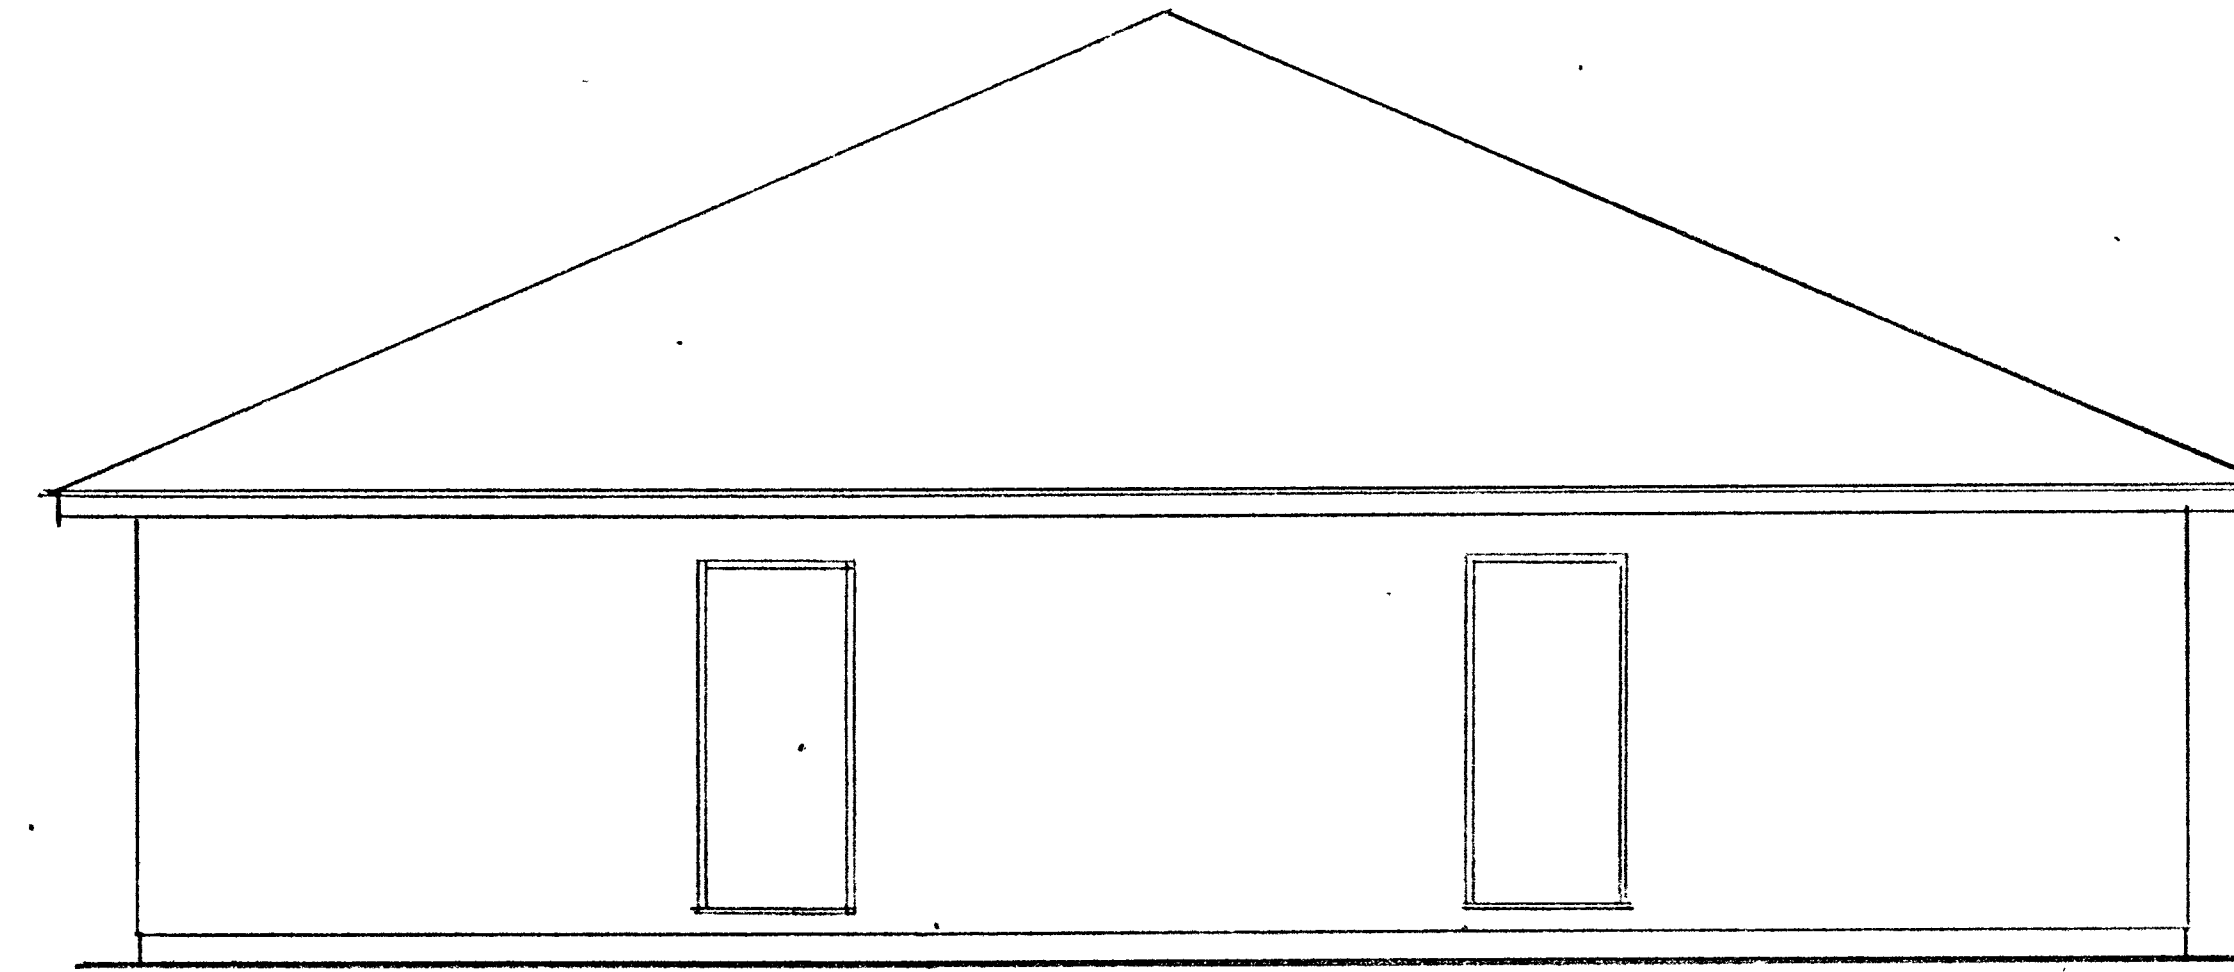

REAR ELEVATION
SCALE: 1/4" = 1'-0"

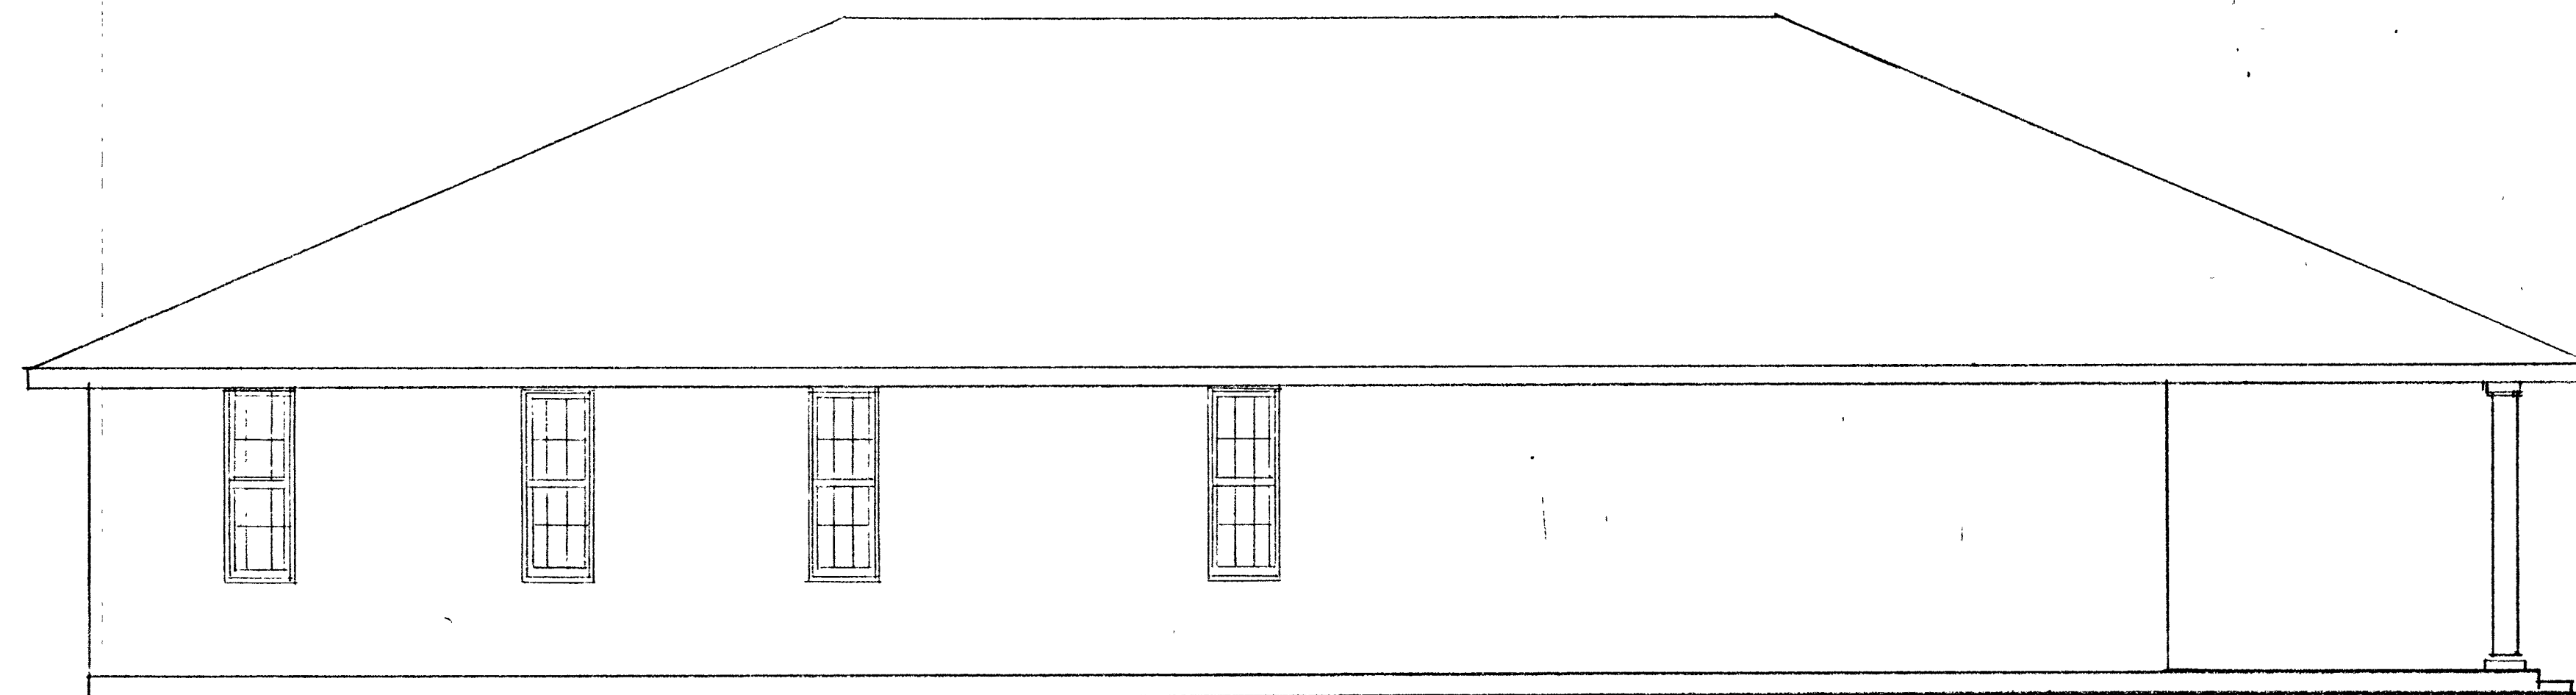

LEFT (RIGHT MIRROR IMAGE) ELEVATION
SCALE: 1/4" = 1'-0"

ADMISSIONS BUILDING for
LINCOLN COLLEGE
LINCOLN, ILLINOIS

Date	Aug 7, 1998	Project	No.
			98-15-B
Drawn	By		
	K.A.S.		



KELLY A. SANNER
Architect ▼ Planner ▼ Construction Mgr

Sheet No.
A-3

BATHROOM ACCESSORIES		
NOTE: ALL MOUNTING REQUIREMENTS SHALL COMPLY WITH THE AMERICAN NATIONAL STANDARDS INSTITUTE, FOR ACCESSIBILITY COMPLIANCE.		
QUANTITY	BRADLEY NO. OR EQUAL	DESCRIPTION
3	508-32	SURFACE MOUNTED TOILET TISSUE DISPENSER.
3	6542	SURFACE MOUNTED TANK TYPE HORIZONTAL SOAP DISPENSER.
2	832	24" STAINLESS STEEL GRAB BAR 1 1/4" O.D. STANDARD FINISH.
2	892	42" STAINLESS STEEL GRAB BAR 1 1/4" O.D. STANDARD FINISH.
3	700-2430	FRAMED MIRROR, SATIN FINISH AND WALL HUNG.

PLUMBING FIXTURE SCHEDULE

ITEM	DESCRIPTION
WC-1	KOHLER K-3527-EB "HIGHLINE", 18" HIGH WHITE VITREOUS CHINA, 3.5 GALLON FLUSH, ELONGATED BOWL, SIPHON JET FLUSHING AND 52048 BOLT CAPS; 30851 FLOAT VALVE, K-4852 LUSTRA SOLID PLASTIC SEAT & COVER, CLOSED FRONT.
WC-2	KOHLER K-3520-EB "WELLWORTH" OR EQUAL 14 1/4" HIGH WHITE VITREOUS CHINA, 3.5 GALLON FLUSH, ELONGATED BOWL, SIPHON JET FLUSHING AND 52048 BOLT CAPS; 30853 FLOAT VALVE AND VACUUM BREAKER, K-4857 LUSTRA SOLID PLASTIC SEAT & COVER OPEN FRONT.
LAV	KOHLER K-2032-AA WALL HUNG WITH NO. 895-317 FAUCET
FD	WADE W-1100-A CAST IRON WITH SEPARATE TRAP WITH CLEANOUT AND POLISHED BRASS RIM AND STRAINER
HB	CHICAGO NO. 293 HOSE BIBB; 3/4" HOSE THREAD ON OUTLET; NO 293-6 REMOVABLE TEE HANDLE; ROUGH CHROME PLATED; WITH NO. E27 VACUUM BREAKER. FROST-PROOF HOSE BIBBS TO BE PROVIDED
UR	URINAL, WALL HUNG, KOHLER NO. K-4980-T WITH SLOAN NO. 186 FLUSH VALVE

PLUMBING LEGEND OF SYMBOLS

—	= SANITARY LINE
—	= 1 1/2" VENT TO CLOSEST 4" VT
○	= VENT OR WATERLINE UP WALL
○ 4" VTR	= 4" VENT THRU ROOF
⊗ F.D.	= 3" FLOOR DRAIN
H	= HOSE BIBB
—	=
C.O.	= CLEANOUT
⊕	= WATER METER
⊕ W.H.	= WATER HEATER
UR	= URINAL
W.C.	= WATER CLOSET
LAV.	= LAVATORY
SK	= SINK

PLUMBING GENERAL NOTES:

THE WORK TO BE PERFORMED SHALL INCLUDE ALL LABOR, MATERIALS, EQUIPMENT, TRANSPORTATION, CONSTRUCTION FACILITIES AND INCIDENTALS NECESSARY FOR THE PROPER EXECUTION AND COMPLETION OF ALL PLUMBING AND PIPING WORK AS SHOWN AND INDICATED ON THE CONTRACT DRAWINGS, AND/OR HEREIN SPECIFIED WITH THE INTENT THAT THE INSTALLATION SHALL BE COMPLETE IN EVERY RESPECT AND READY FOR USE. THE INSTALLATION SHALL COMPLY WITH ALL LOCAL, STATE AND FEDERAL CODES, NFPA, AND ILLINOIS PLUMBING CODE.

PIPES AND PIPE FITTINGS

WATER SERVICE LINE TO BE INSTALLED W/10'-0" FROM ANY DRAIN OR SEWER.

ALL DRAINS TO BE PROPERLY TRAPPED AND VENTED.

WASTE AND VENT PIPING - SCHEDULE 40 PVC PIPING WITH SOLVENT WELDED JOINTS.


ABOVE SLAB DOMESTIC WATER PIPING TYPE L HARD COPPER WITH WROUGHT SWEATED FITTINGS.

BELOW GRADE DOMESTIC WATER PIPING TYPE K HARD COPPER.


ABOVE GROUND GAS PIPING - SCHEDULE 40 BLACK STEEL WITH MALLEABLE, SWEATED FITTINGS.

EXTERIOR SEWER PIPING

A. SANITARY SEWERS: SCHEDULE 40 PVC WITH SOLVENT WELDED JOINTS, OR ASTM D-3034, SDR 35, PVC, WITH RING-TIGHT ASTM D-3212 FLEXIBLE JOINTS.

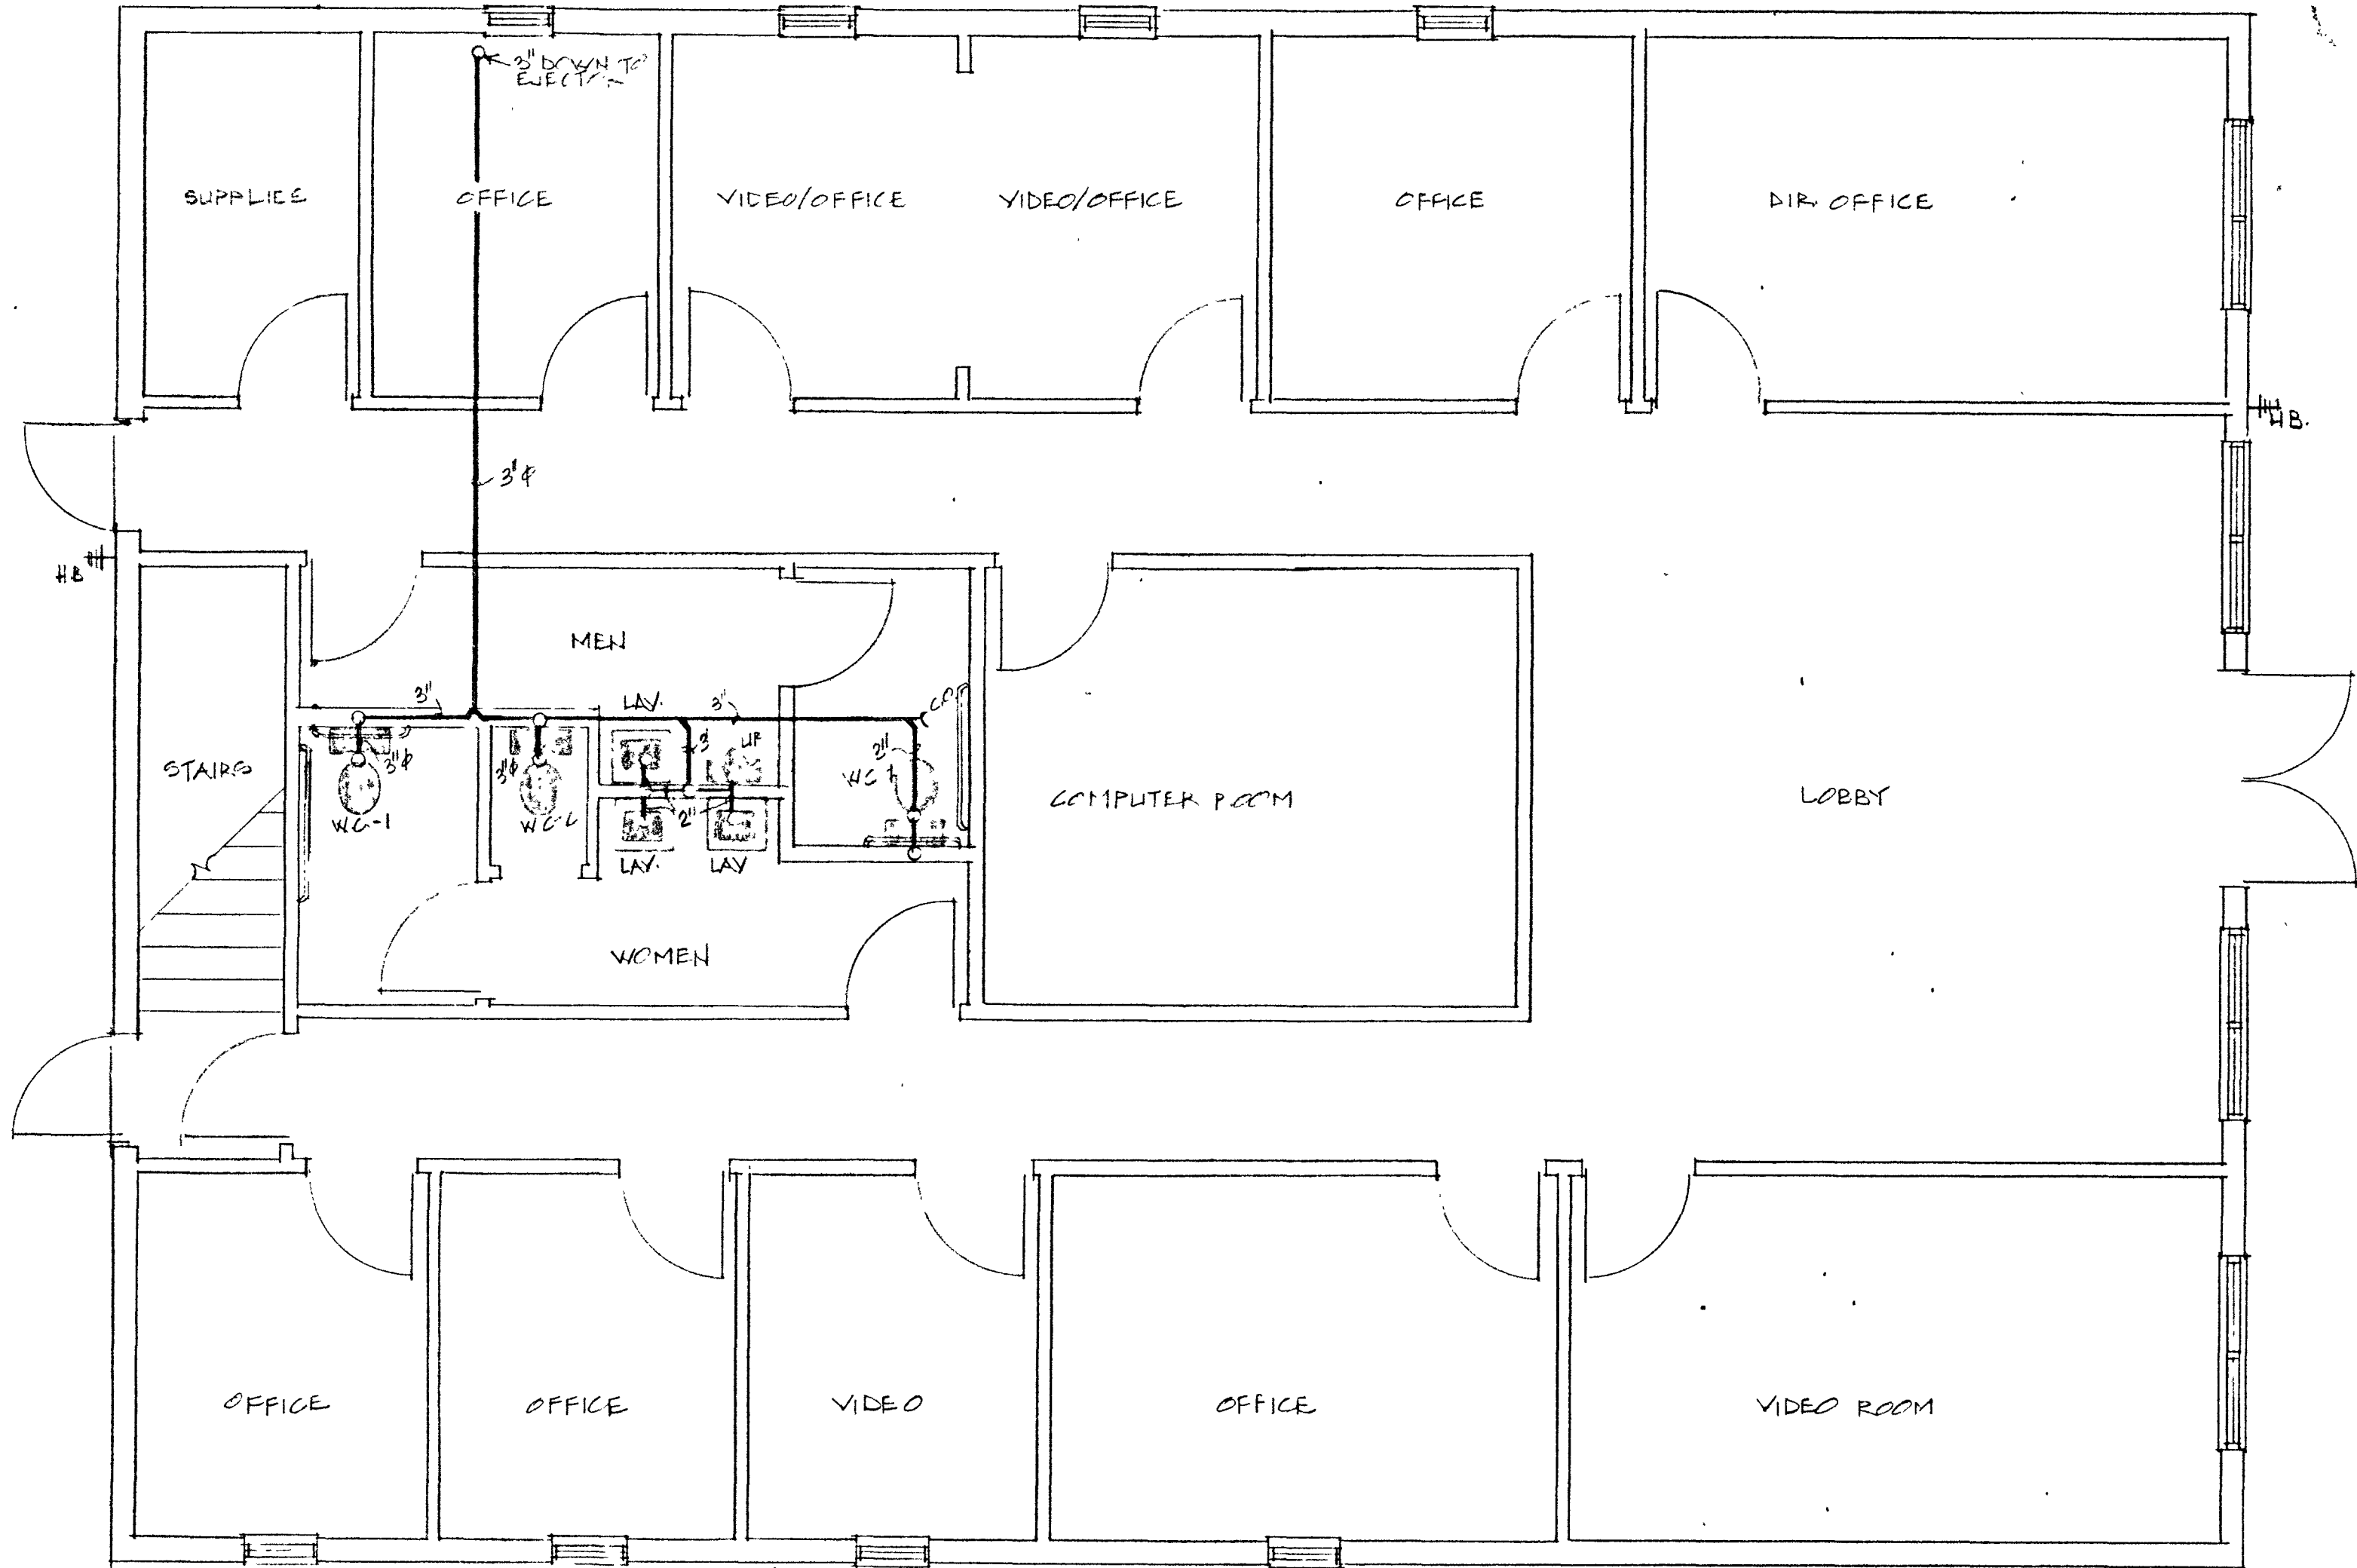

MAIN LEVEL PLUMBING PLAN
SCALE: 1/4" = 1'-0"

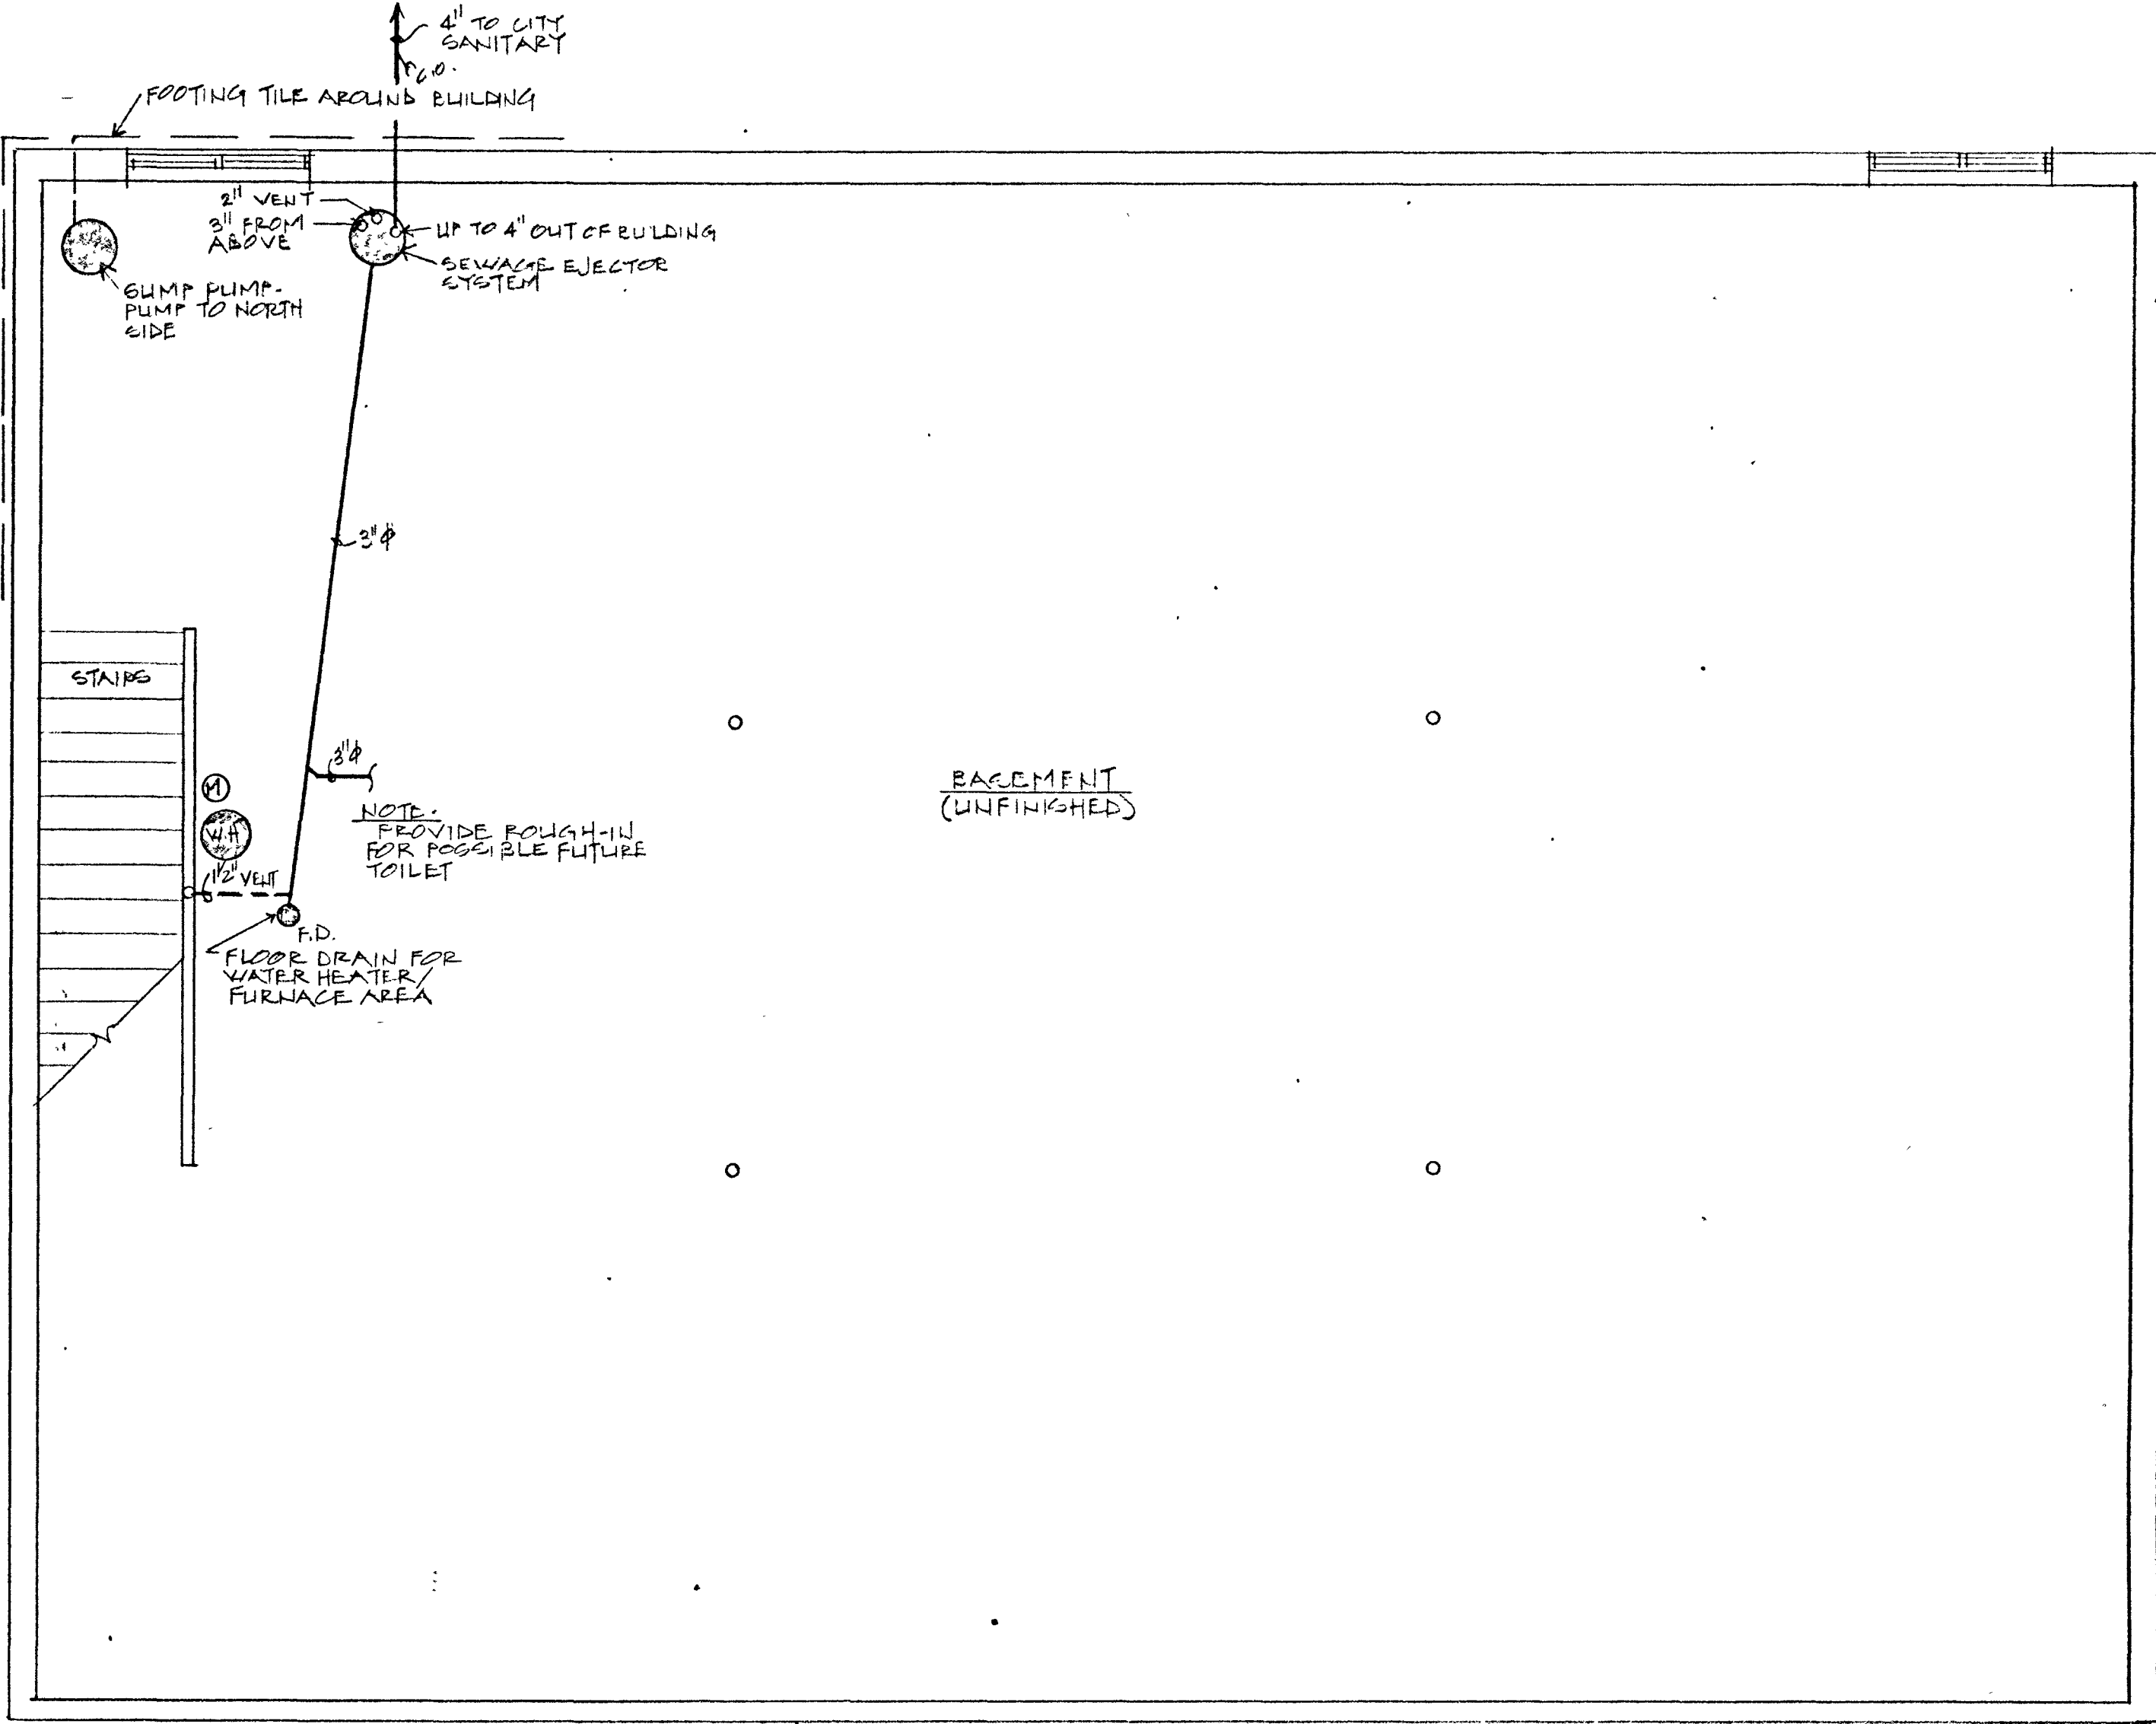

BASEMENT PLUMBING PLAN
SCALE: 1/4" = 1'-0"

ADMISSIONS BUILDING for
LINCOLN COLLEGE
LINCOLN, ILLINOIS

Date	4/4/2019	Project	No.
			98-15-S
		Drawn By	K.A.S.



KELLY A. SANNER

Architect ▼ Planner ▼ Construction Mgr

Sheet No.
P-1