


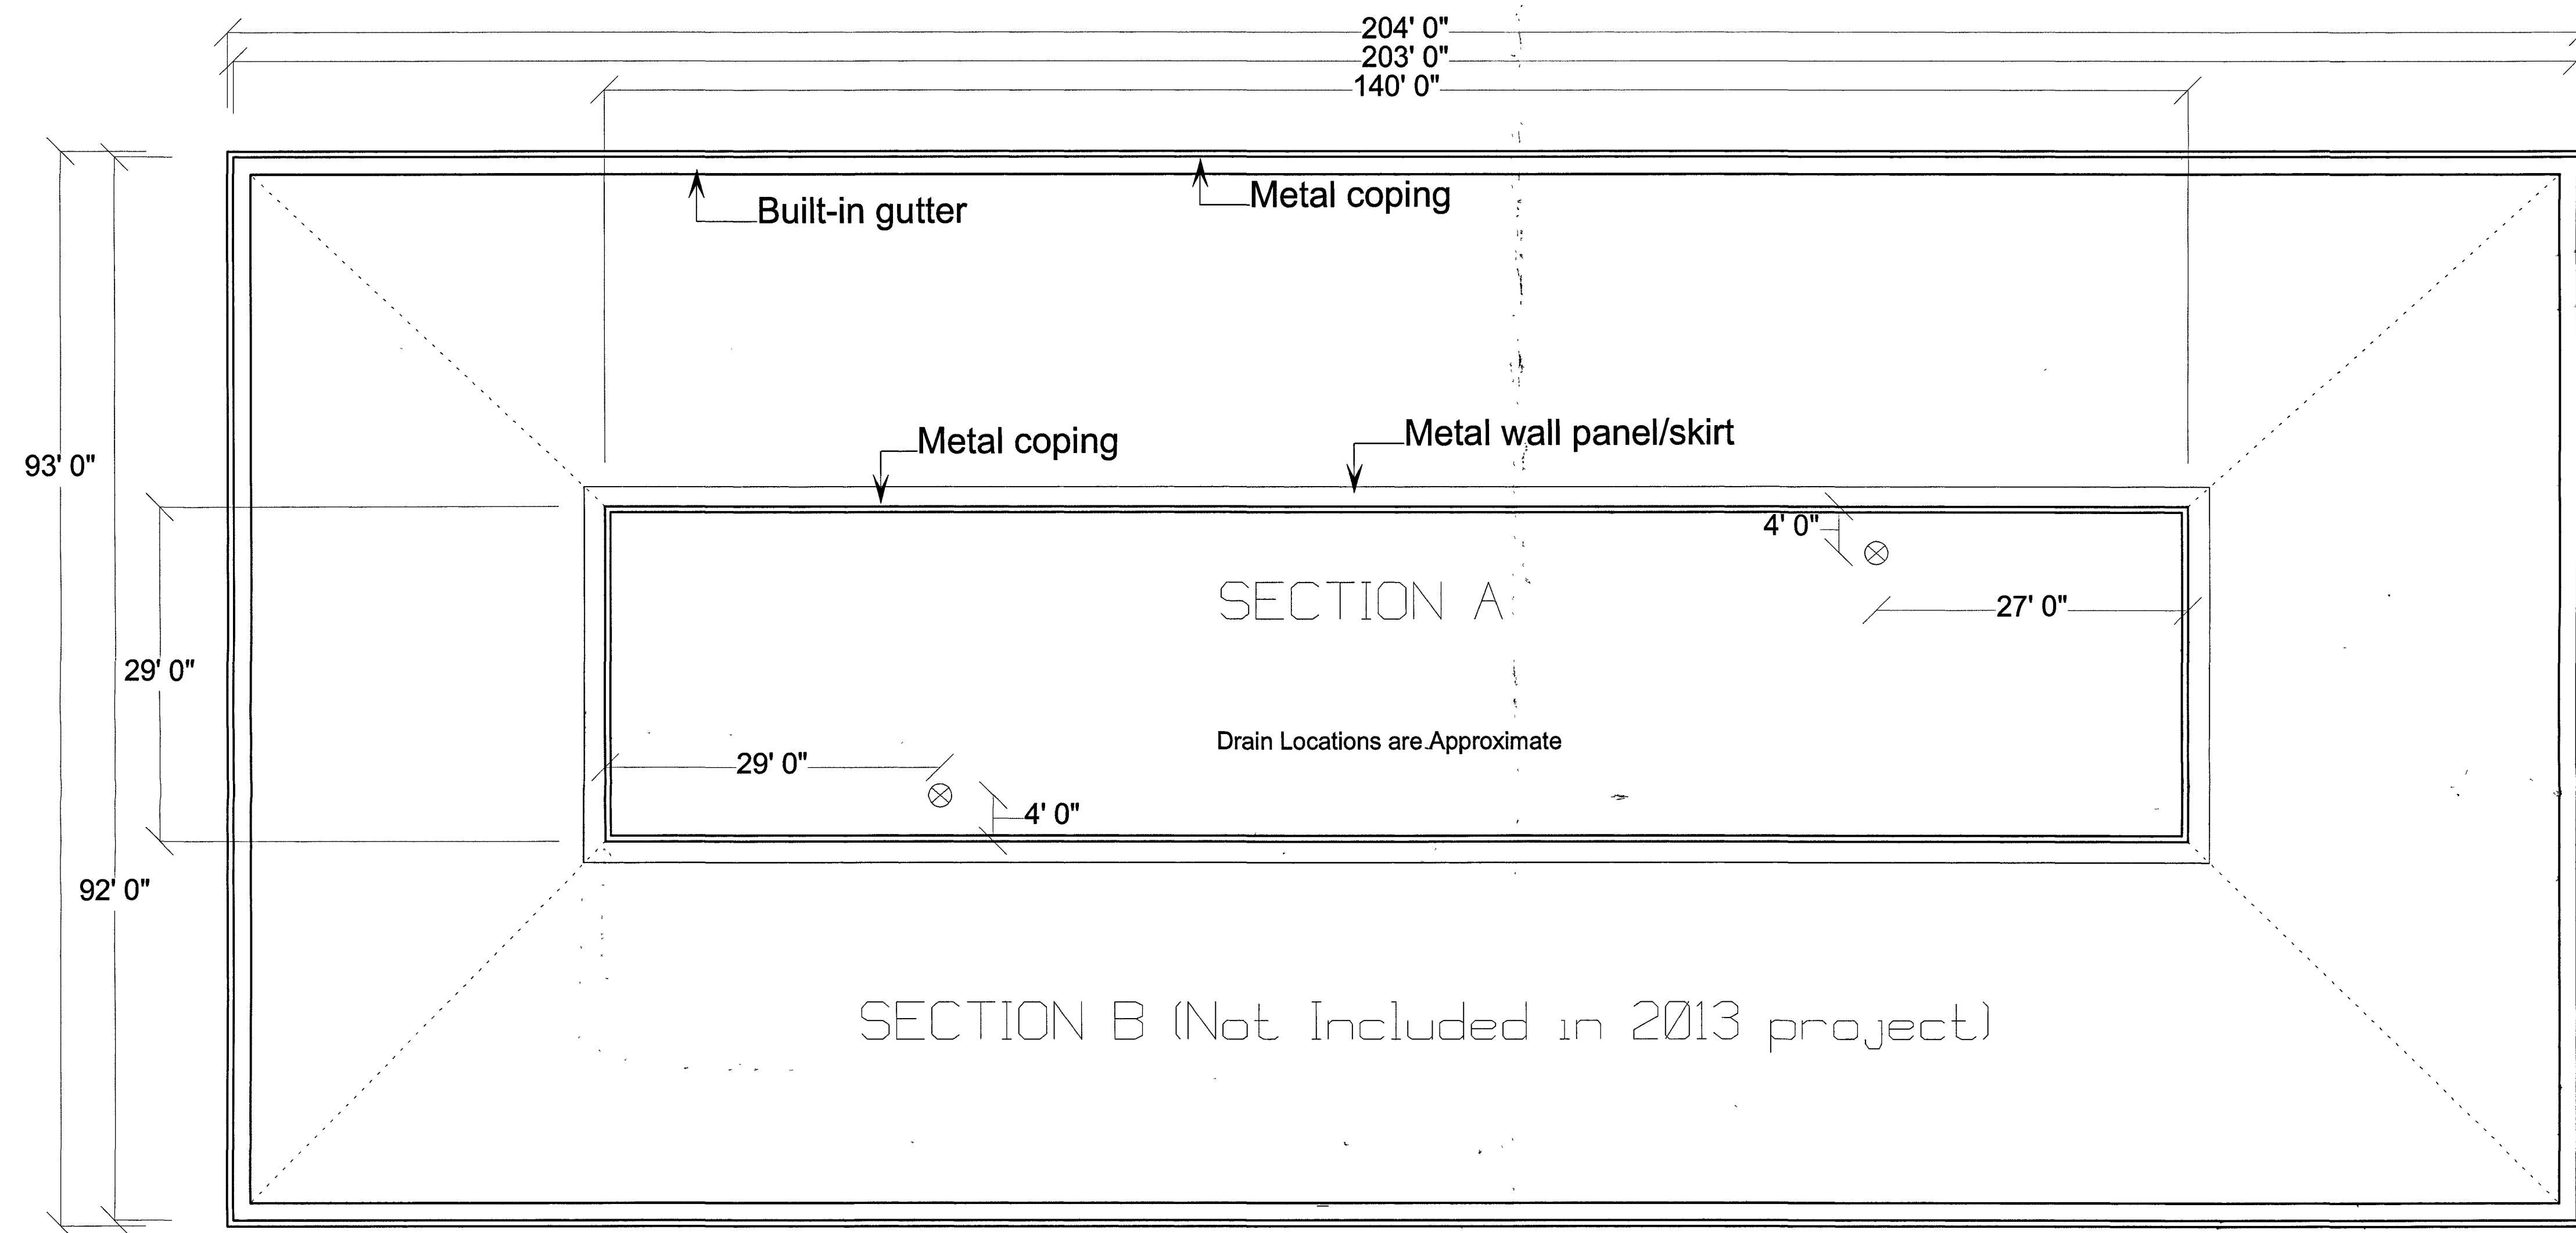

McKINSTRY LIBRARY


TRESCO

REVISED	DATE
SCALE	
COMM No	
PROJ MGR	
DRAWN BY	DSH

ROOF PLAN

DRAWING No

RP1

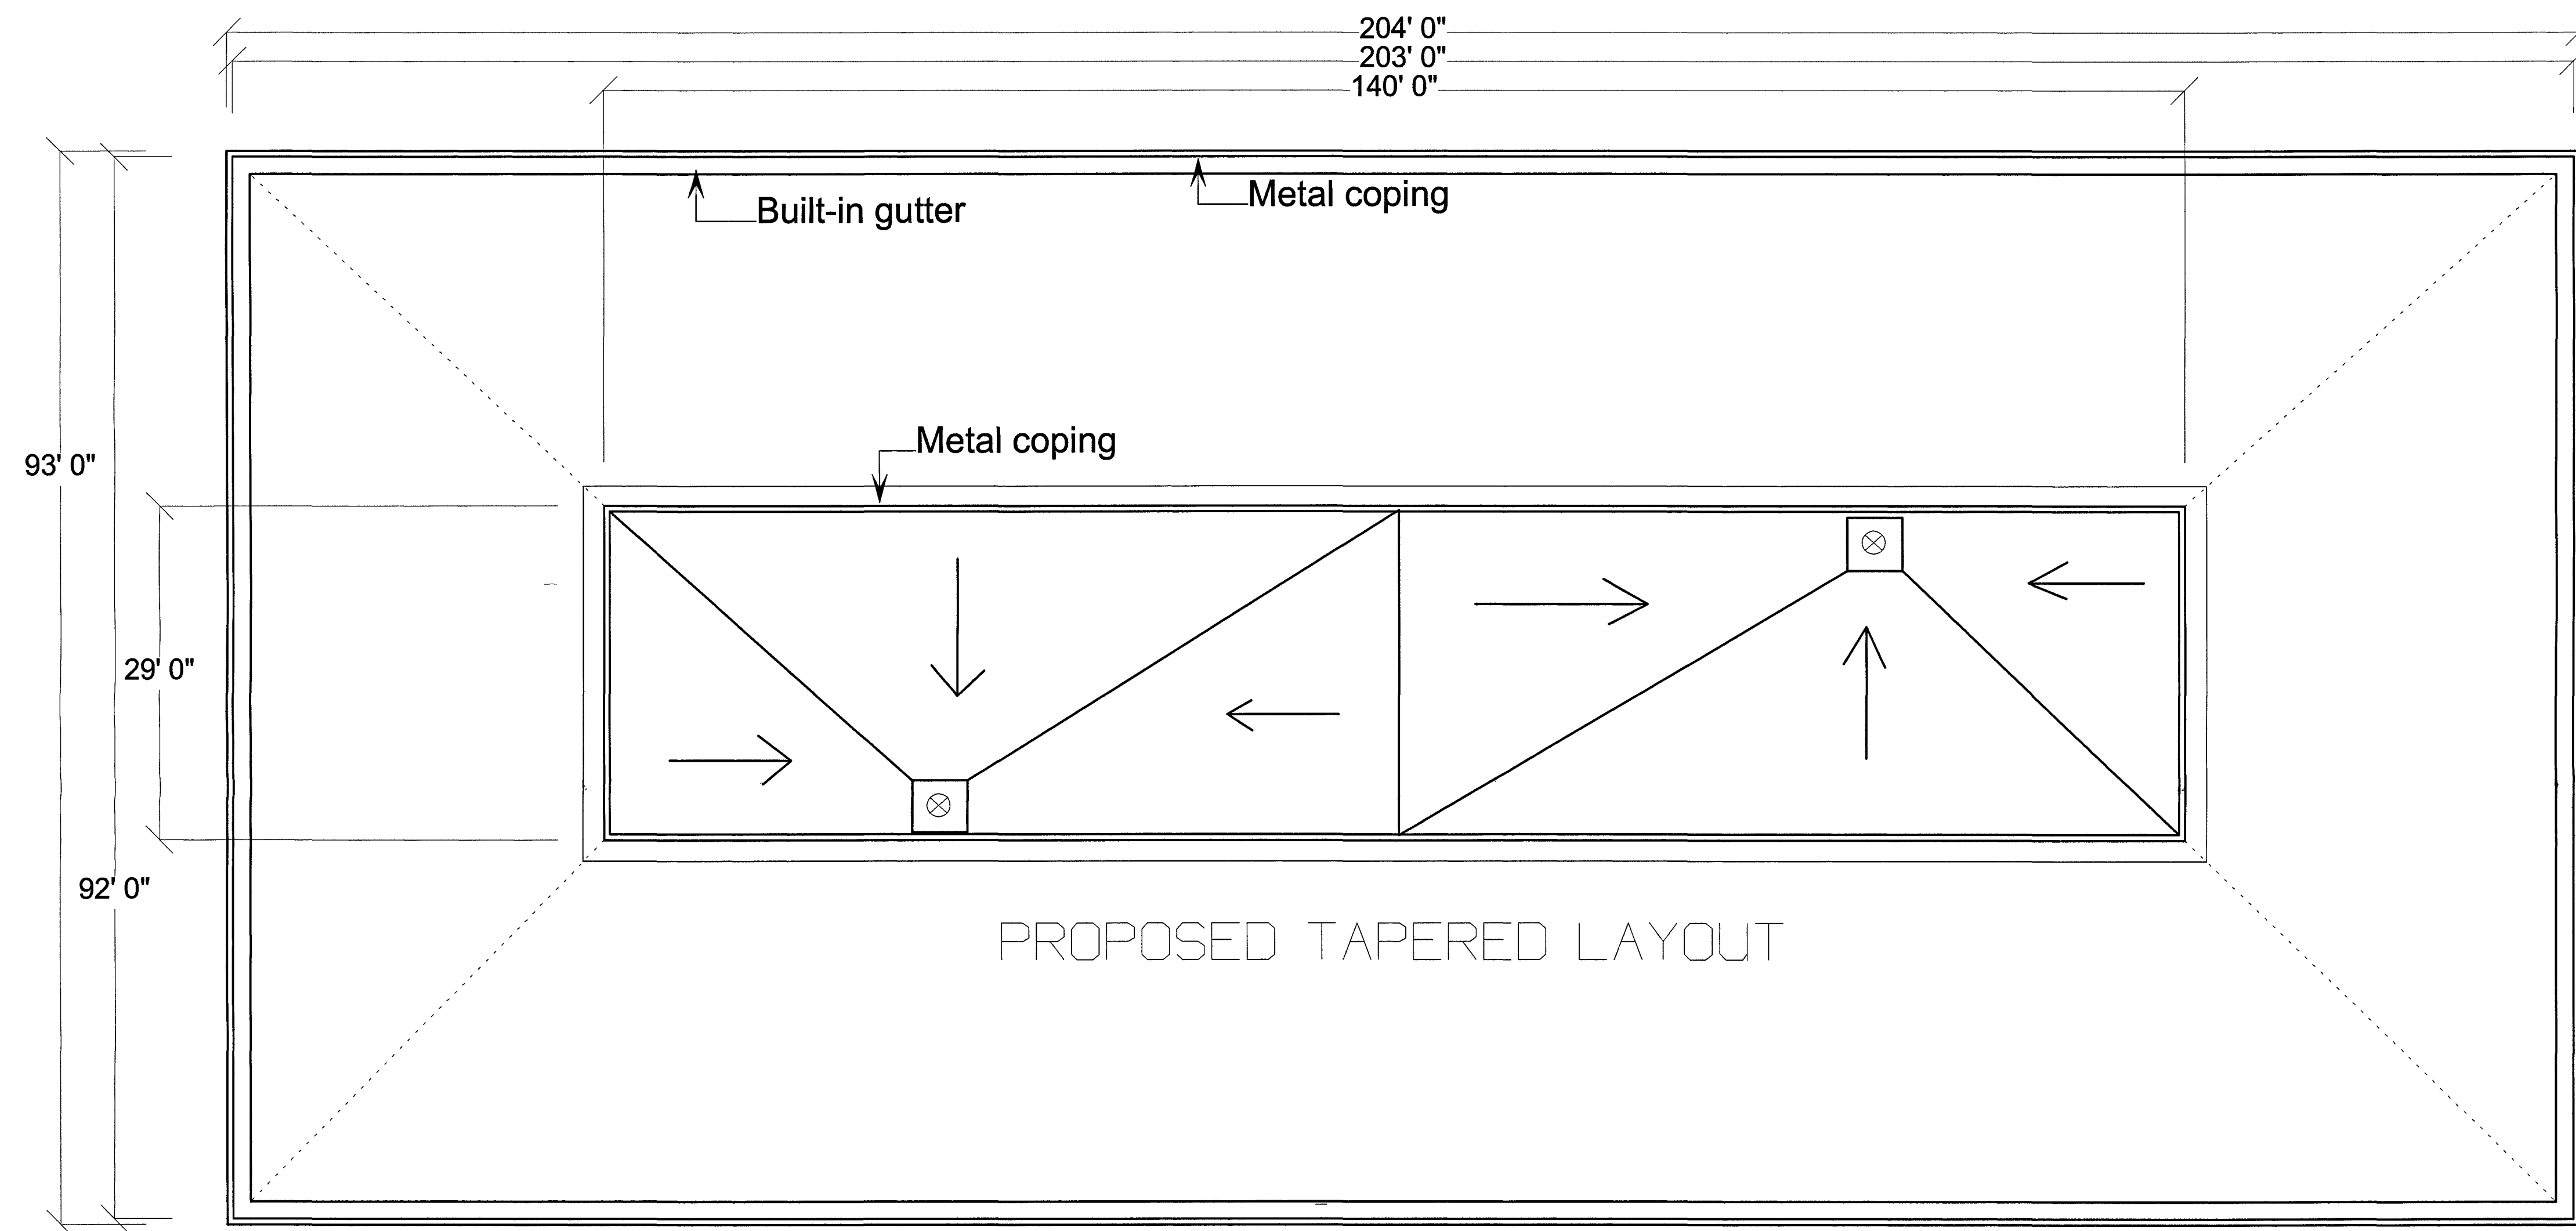

McKINSTRY LIBRARY













TRESCO

REVISED	DATE
SCALE	
COMM. No.	
PROJ. MGR.	
DRAWN BY	DSH

ROOF PLAN

DRAWING No.

RP2

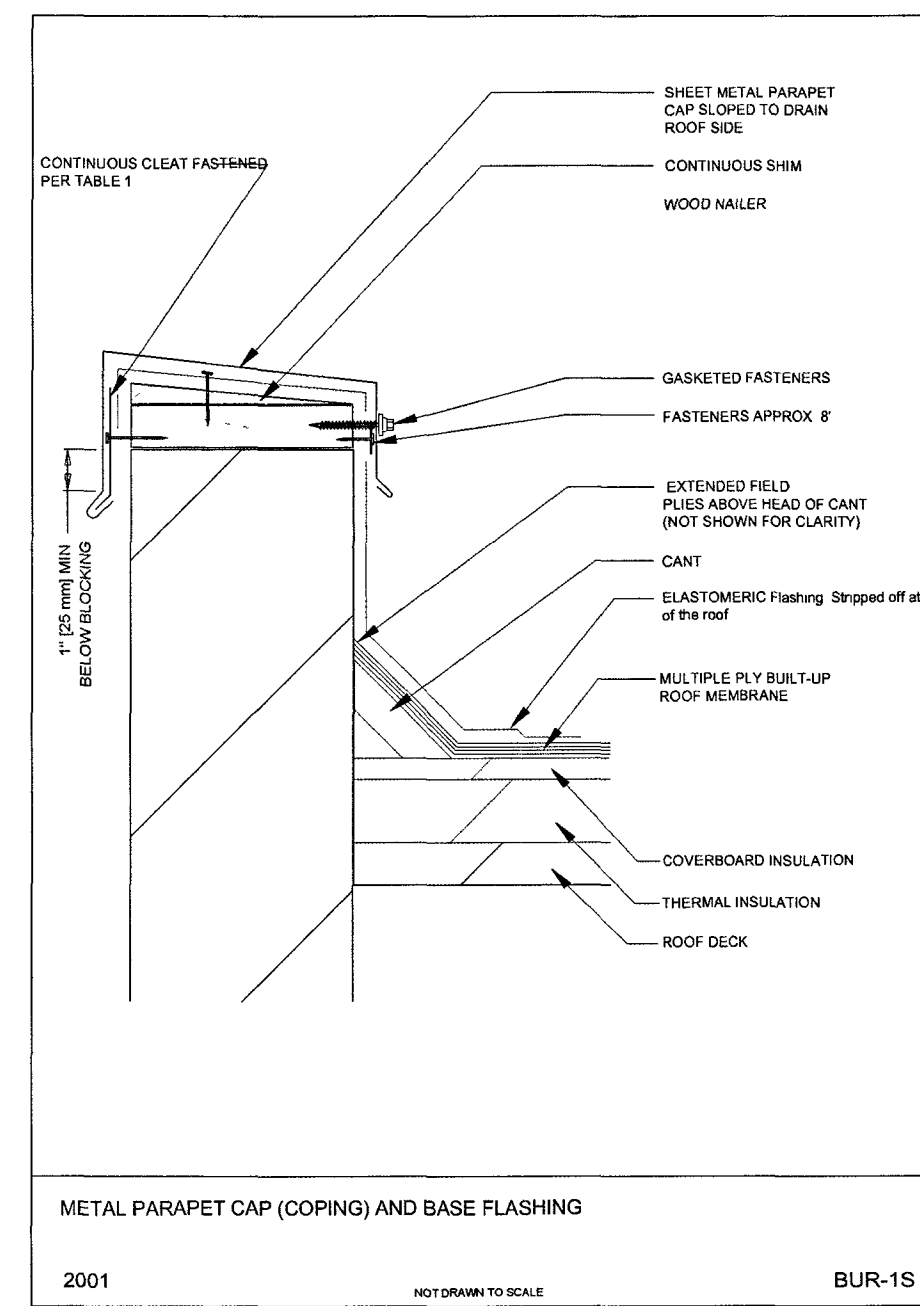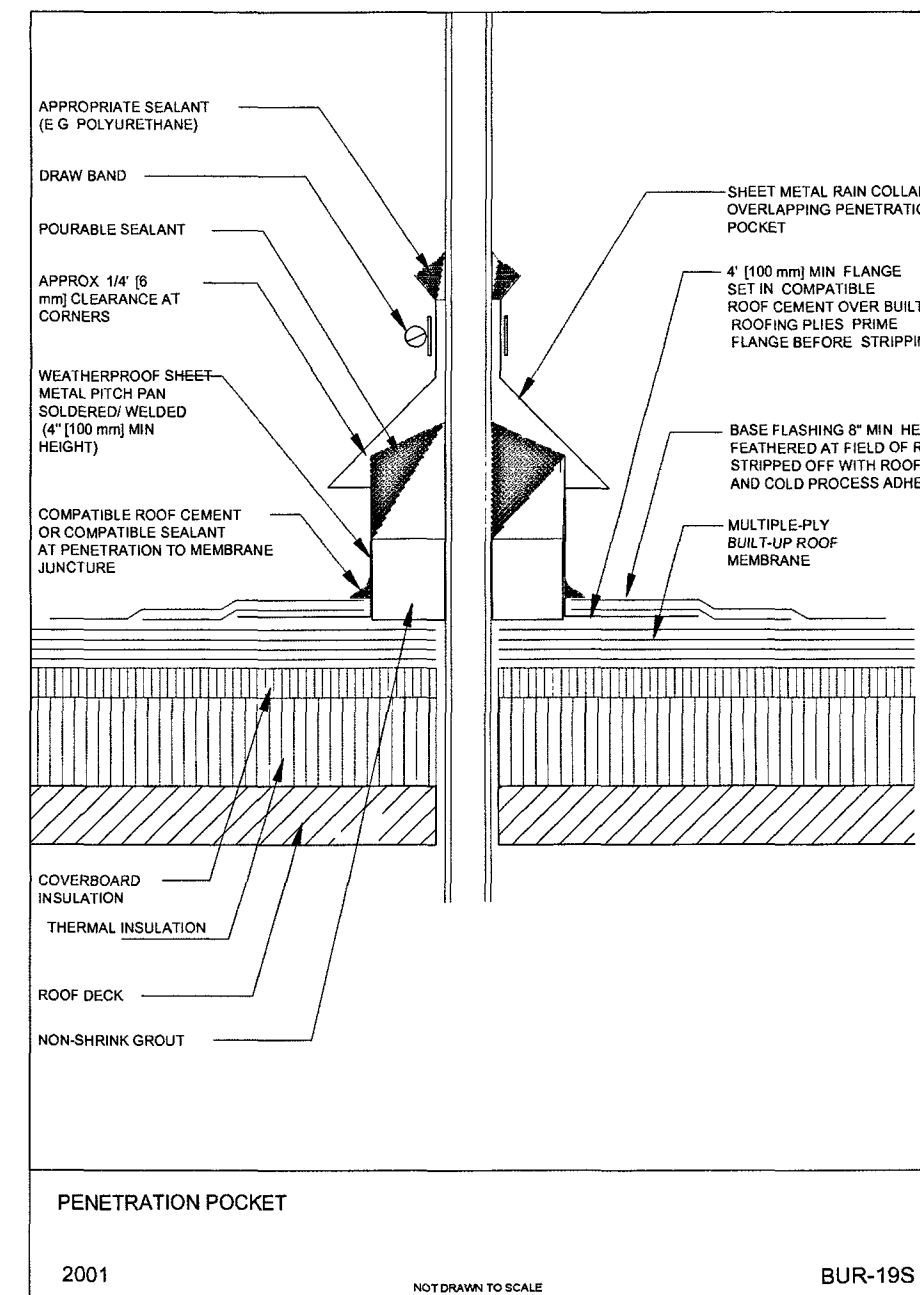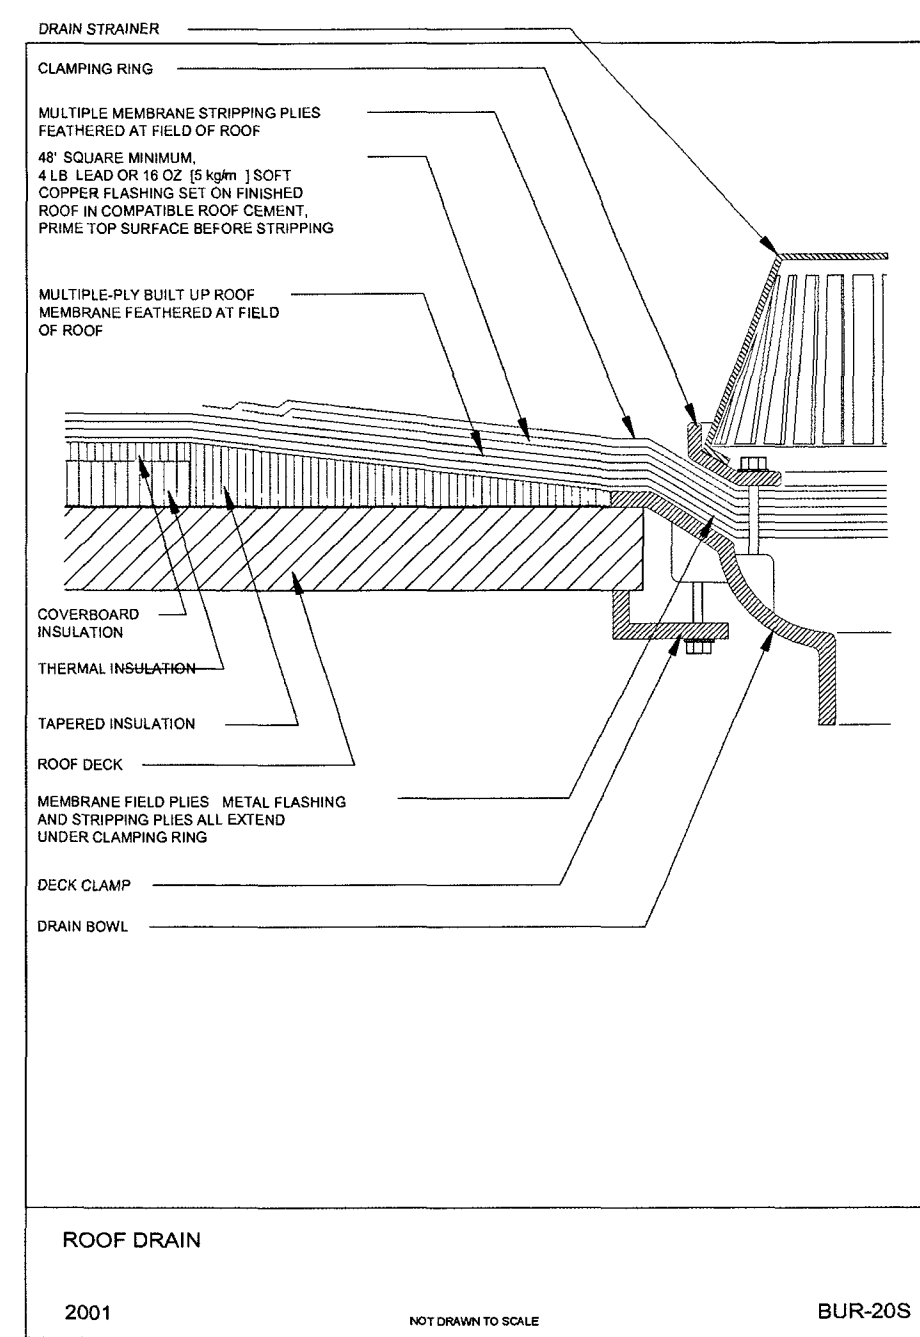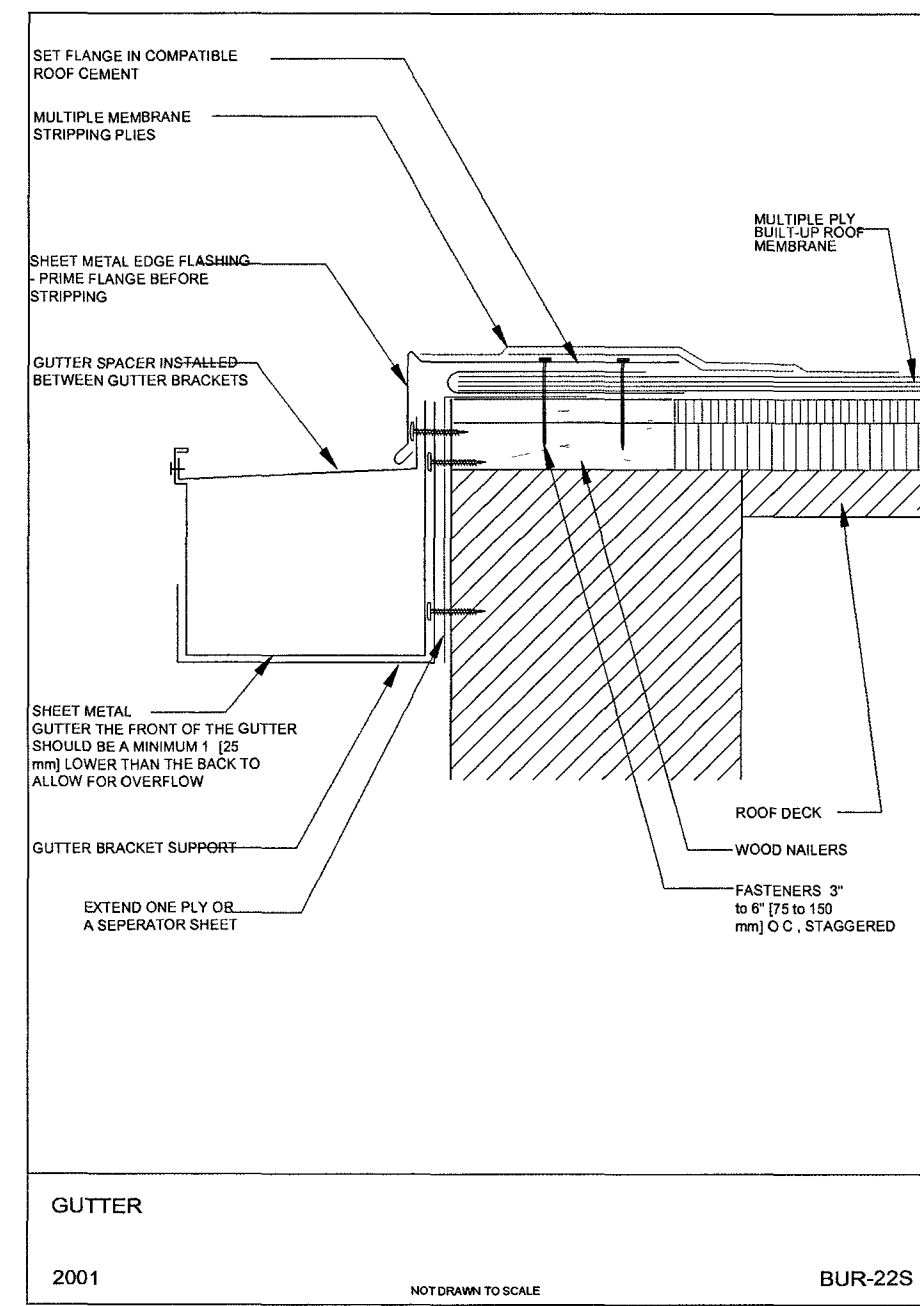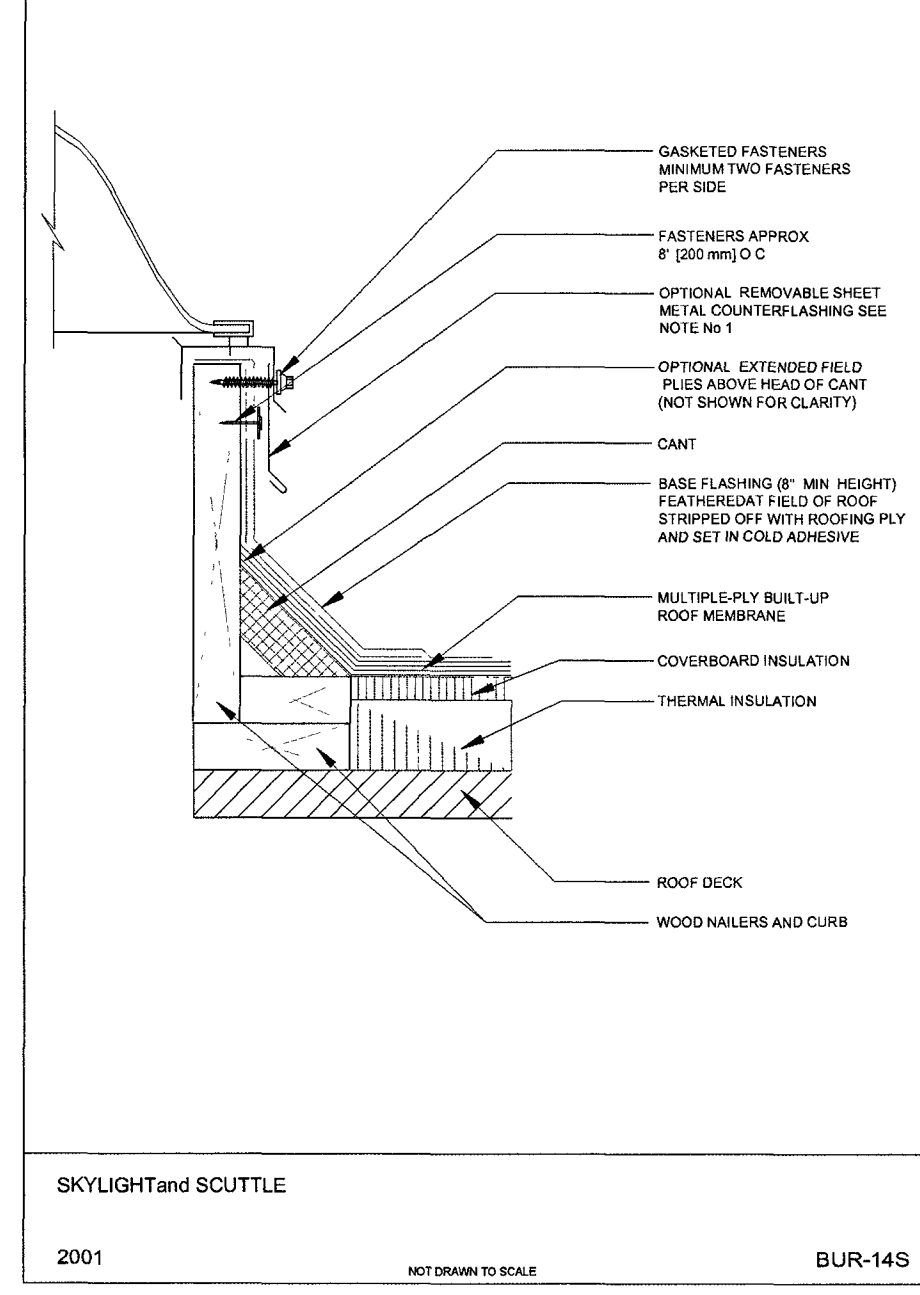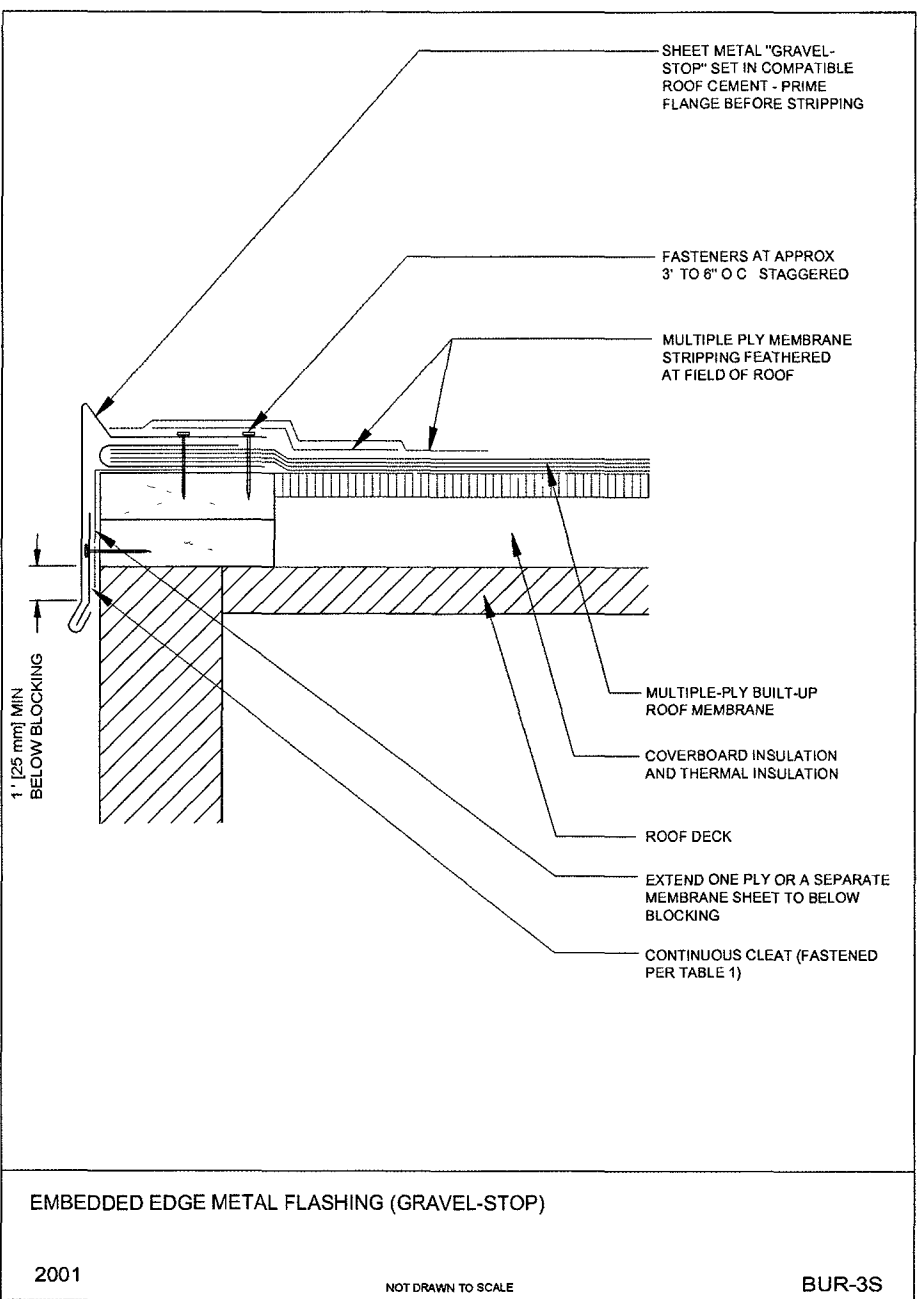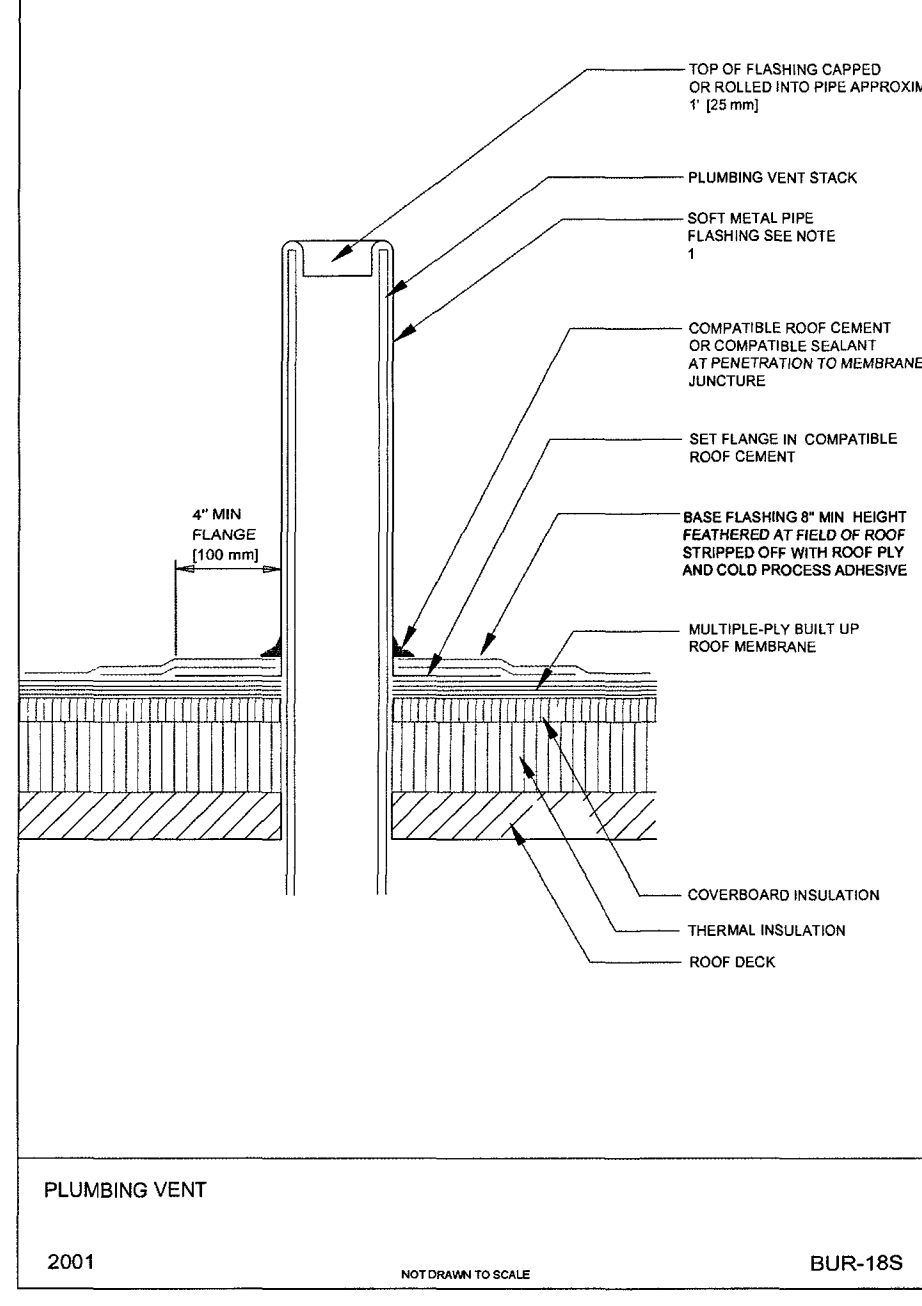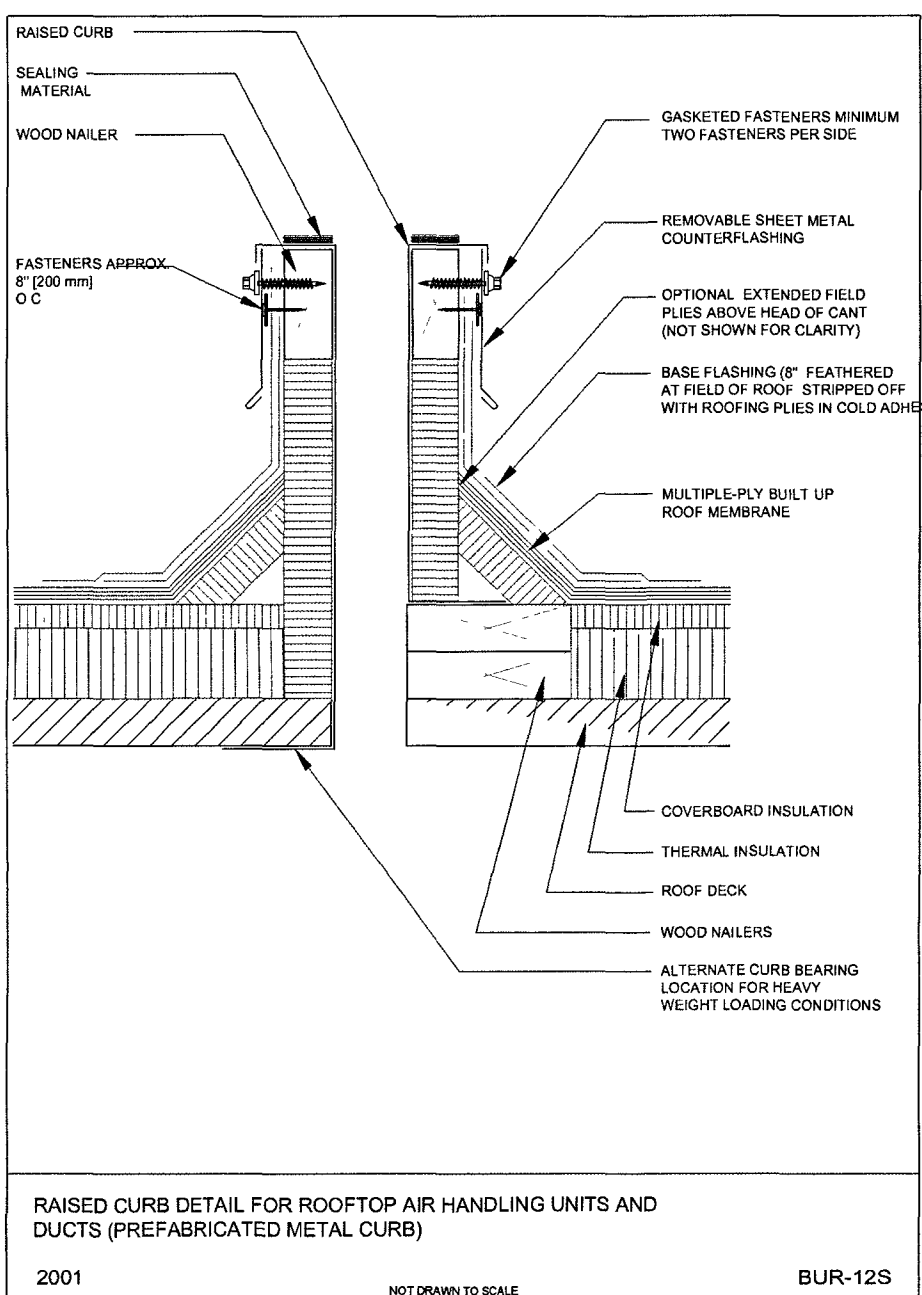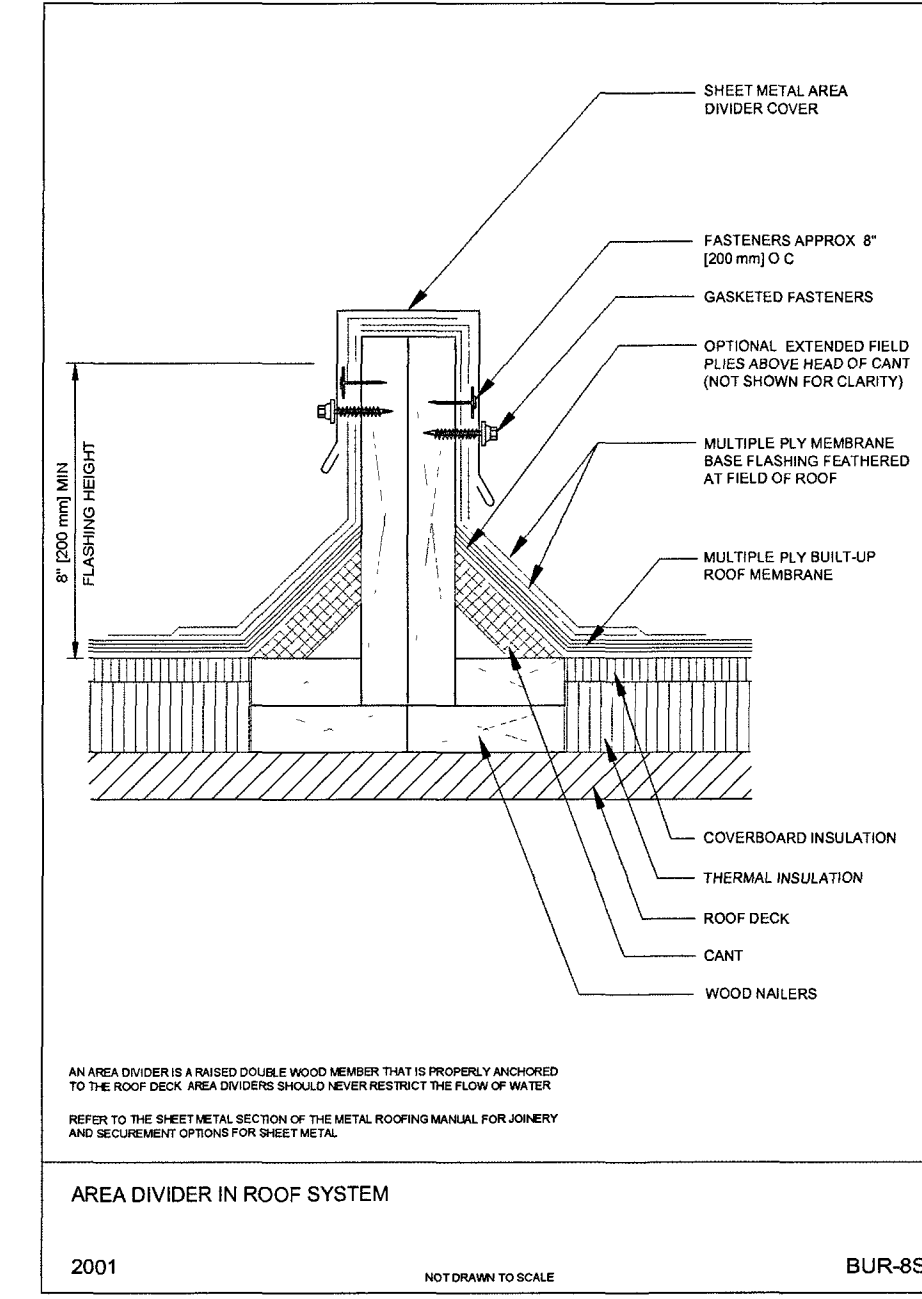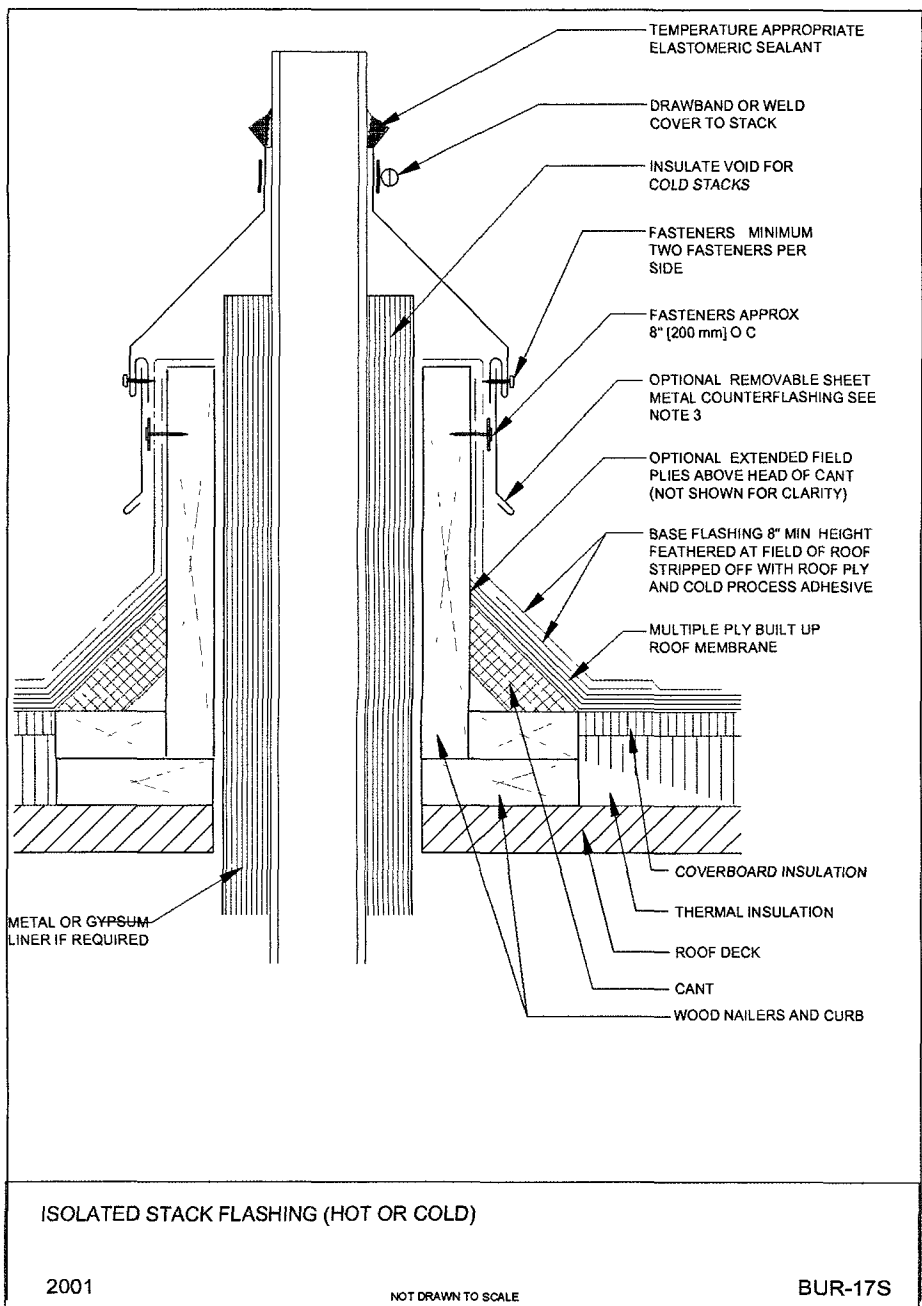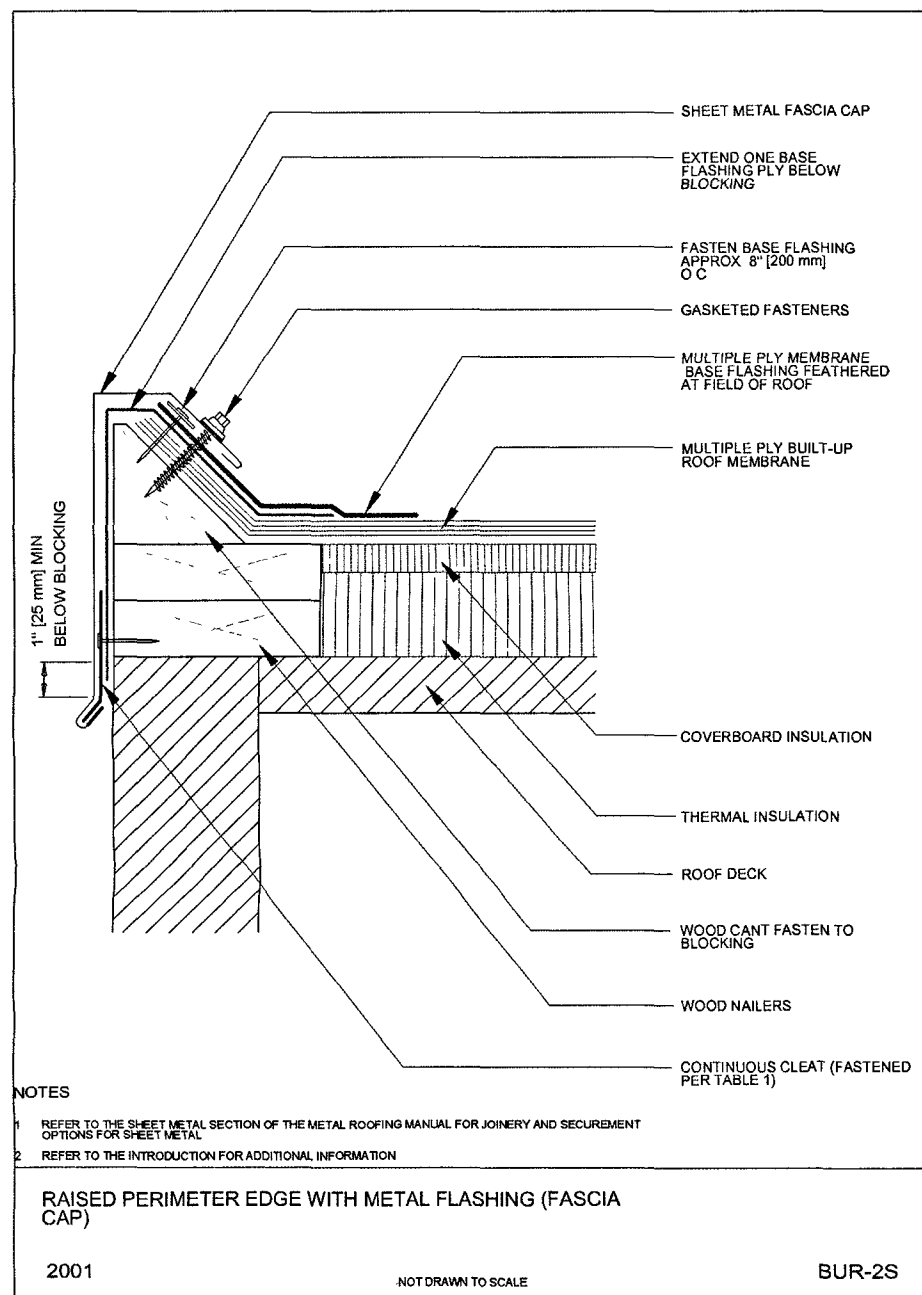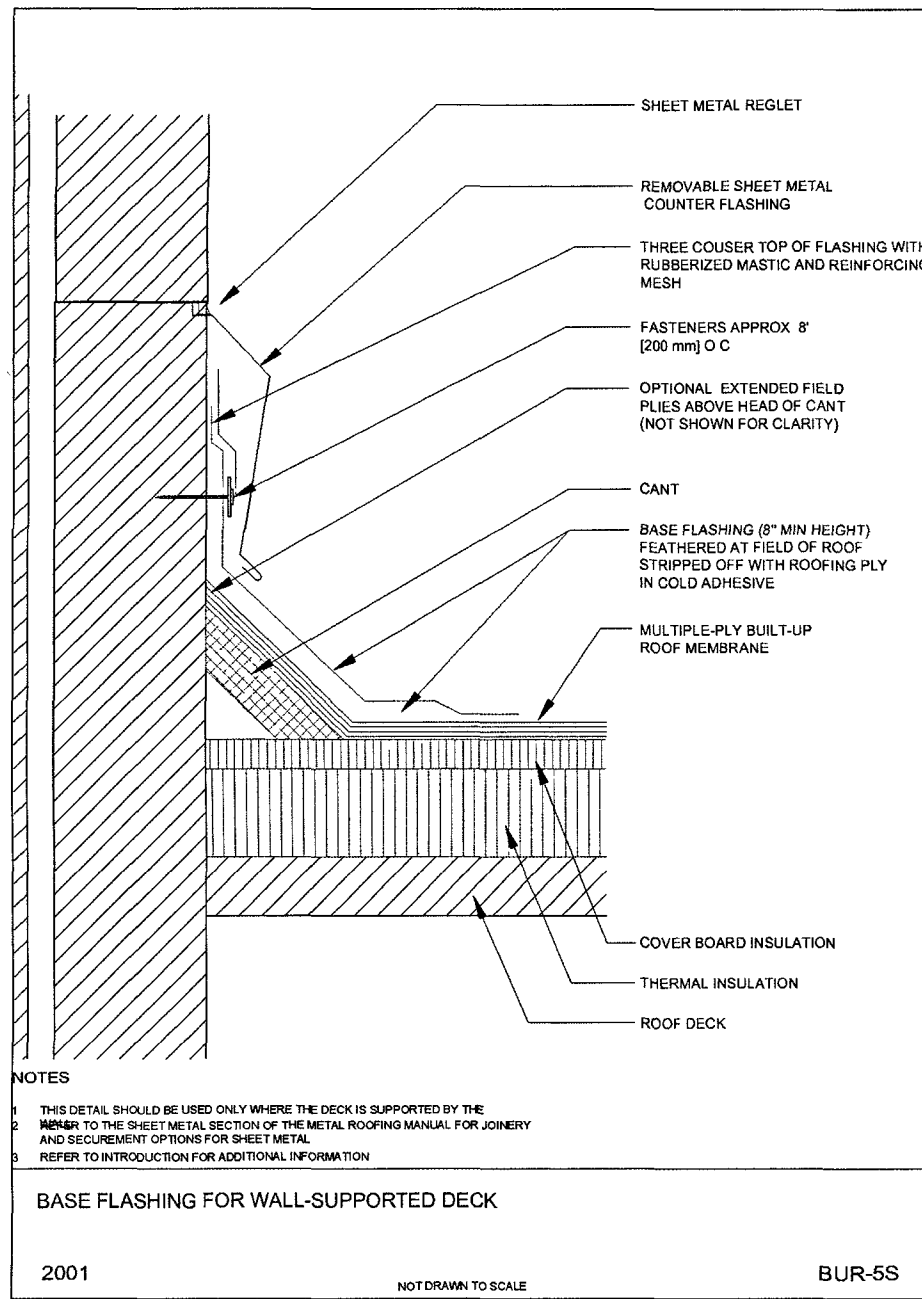

Notes:

HOT APPLIED
BUILT UP ROOF
DETAILS

LINCOLN COLLEGE
LINCOLN, IL

Drawn By: Dan Janssen
Date: 3/04/13

D-1